
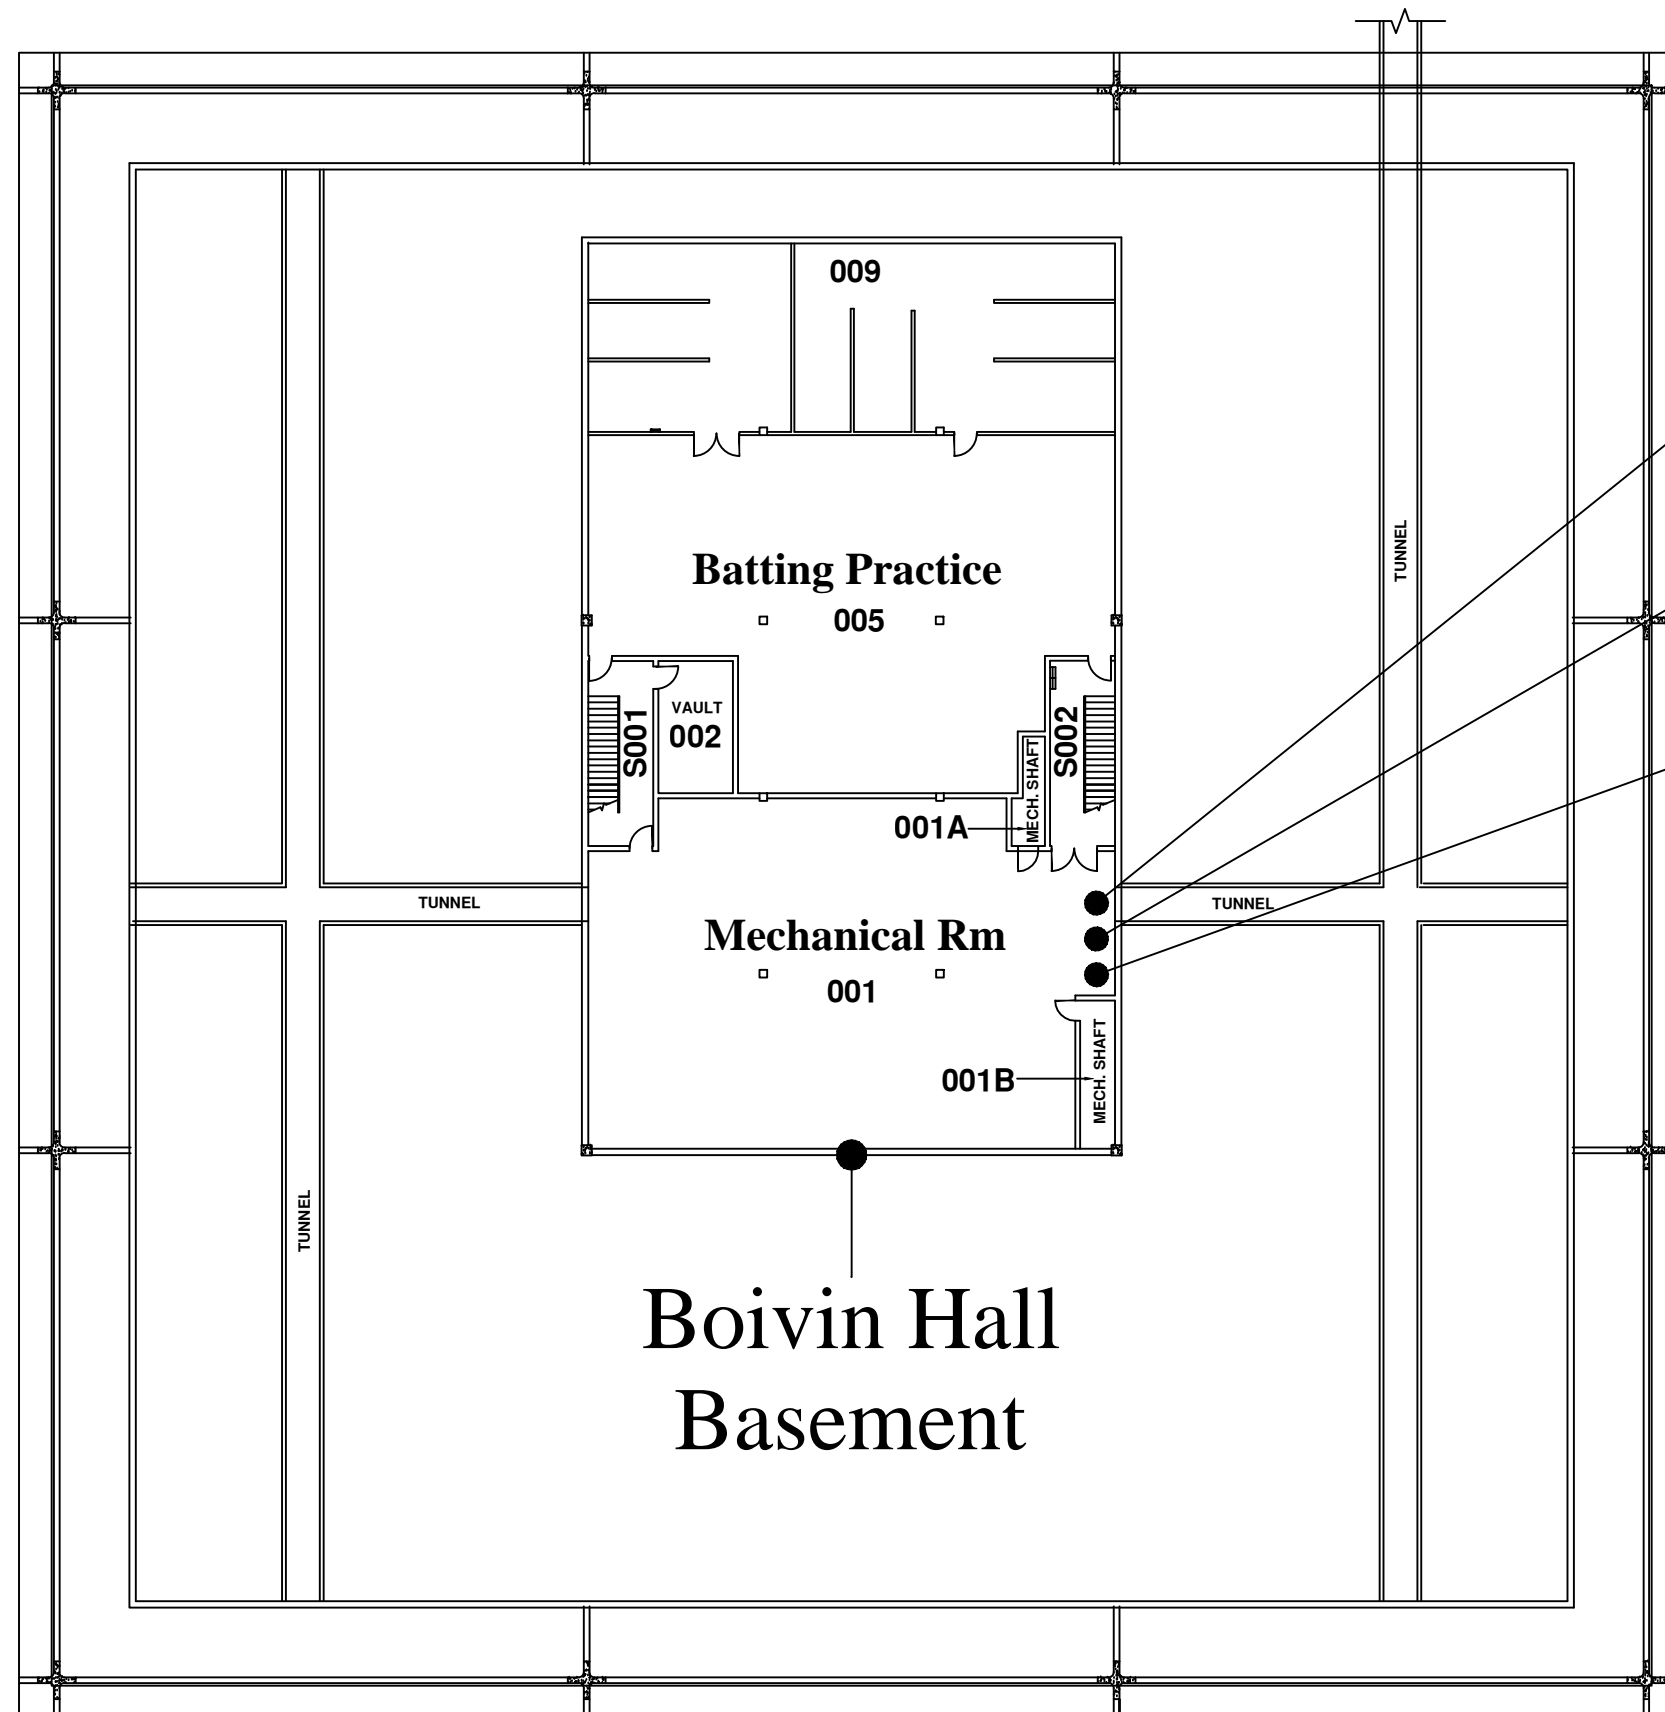


FDC

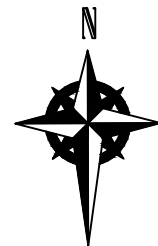

**Wet Sys.
Basement Only**


Backflow

**Wet Riser &
Inspector Test**

Deluge/Pre-Action Sys.

**Apx 50 Total Heads
138, 134, 152, 126B, 126C**

Boivin Hall Basement

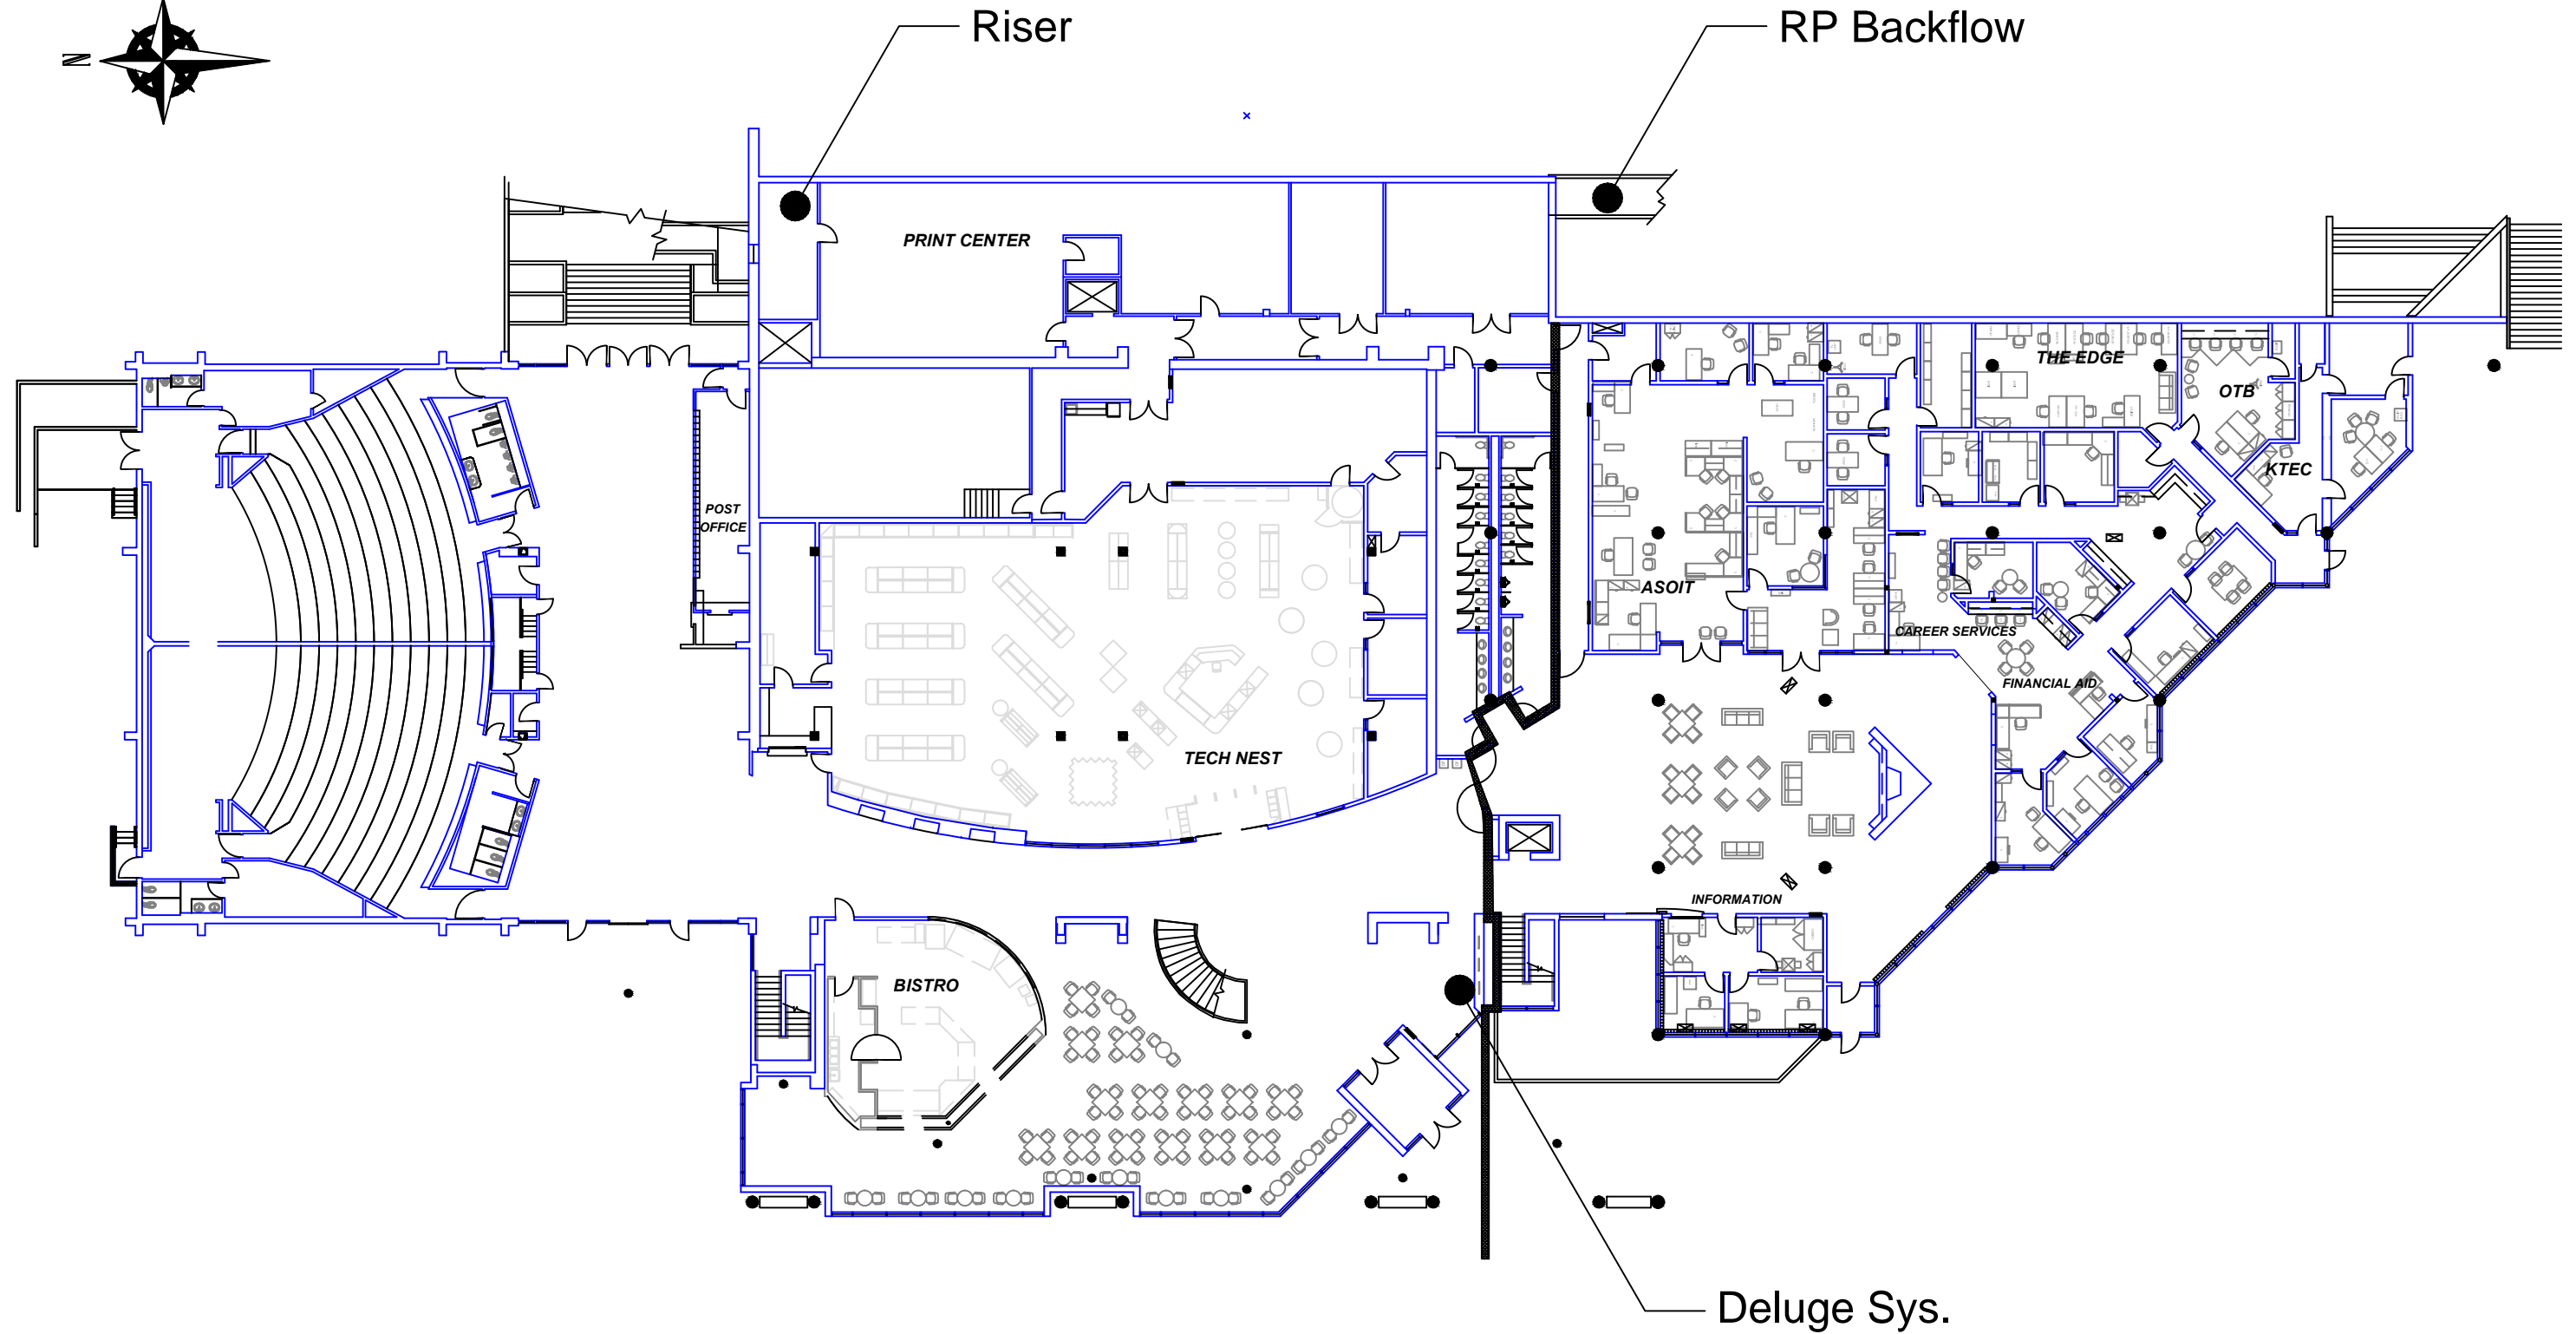



OREGON INSTITUTE OF TECHNOLOGY
College Union 1st Floor

Path: (T:)_Facilities_Campus...Floor...
Prepared by: Dustin Huddleston

Scale: NTS
Date: 10/31/2013

Glycol Sys. "Trash" 2 Heads

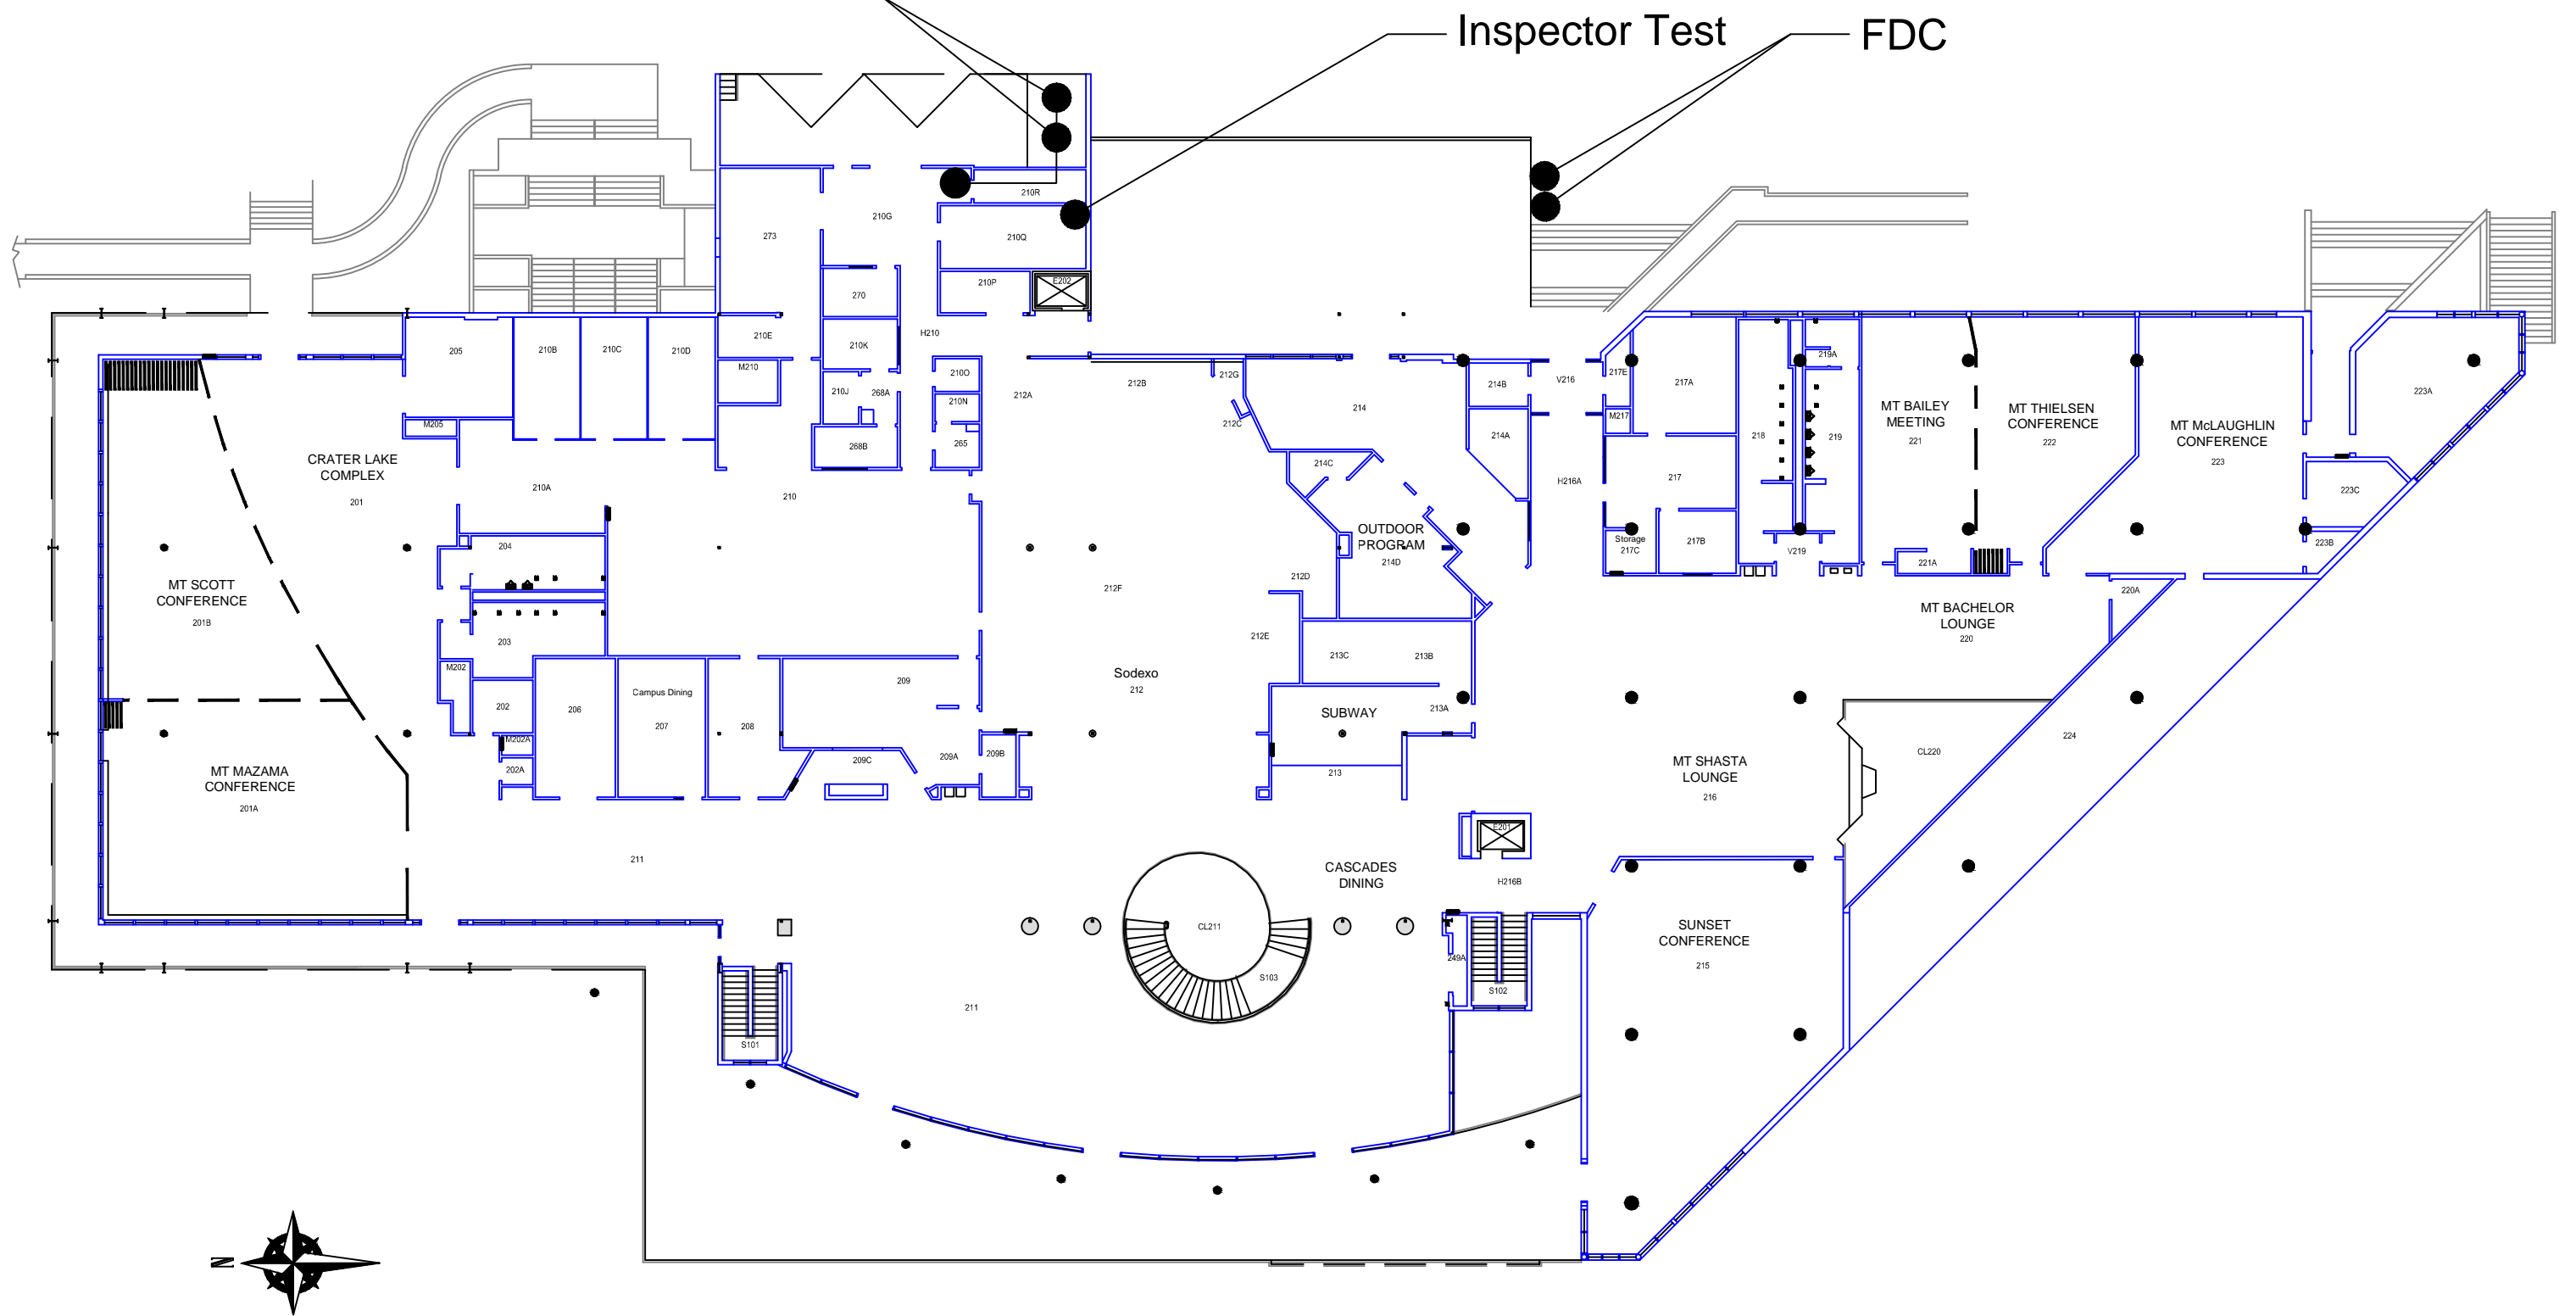

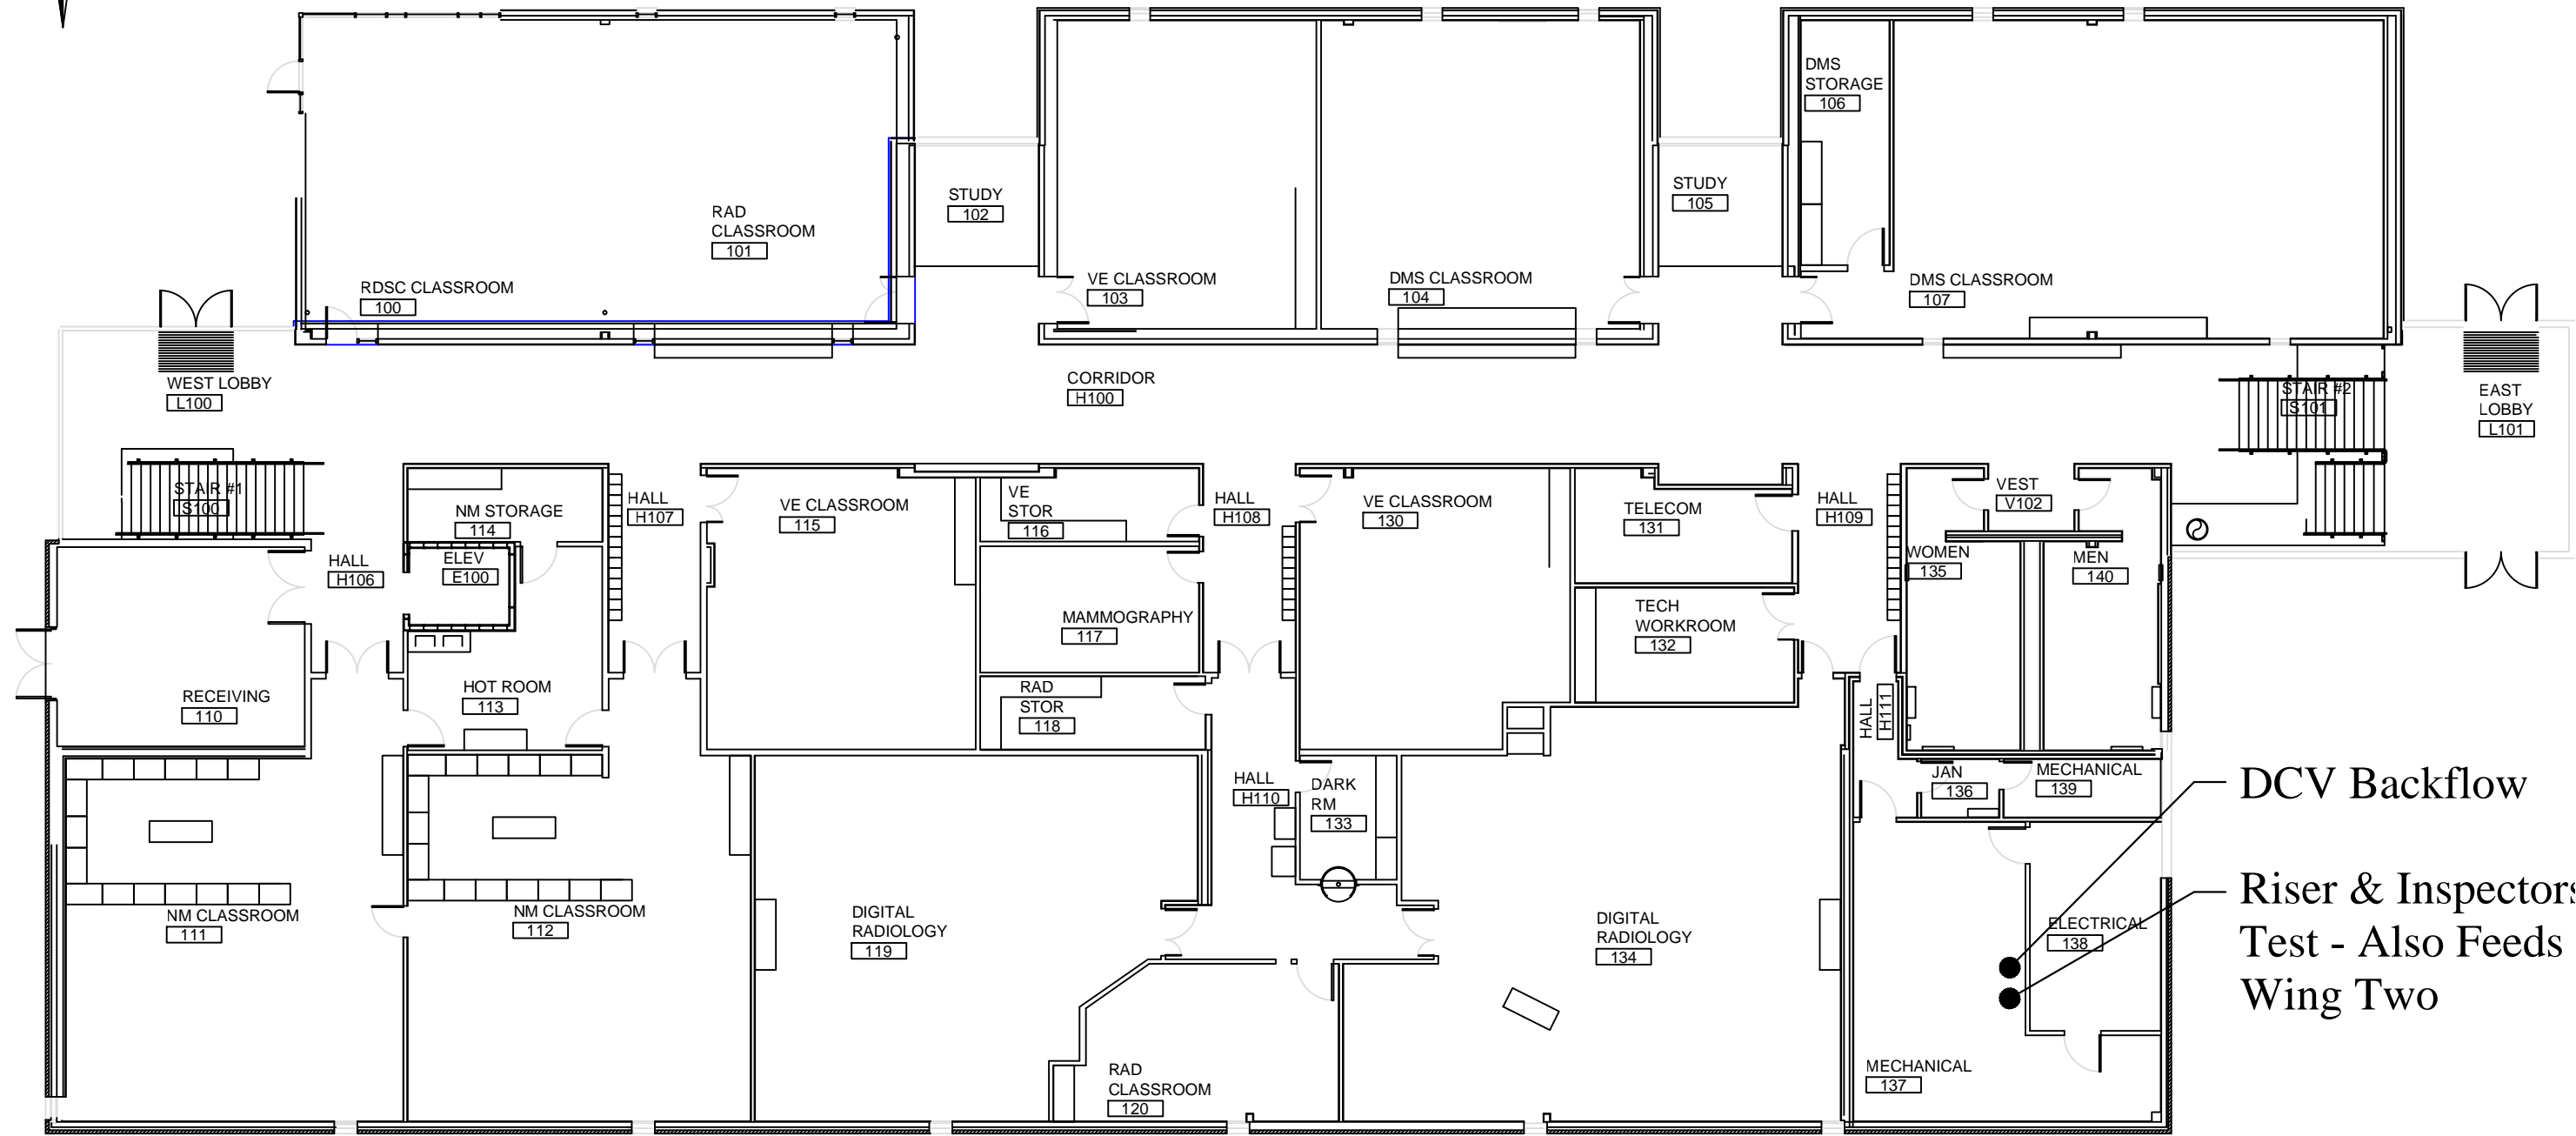


●● FDC

DCV Backflow
 Riser & Inspector Test - Also Feeds Wing Two

OREGON INSTITUTE OF TECHNOLOGY
Center for Health Professions - Wing One - 1st Floor



Path: (T:)_Facilities_Campus...Floor...
 Prepared by: Dustin Huddleston



Scale: 1/16" = 1'- 0"
 Date: 11/1/2013

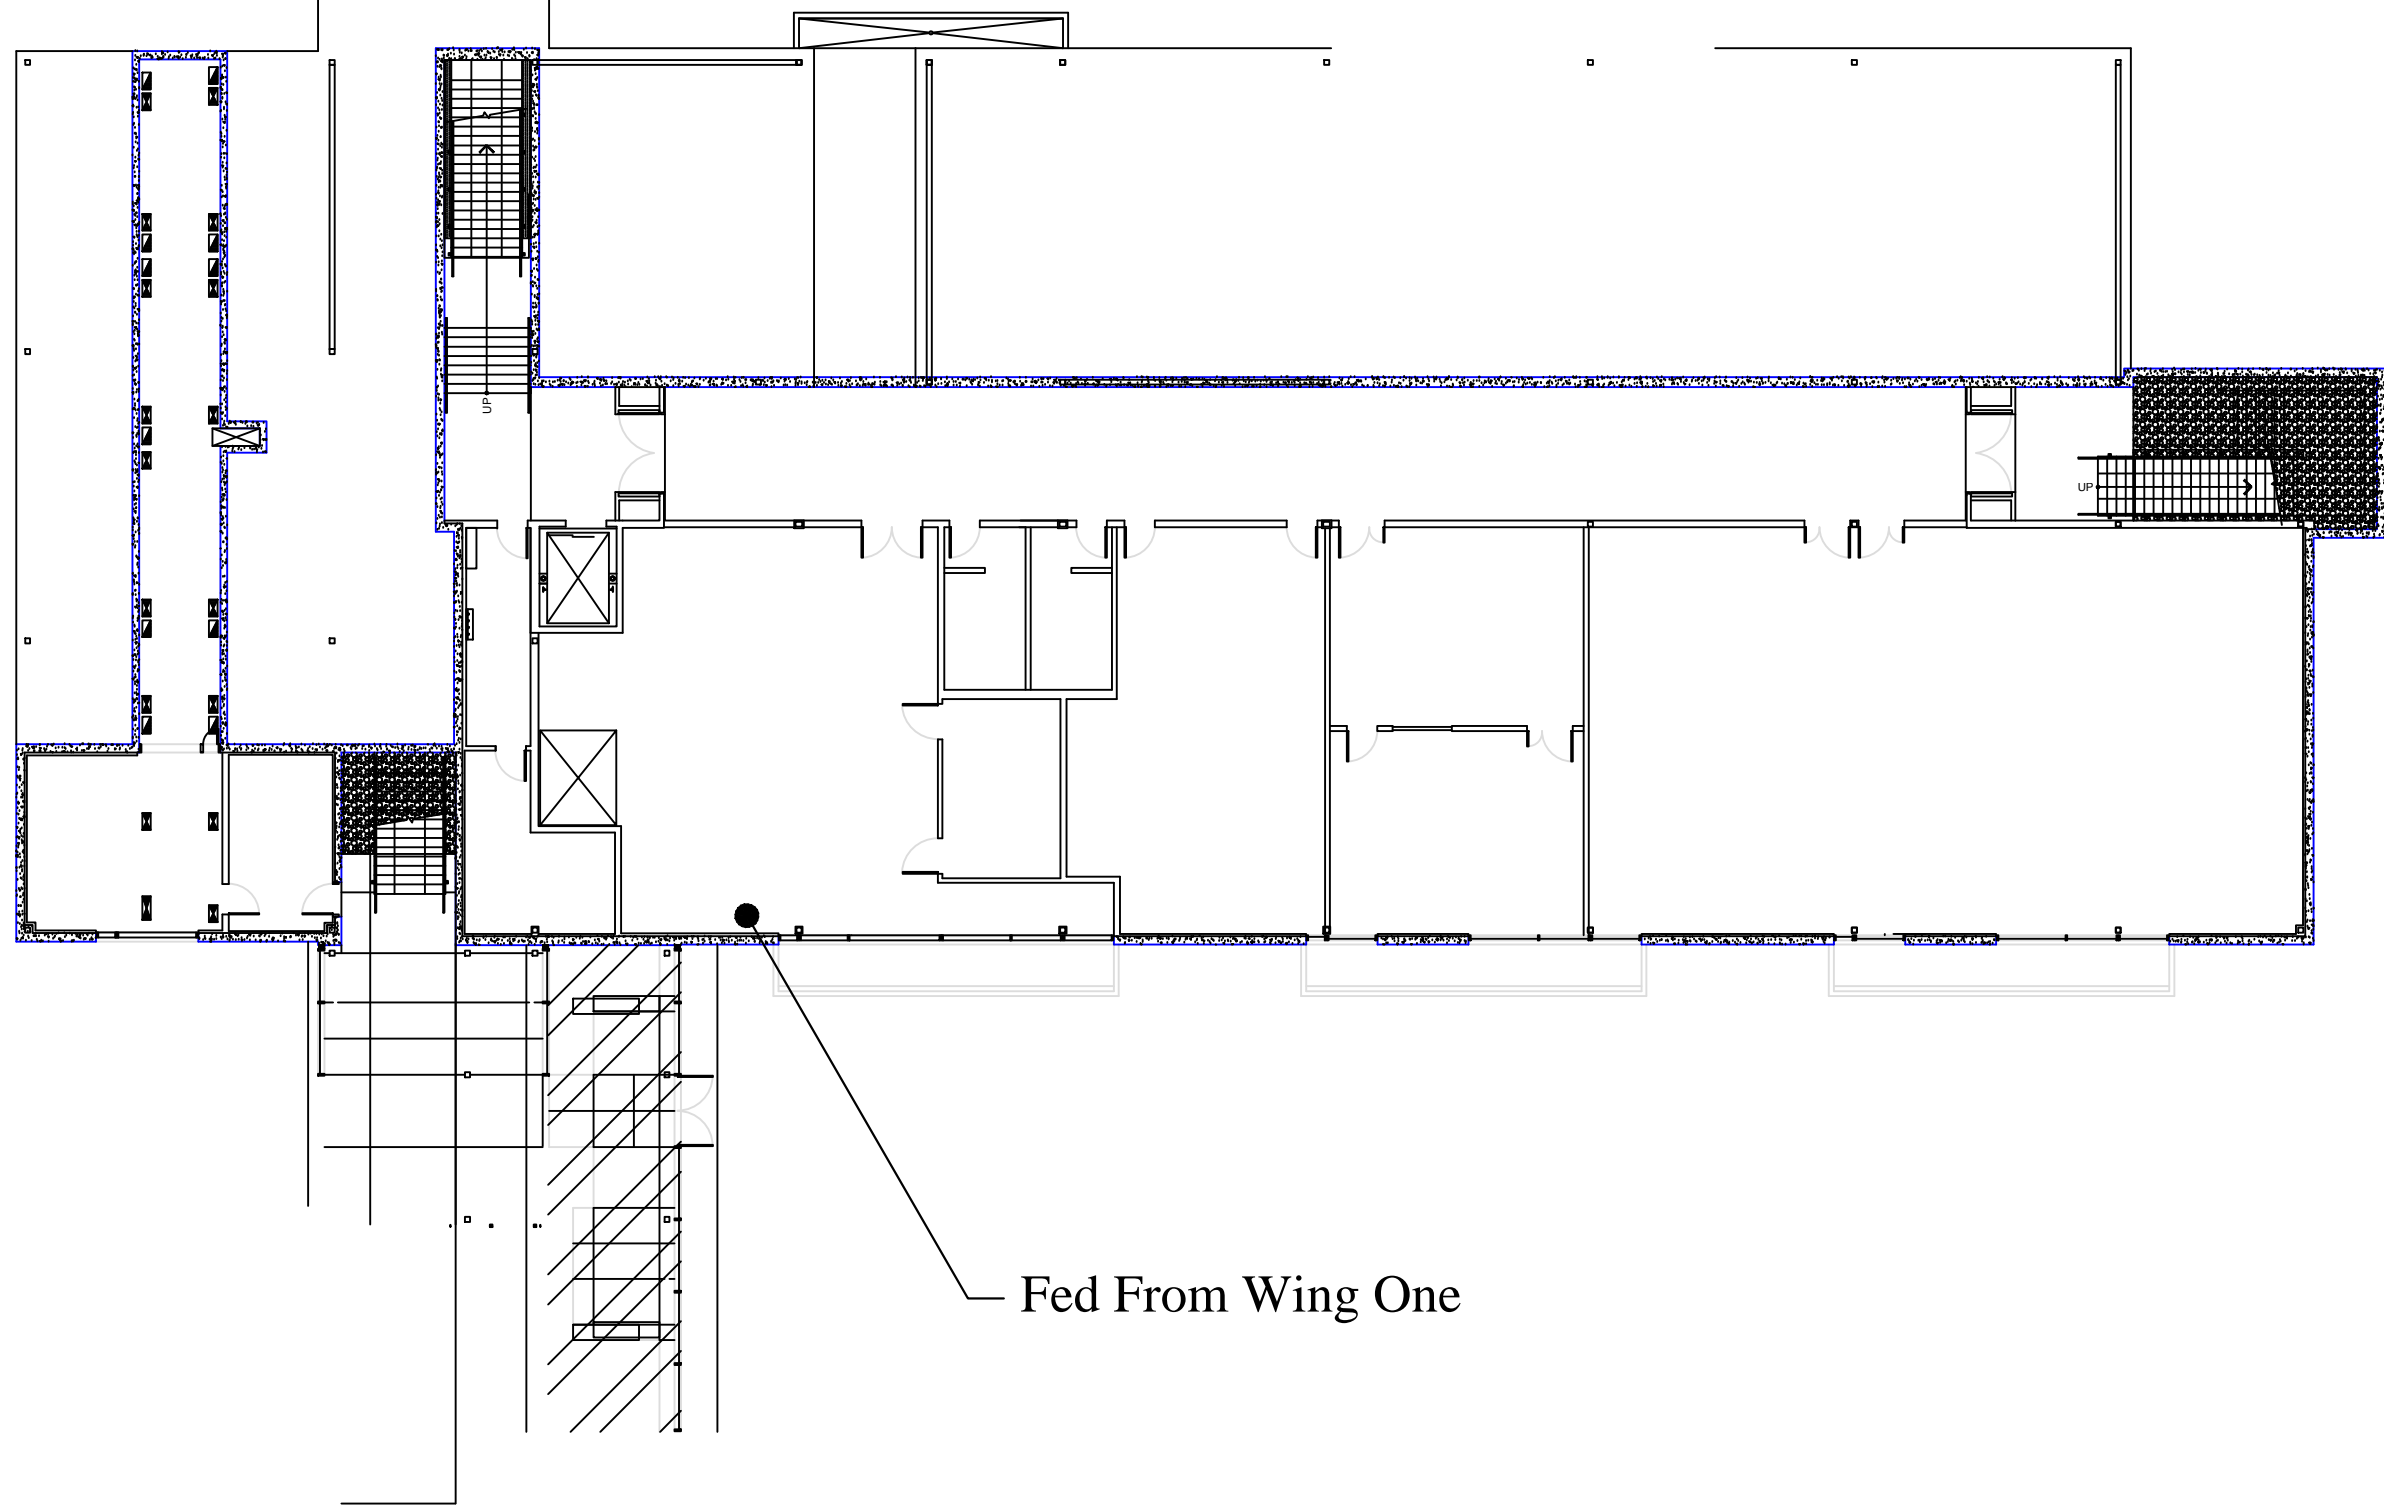


Fed From Wing One



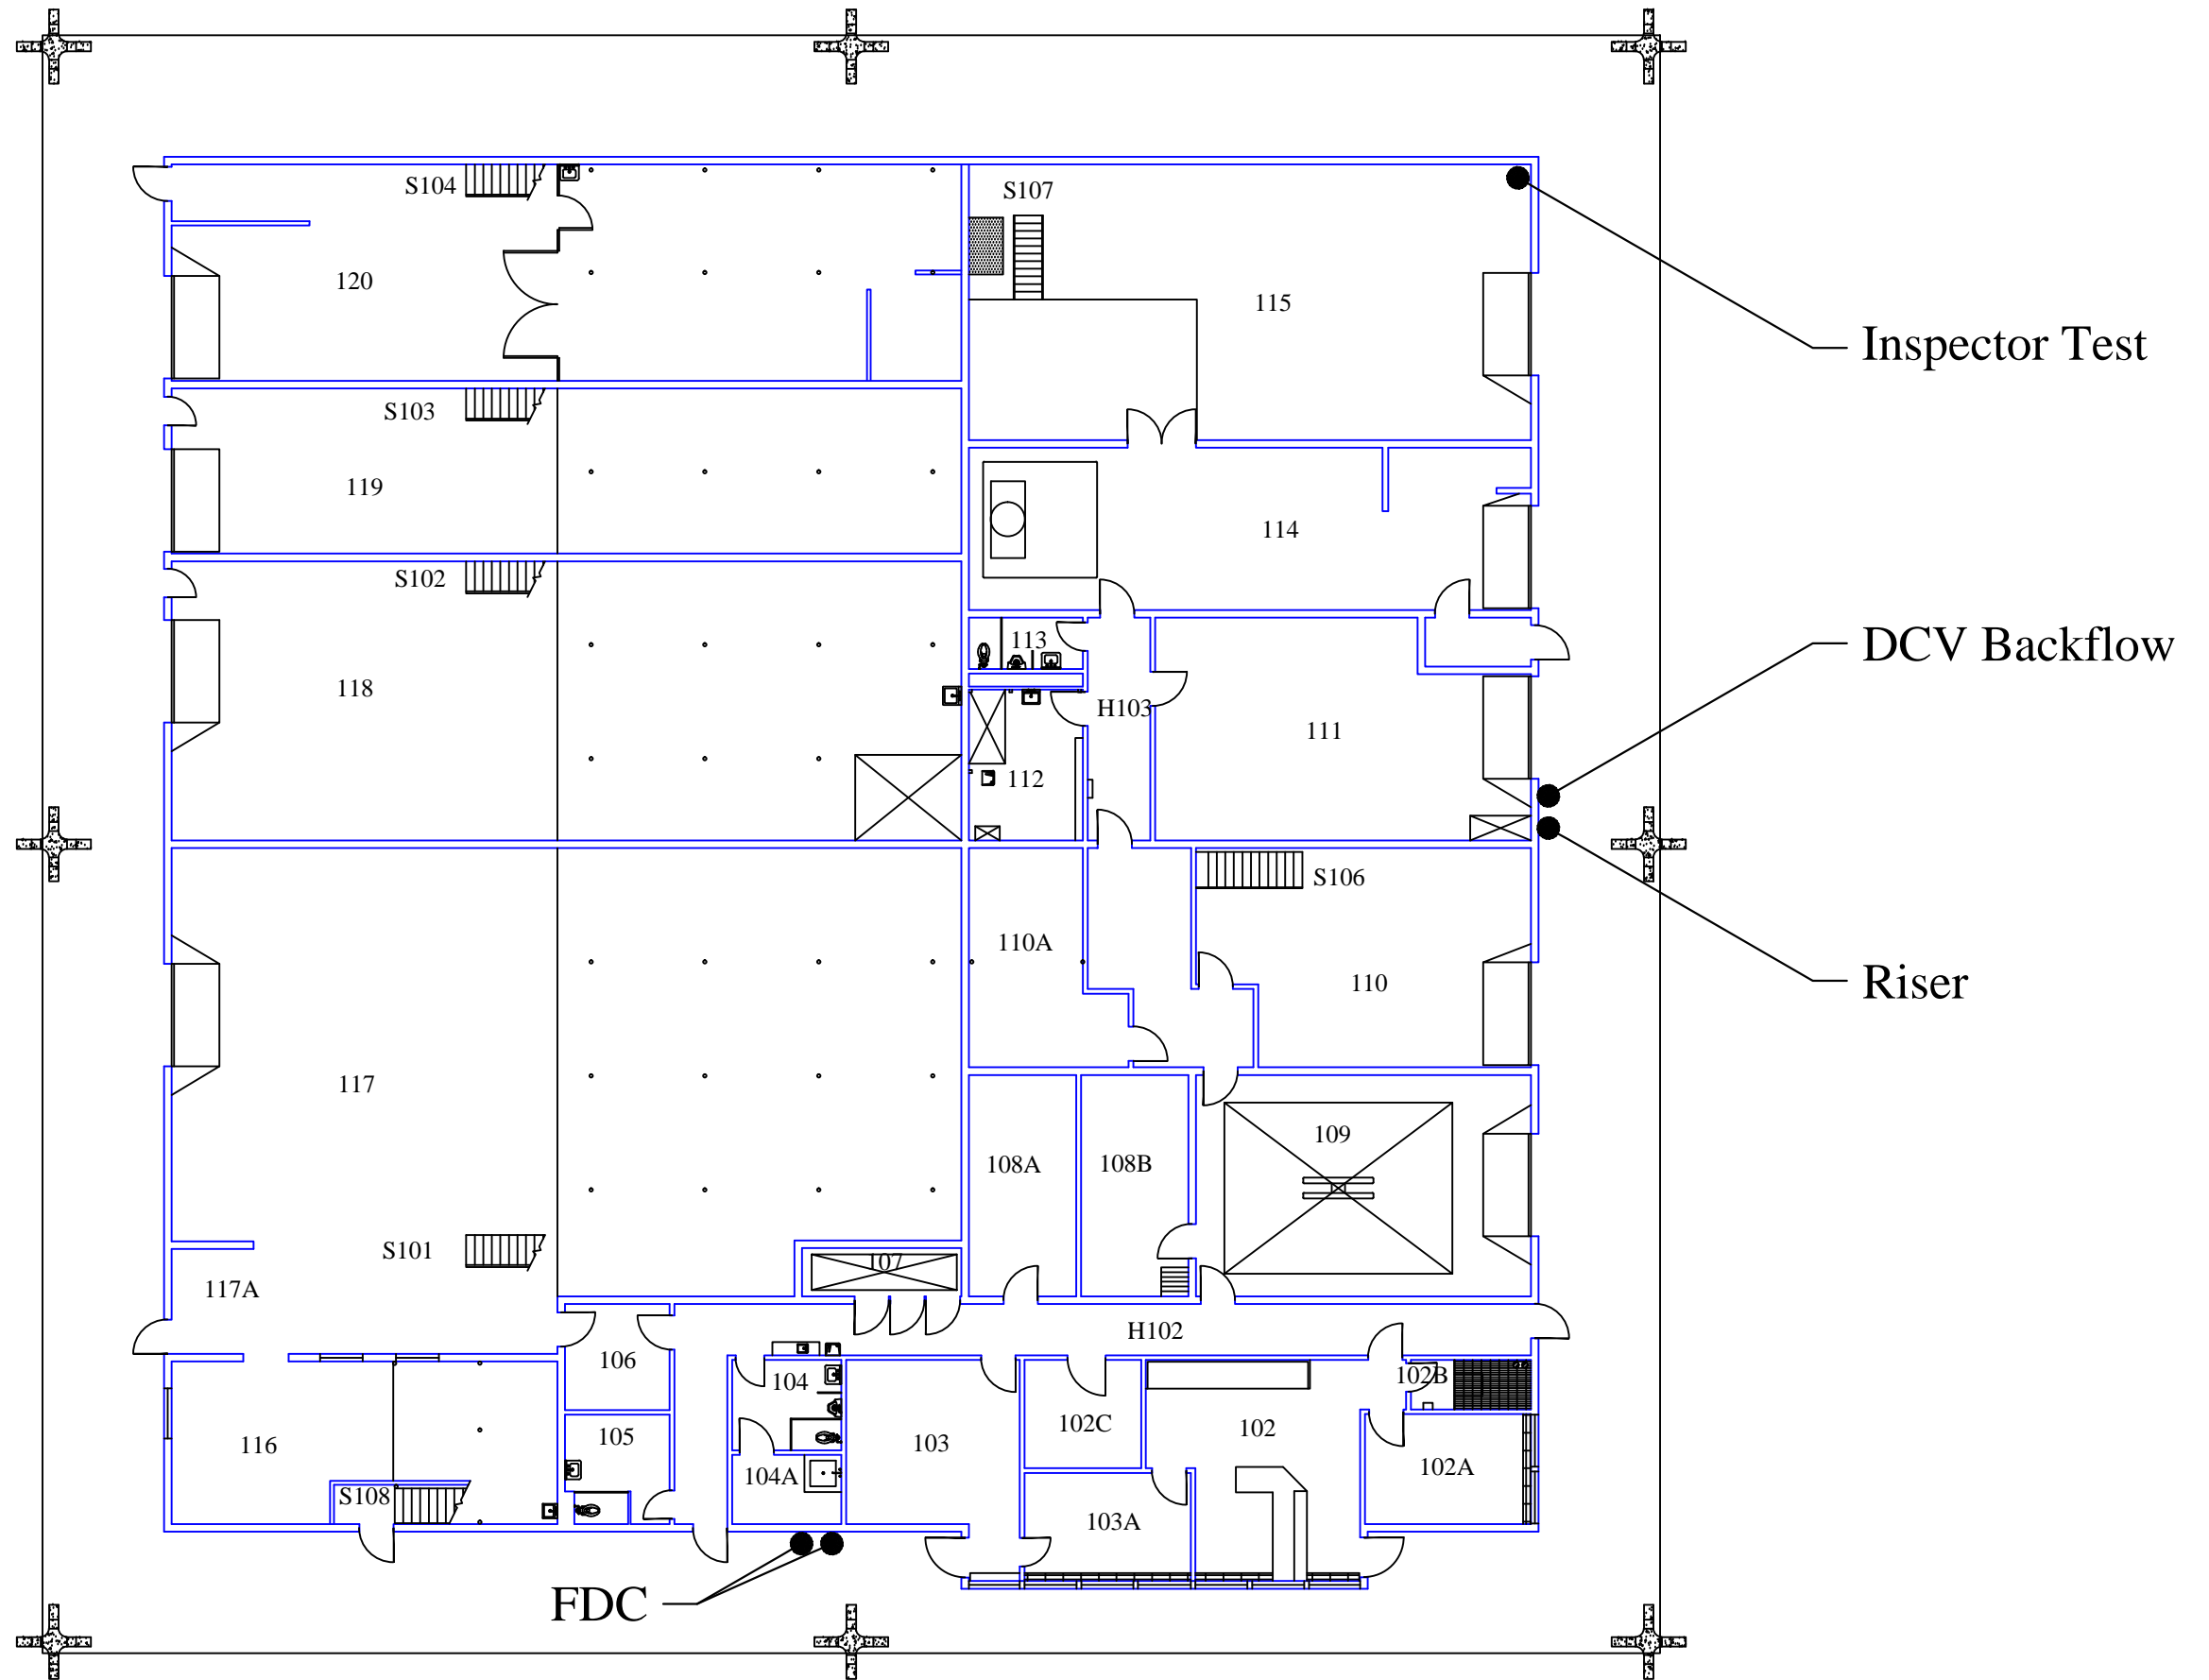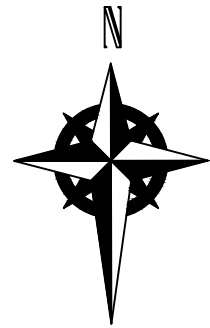

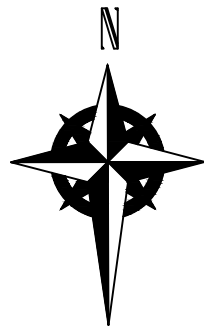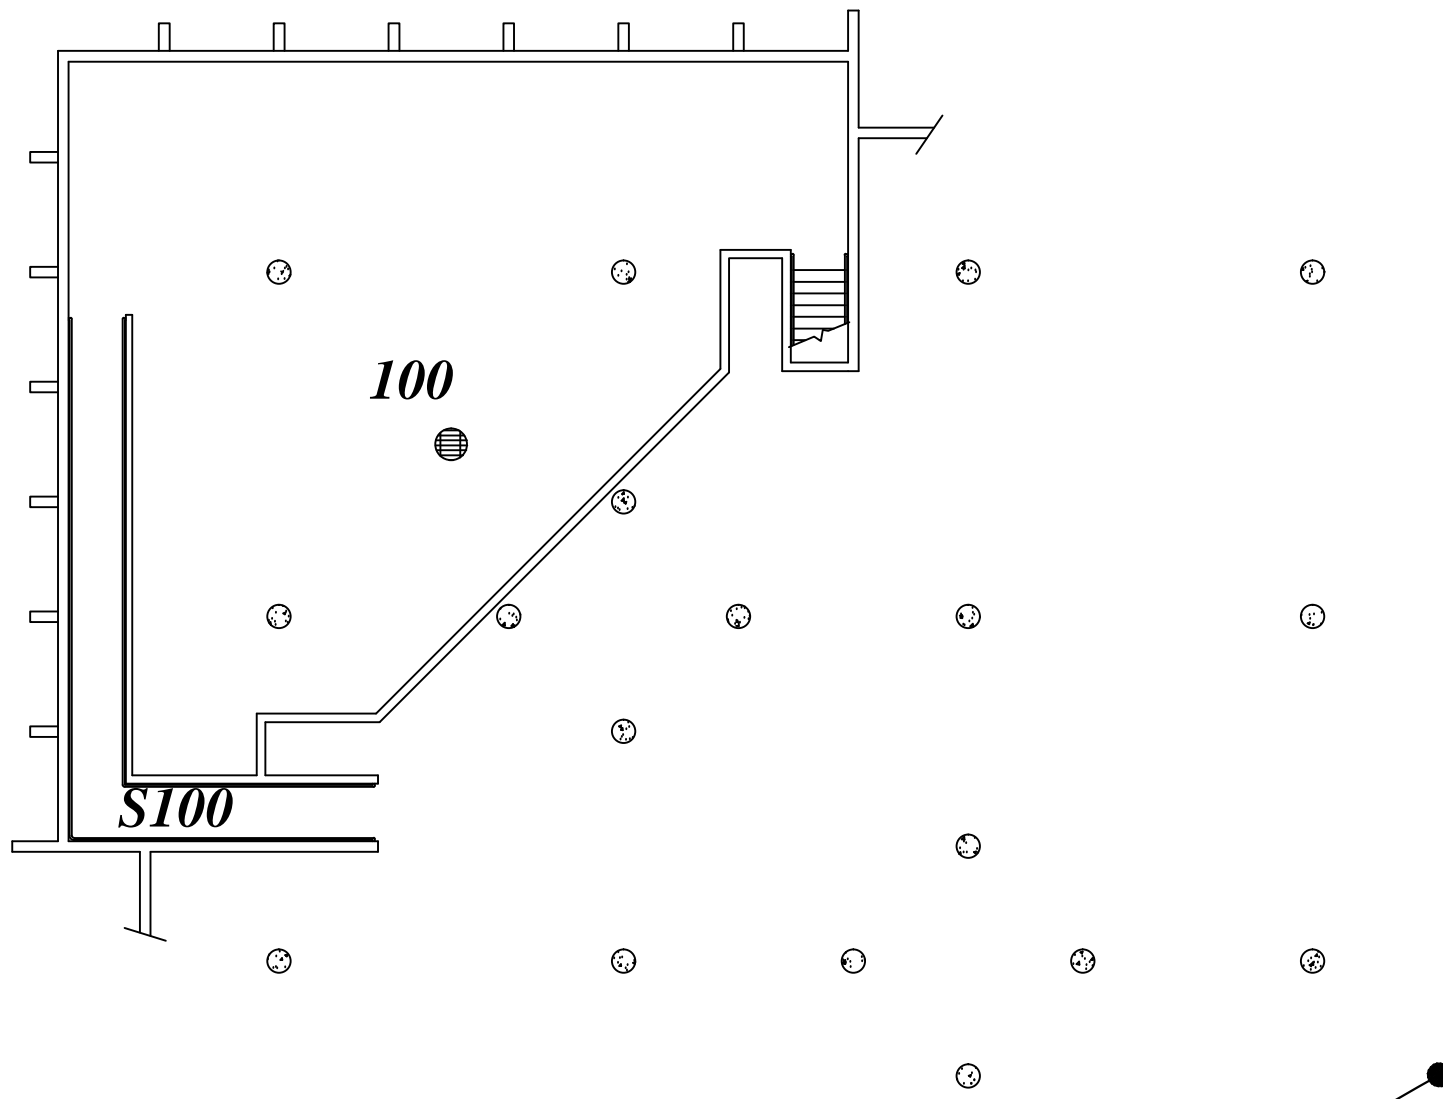



Inspector Test —●

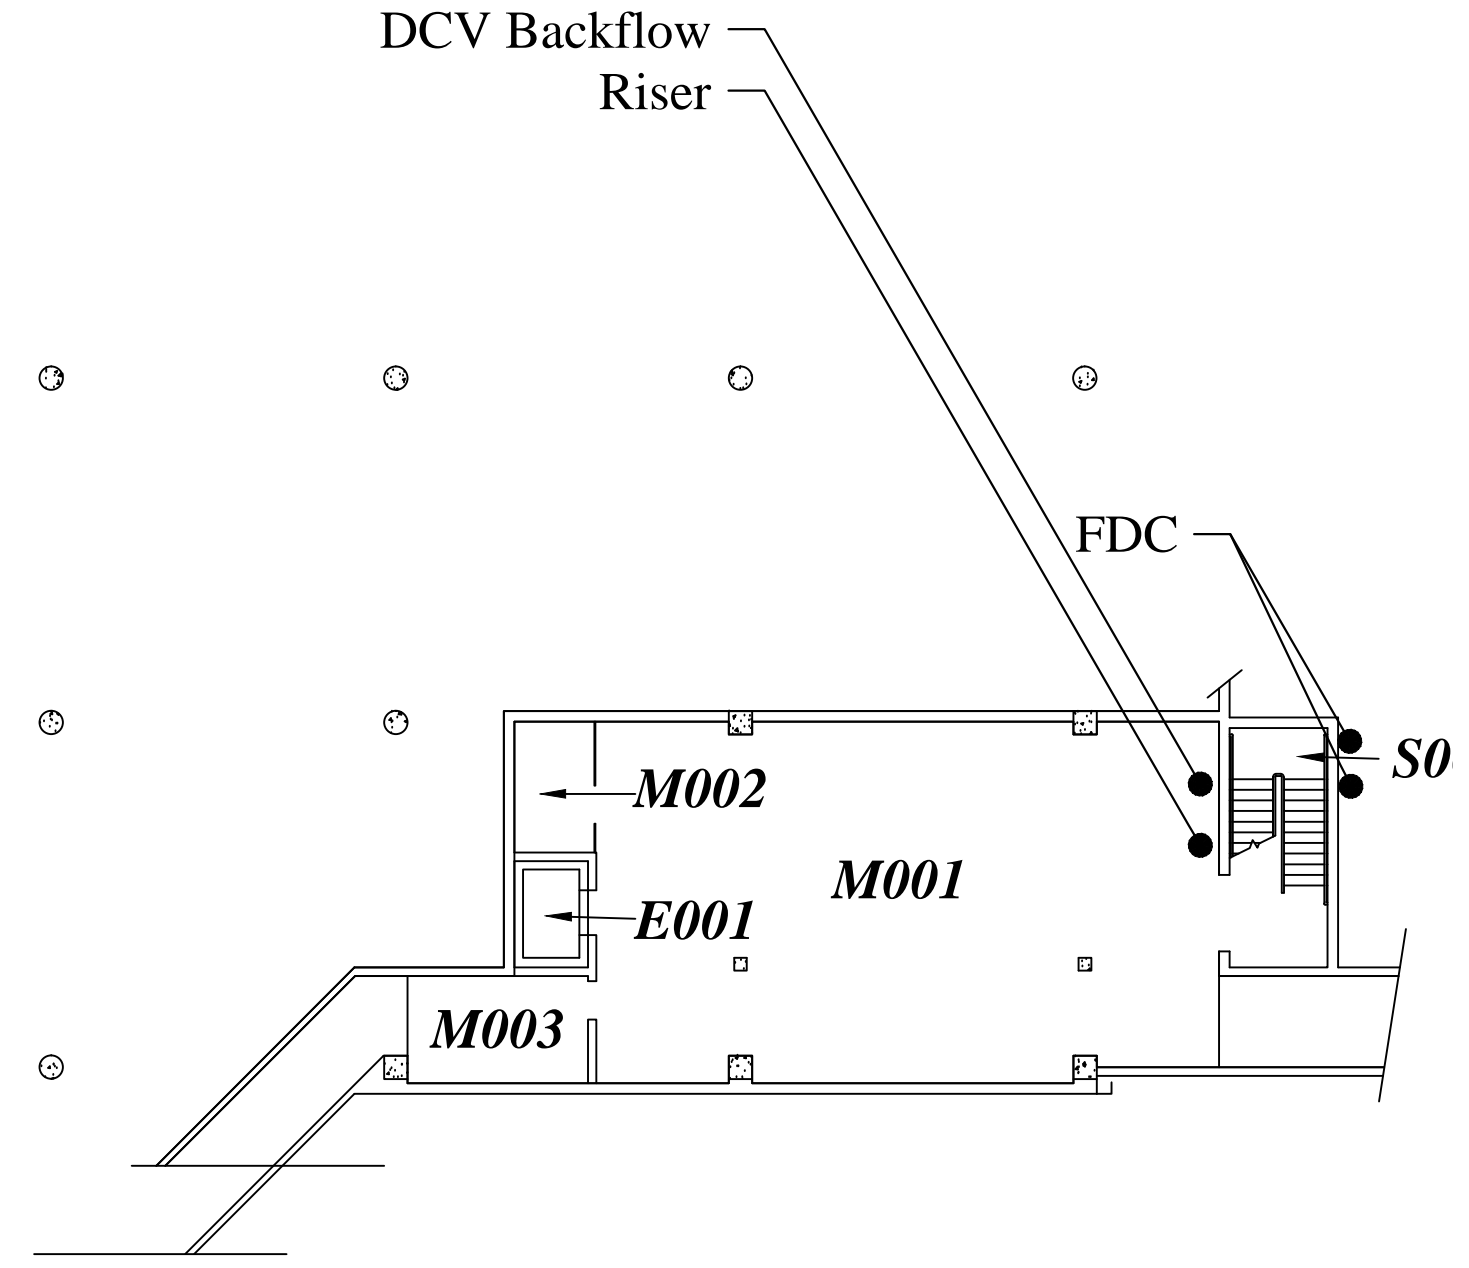

FDC

DCV Backflow

Riser & Inspector Test

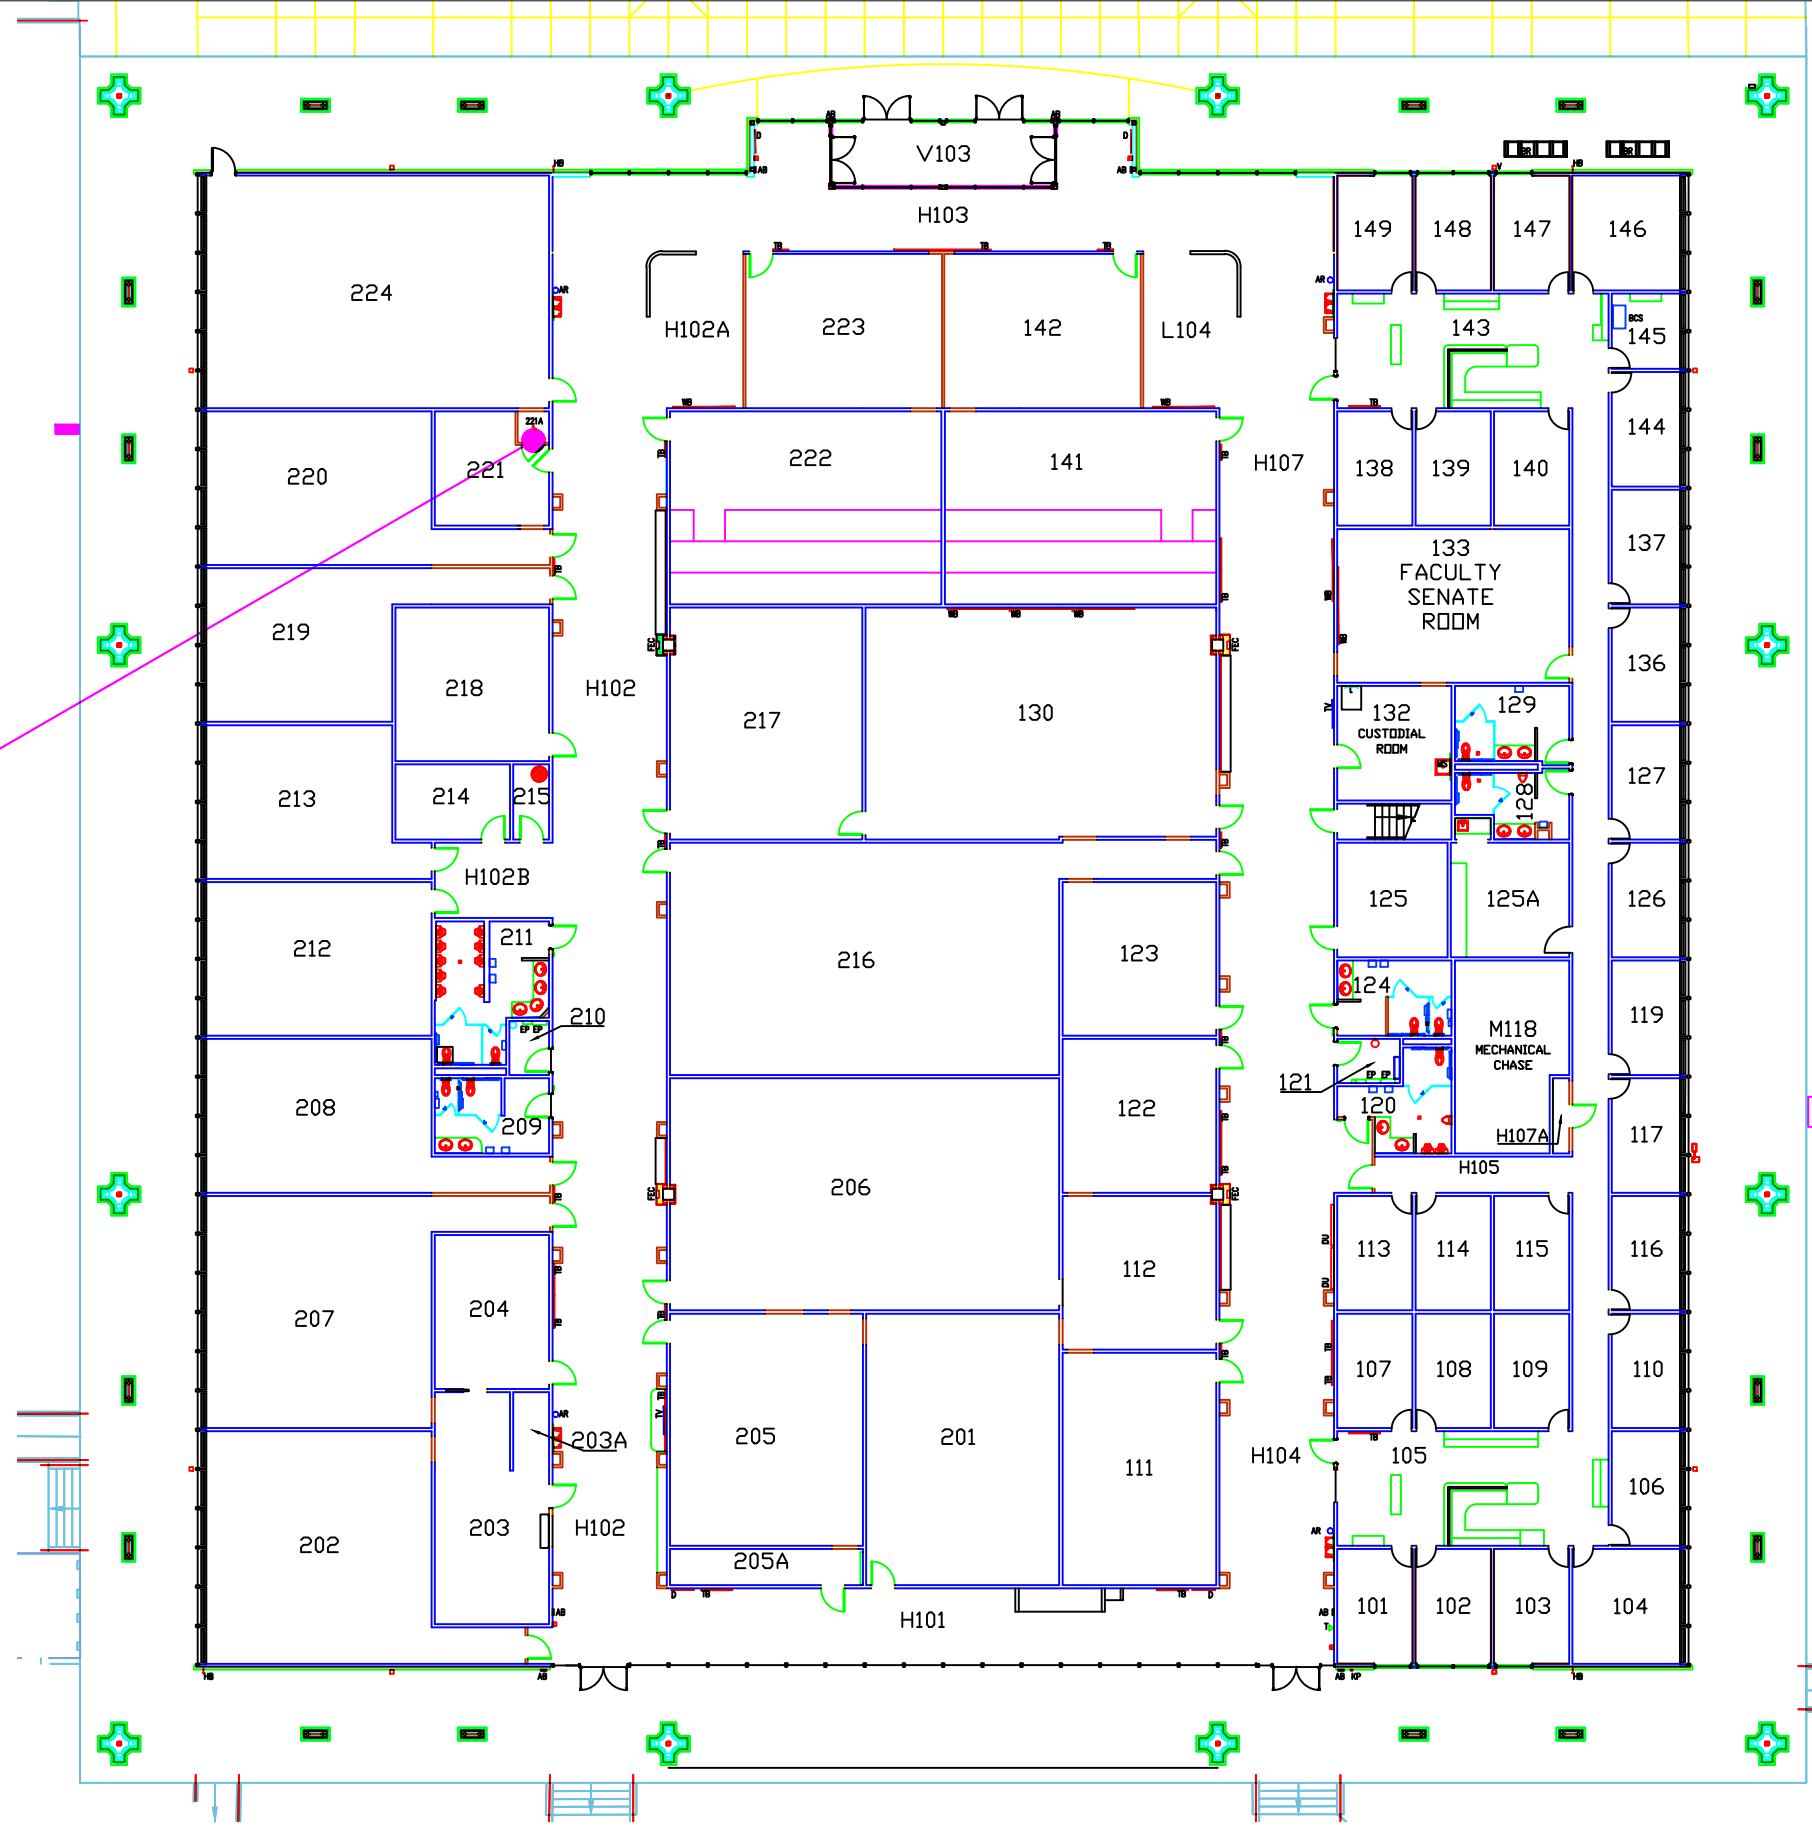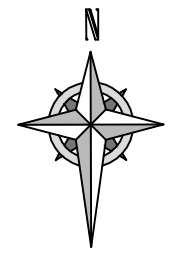

OREGON INSTITUTE OF TECHNOLOGY
Owens Hall Floor Plan

Path: (T:)_Facilities_Campus...Floor...
 Prepared by: Dustin Huddleston


Scale: NTS
 Date: 11/1/2013




DCV Backflow

Riser

Inspector Test

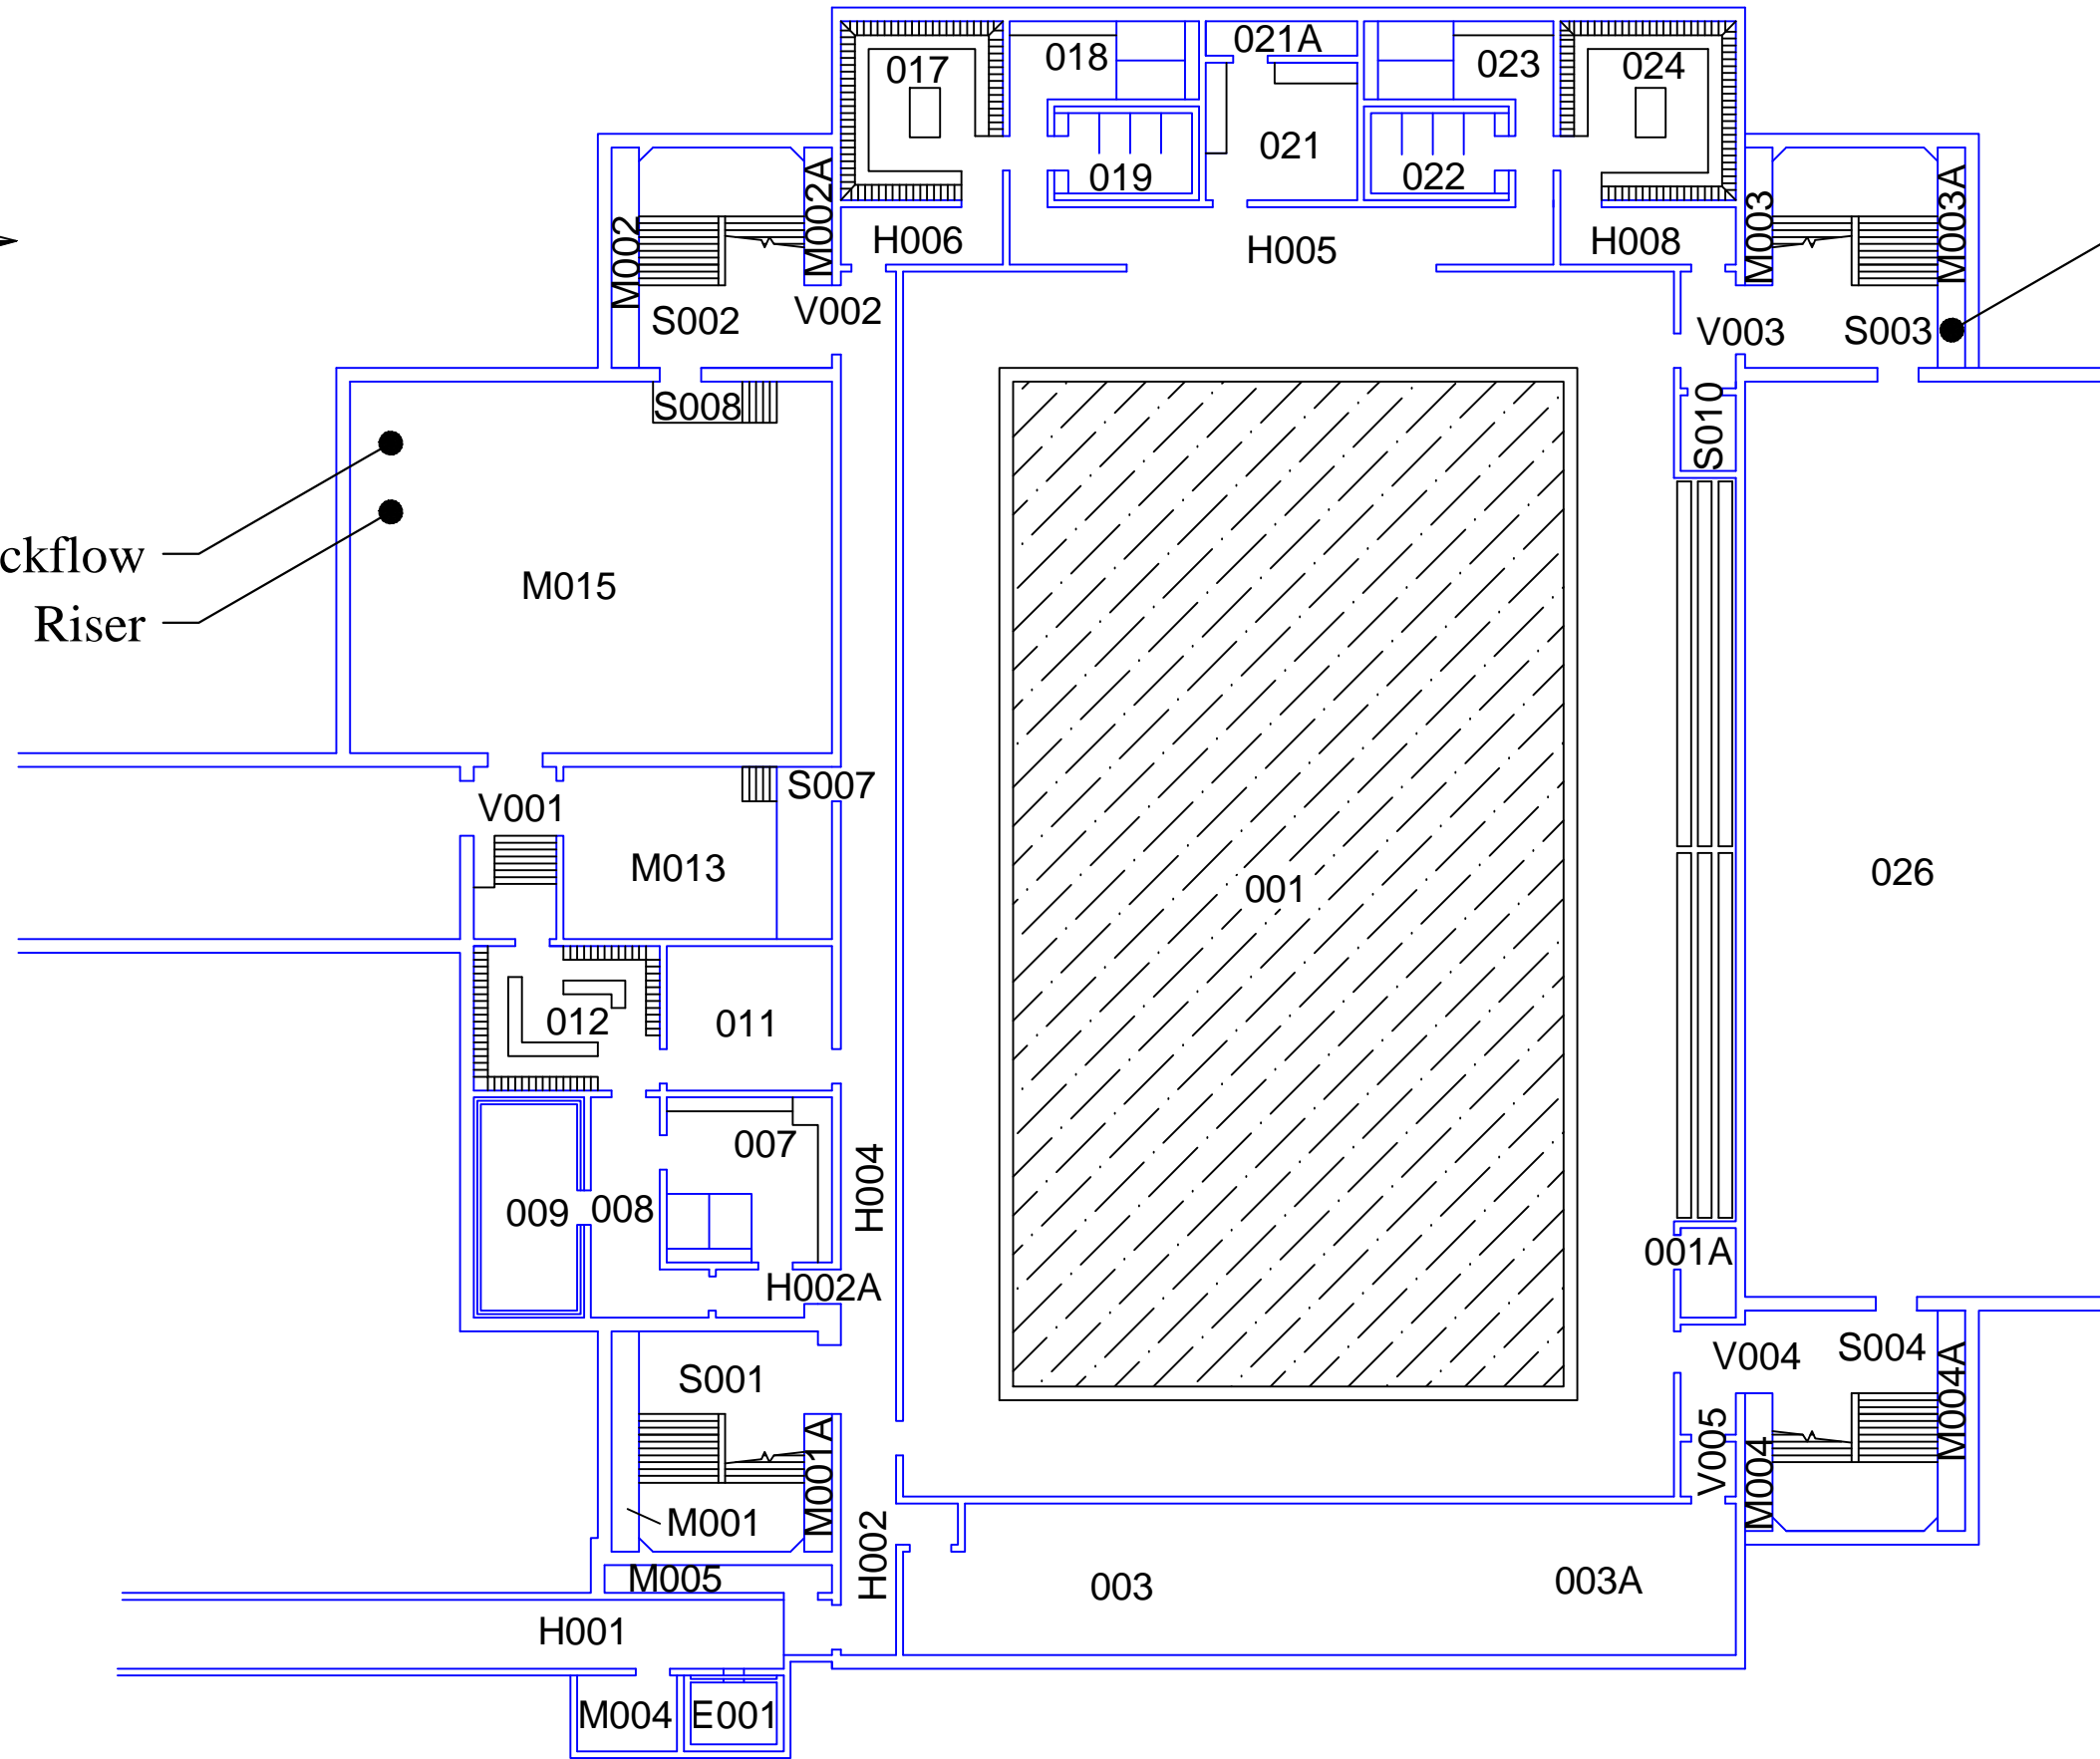

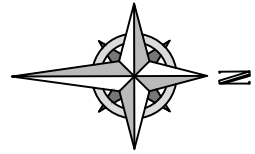

11 Dry Pendent Heads


5 Dry Pendent Sprinkler Heads


Inspector Test 1st

Riser FDC


DCV Backflow

Flow Switches 1st & 2nd Floor

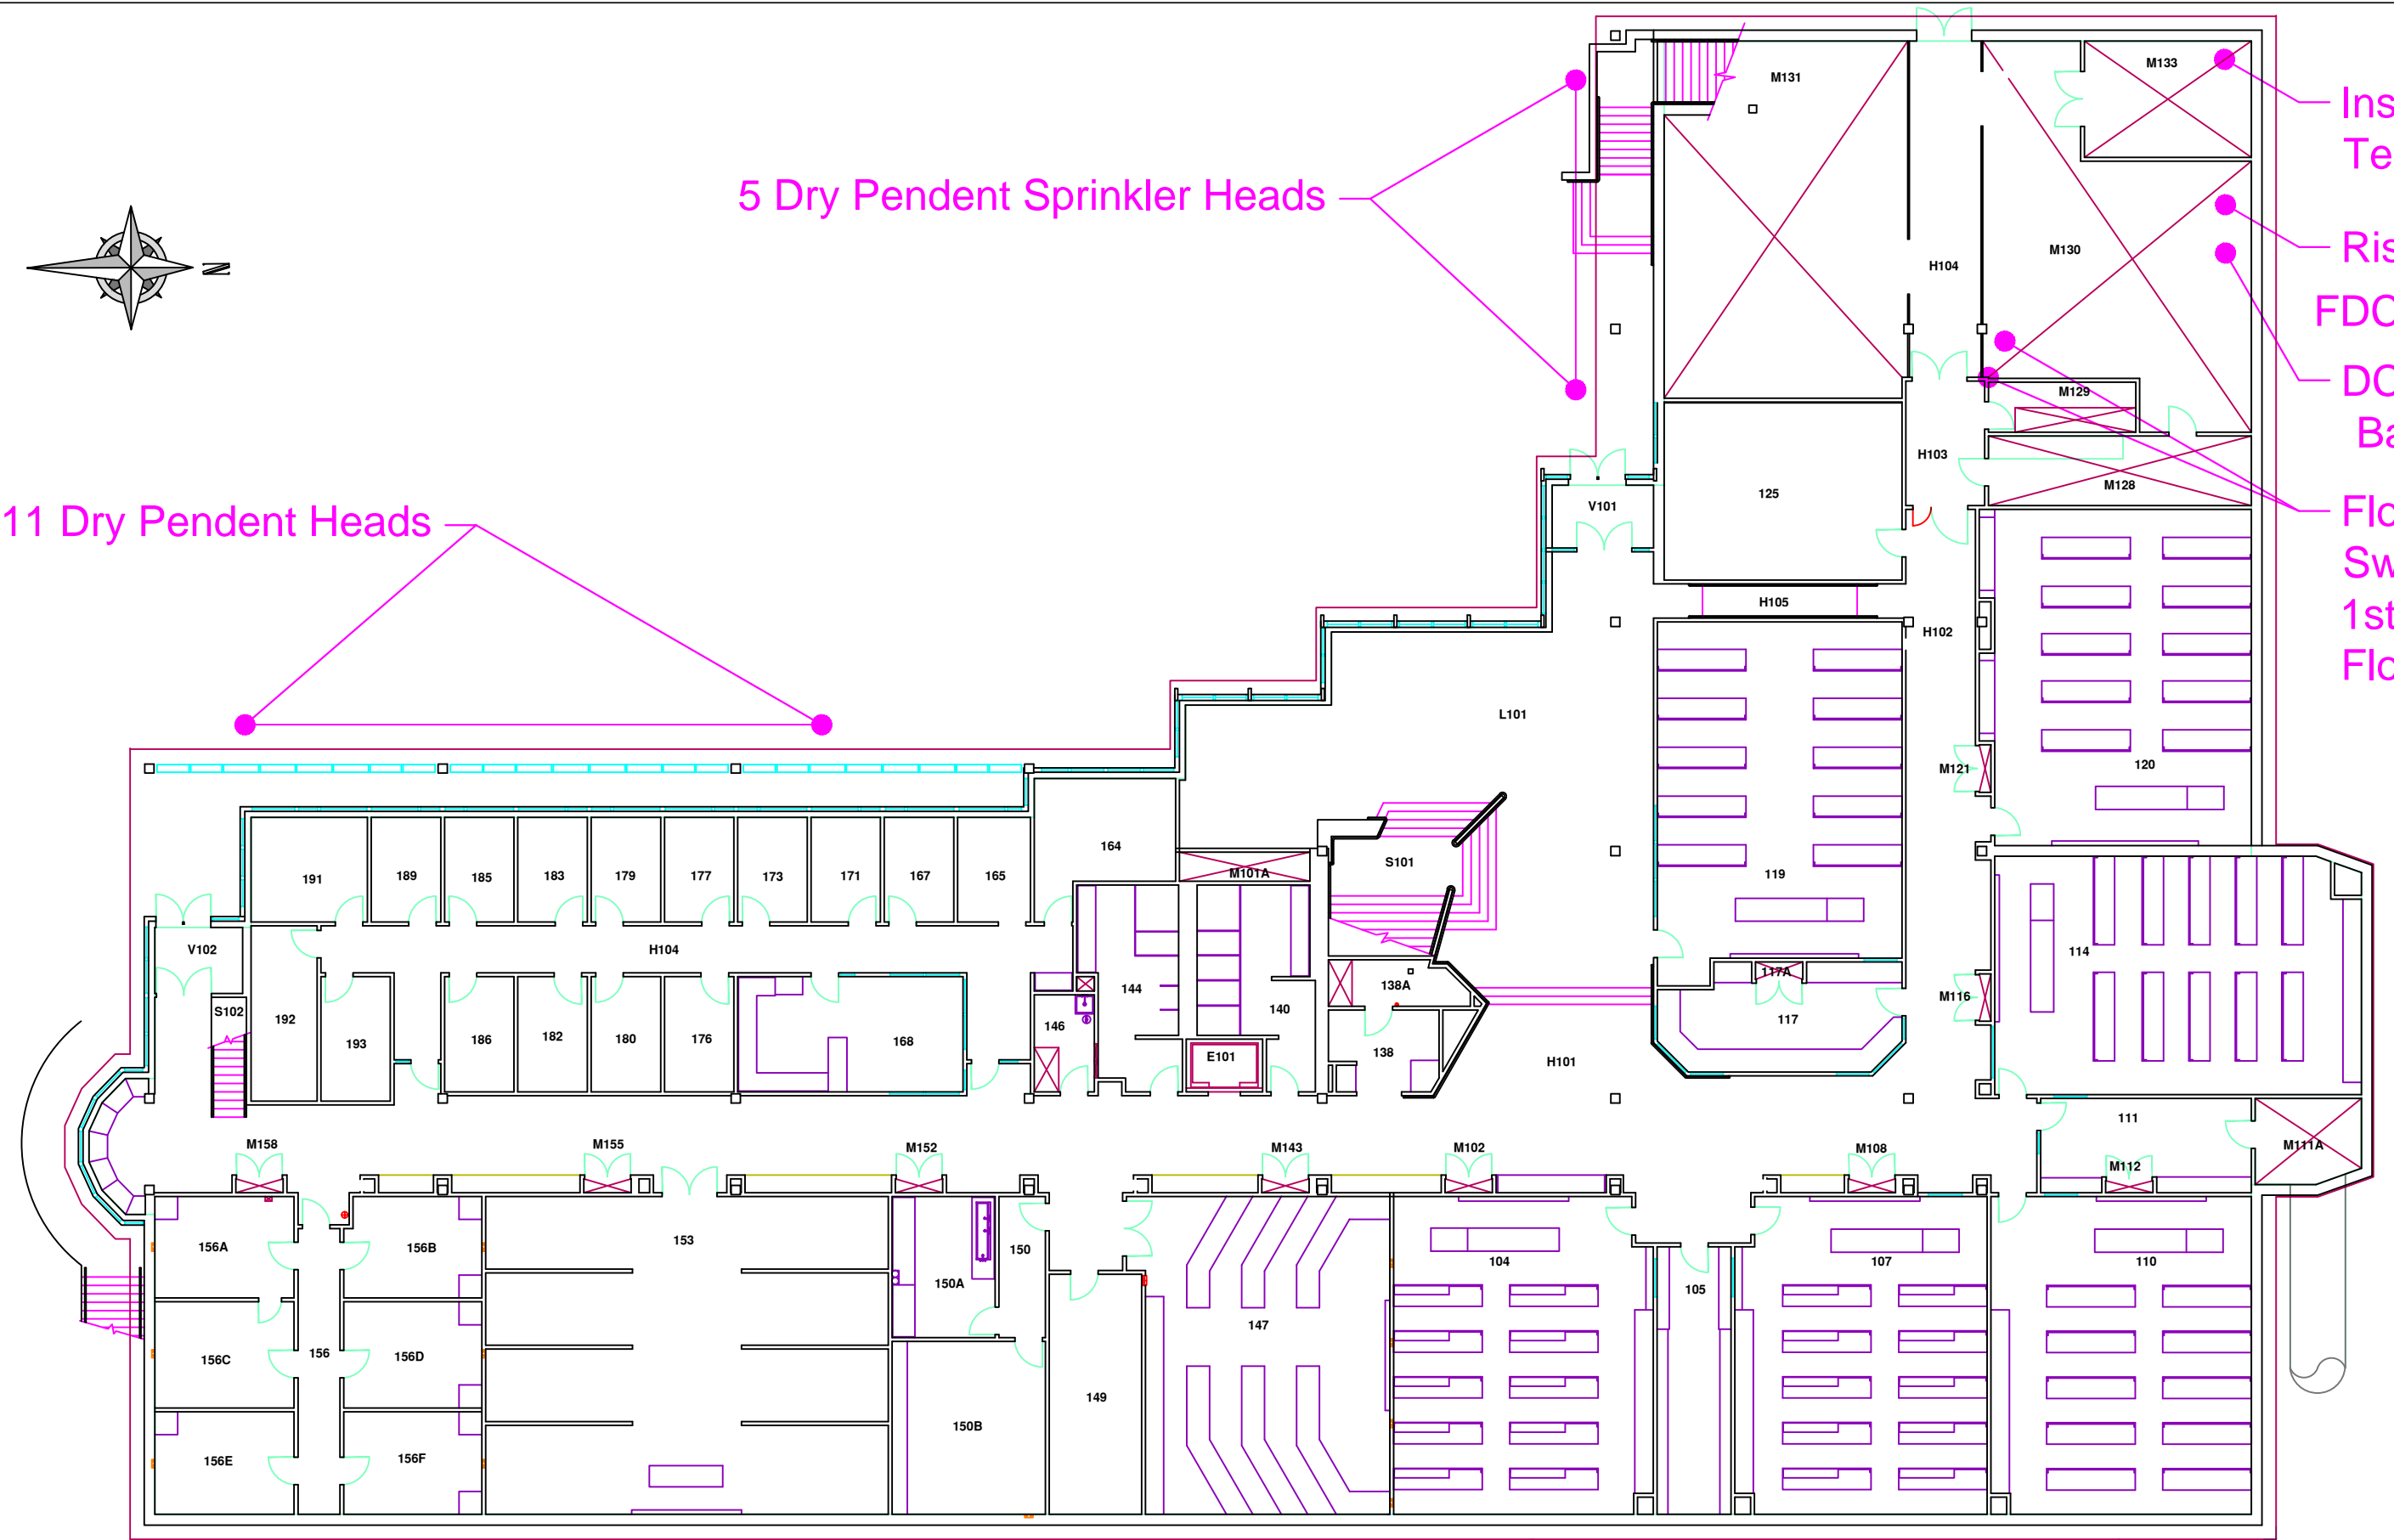

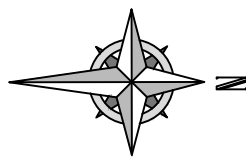



*Drain 2nd Floor
Inspector Test Up Stairs*

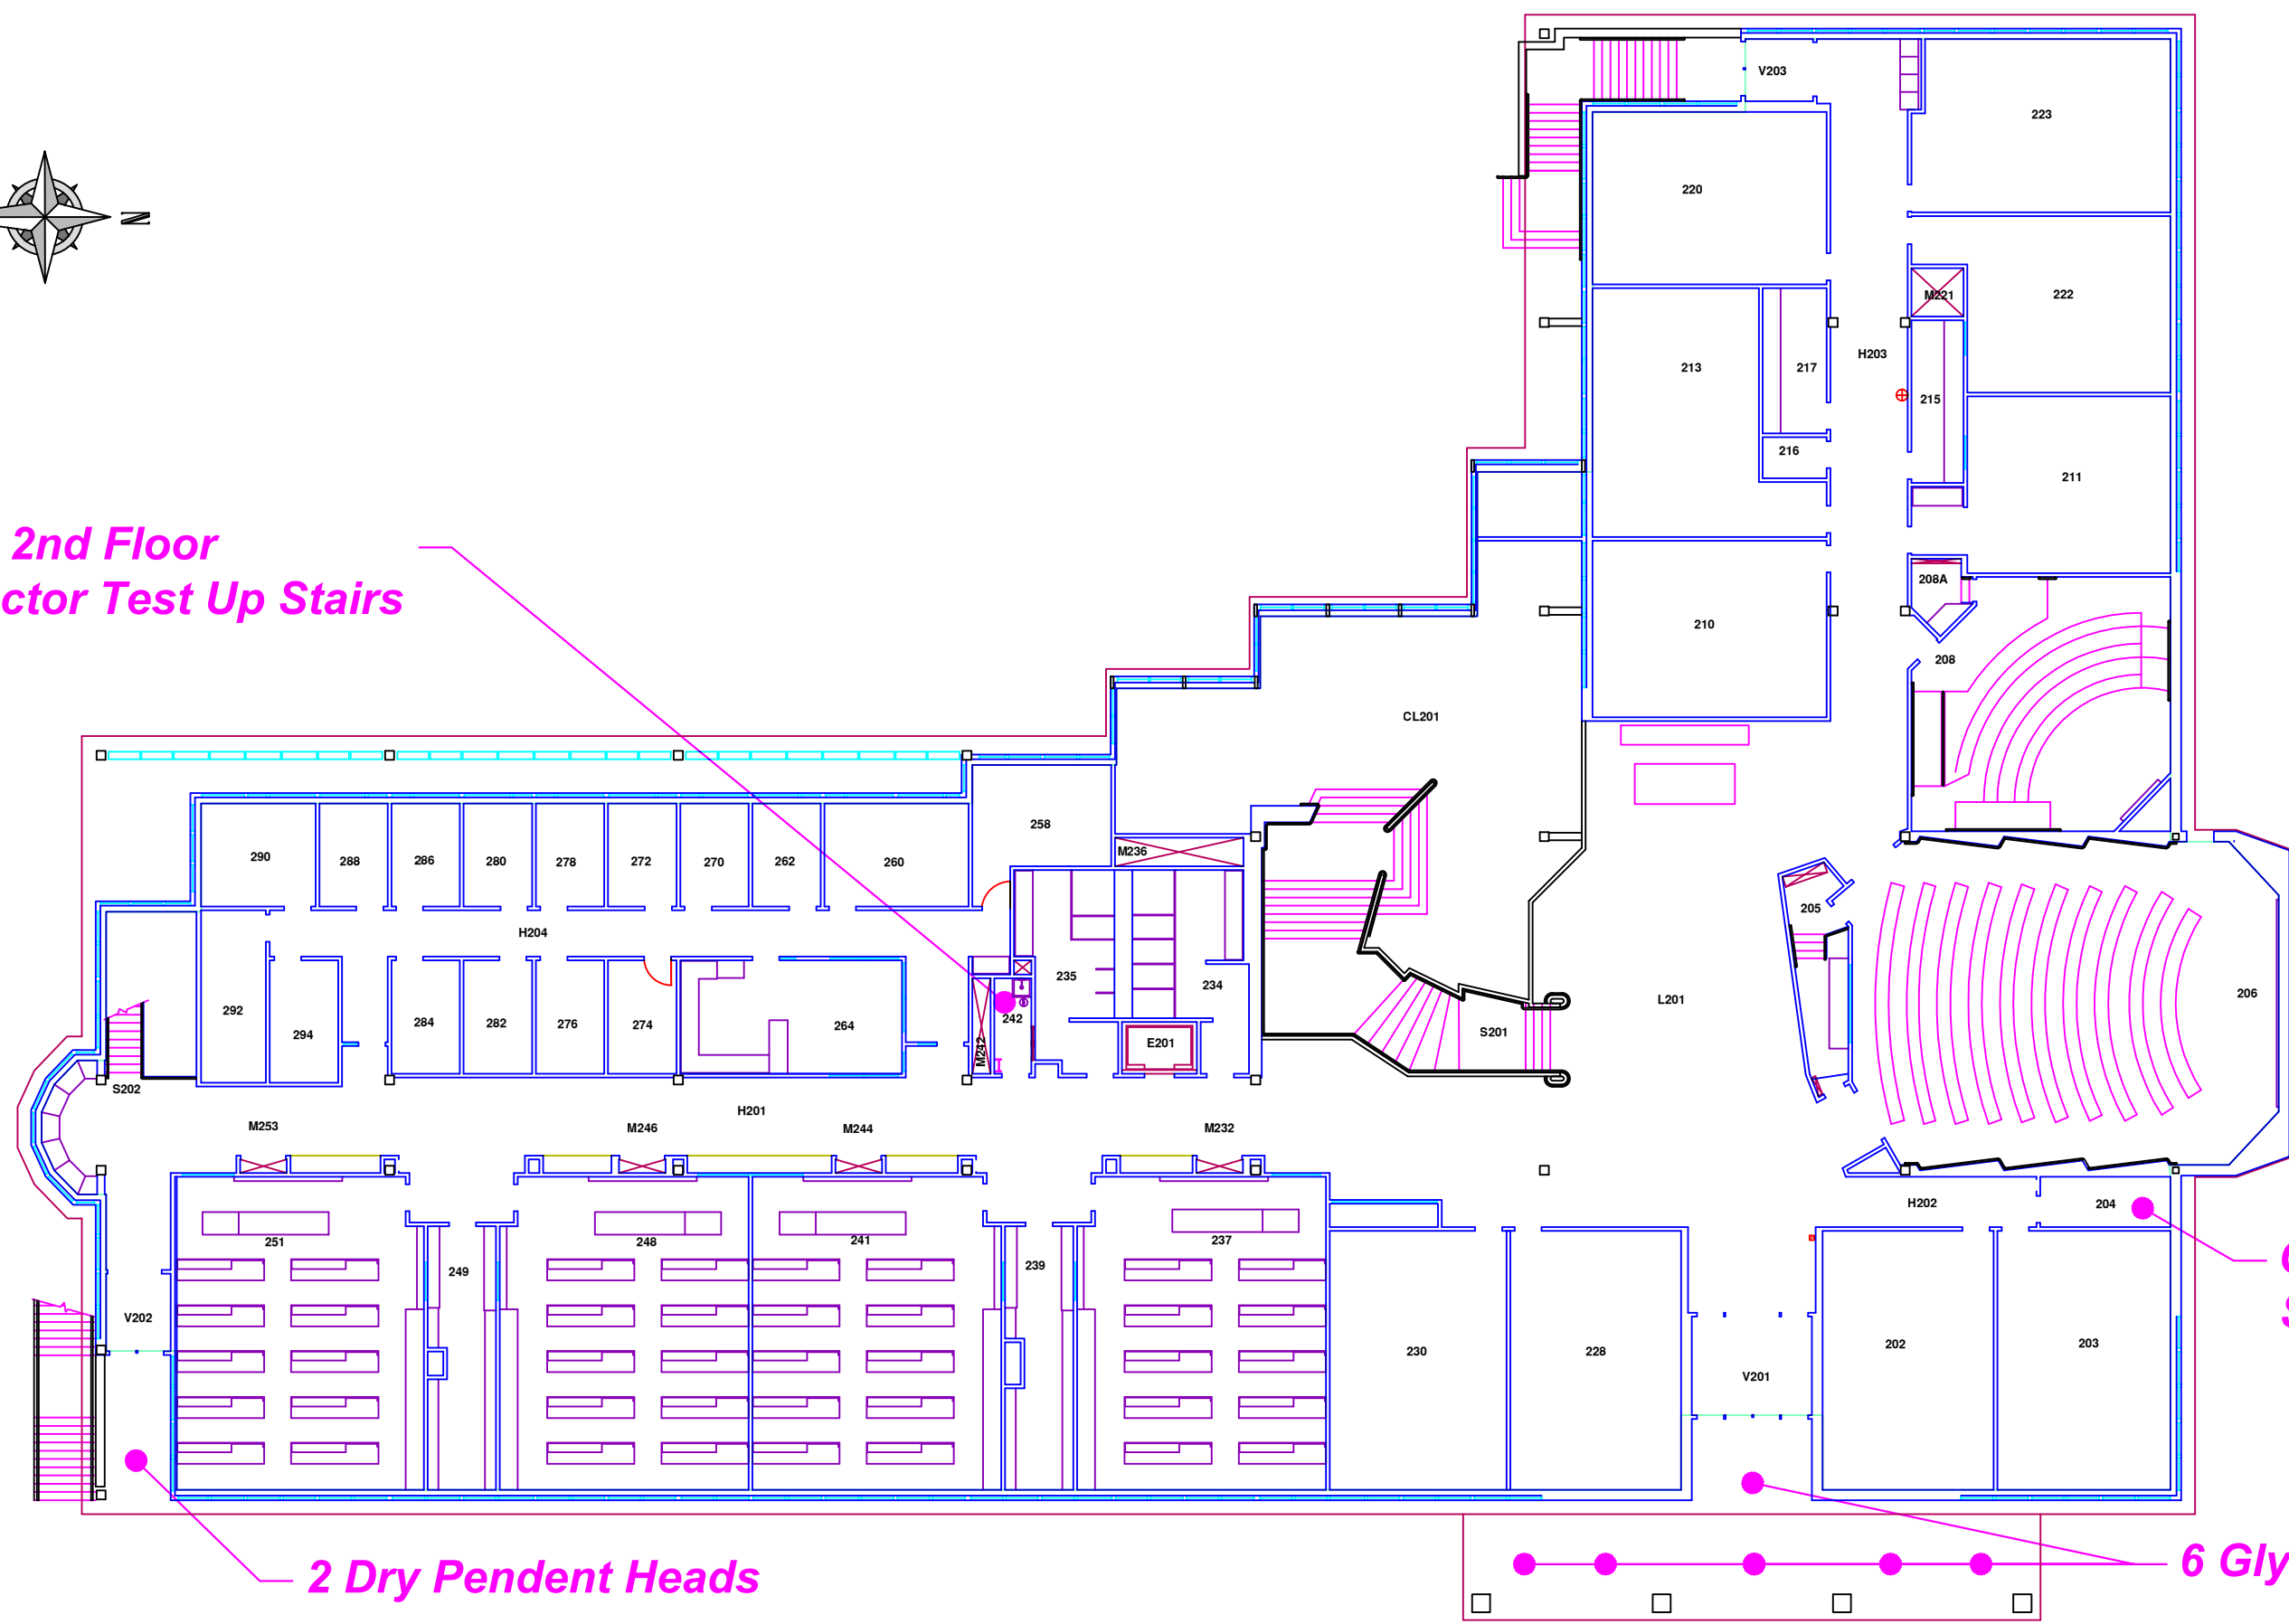

*Gly. Contr
System*

2 Dry Pendent Heads


6 Glycol Heads

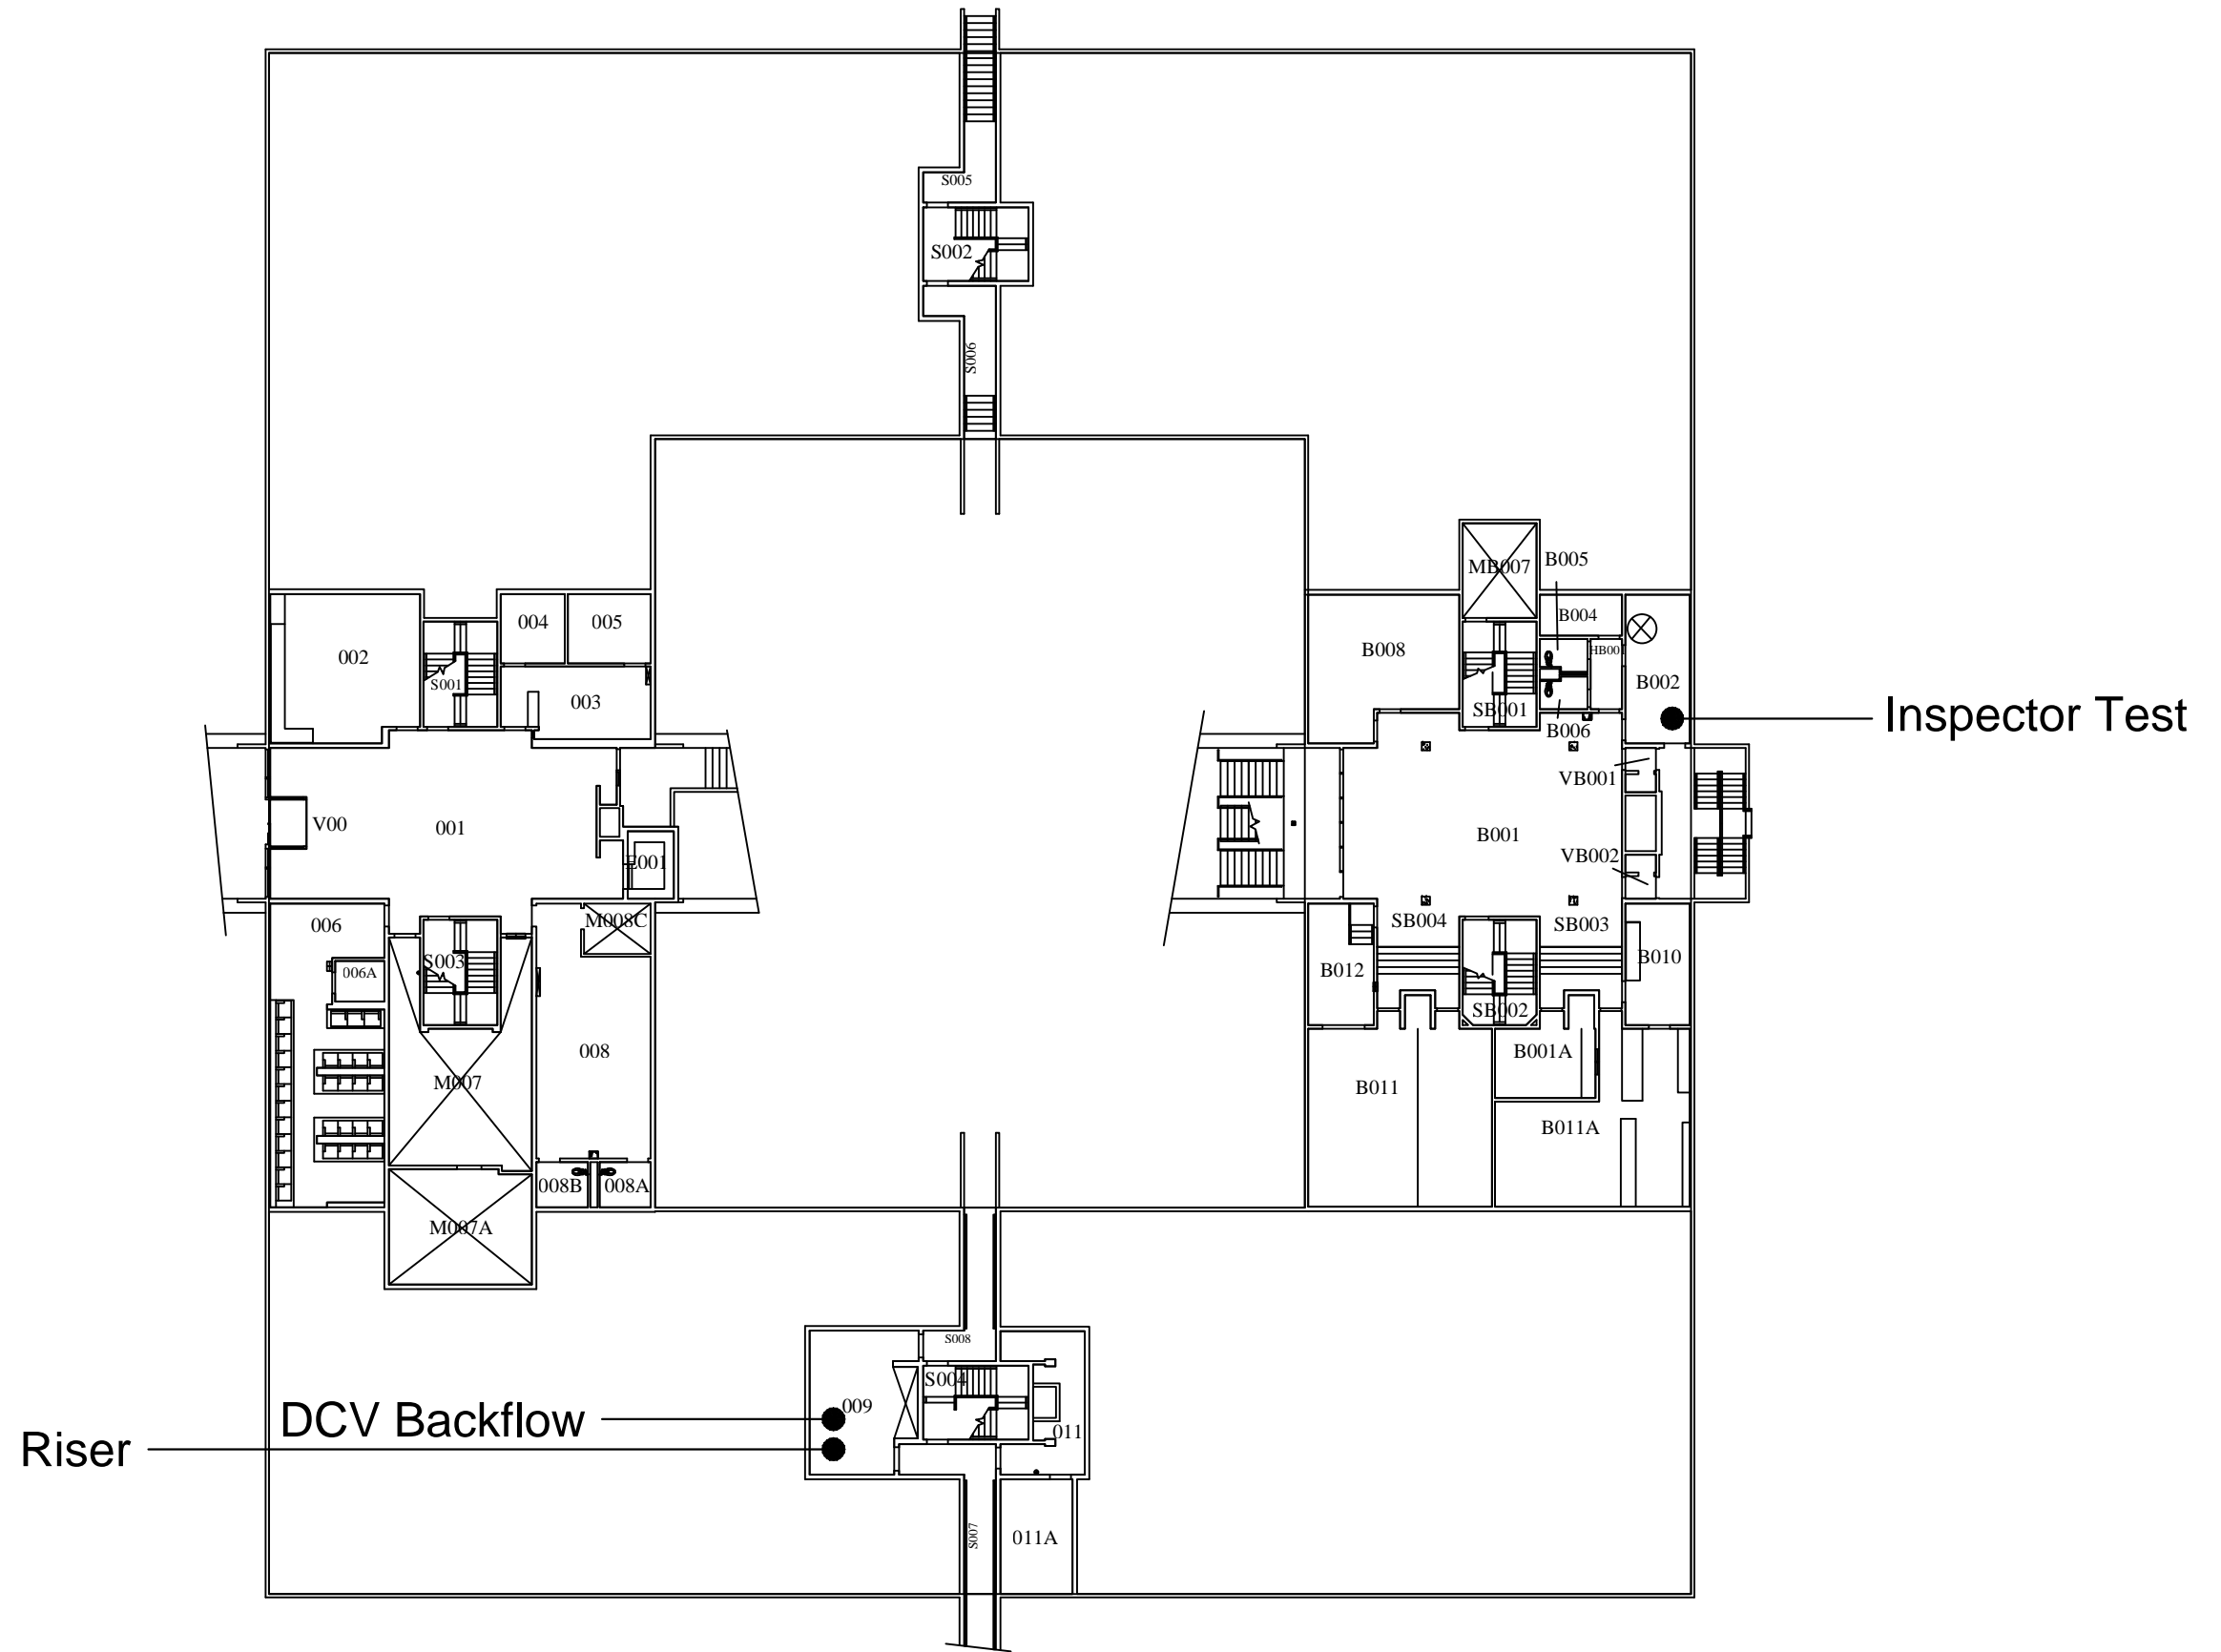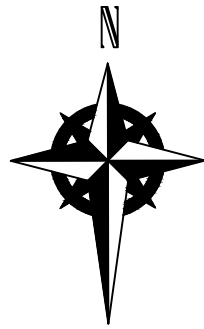

OREGON INSTITUTE OF TECHNOLOGY
Residence Hall Basement


Path: (T:)_Facilities_Campus...Floor...
Prepared by: Dustin Huddleston

Scale: NTS
Date: 11/4/2013

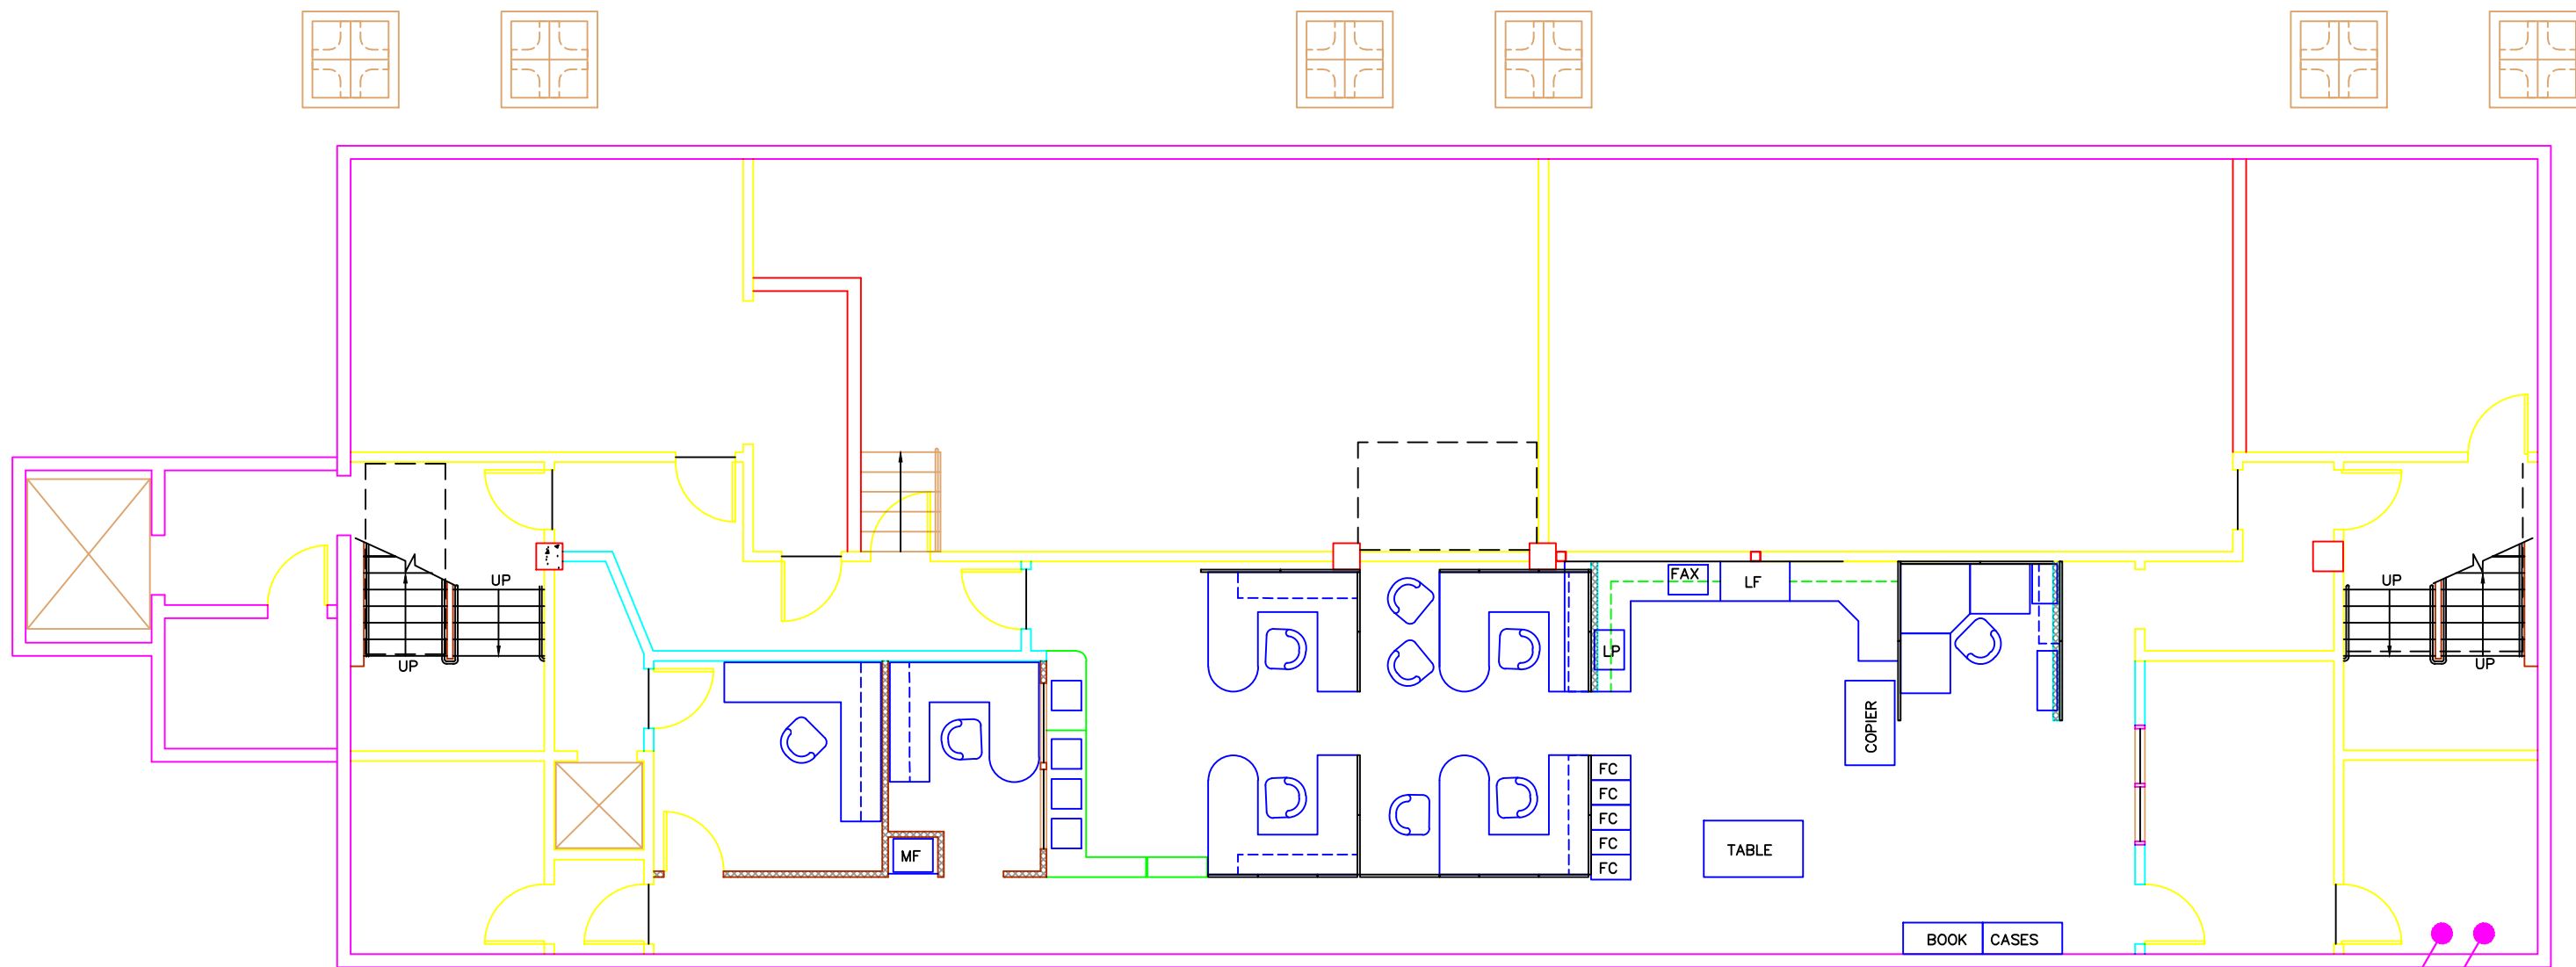

Riser & Inspector Test

DCV Backflow

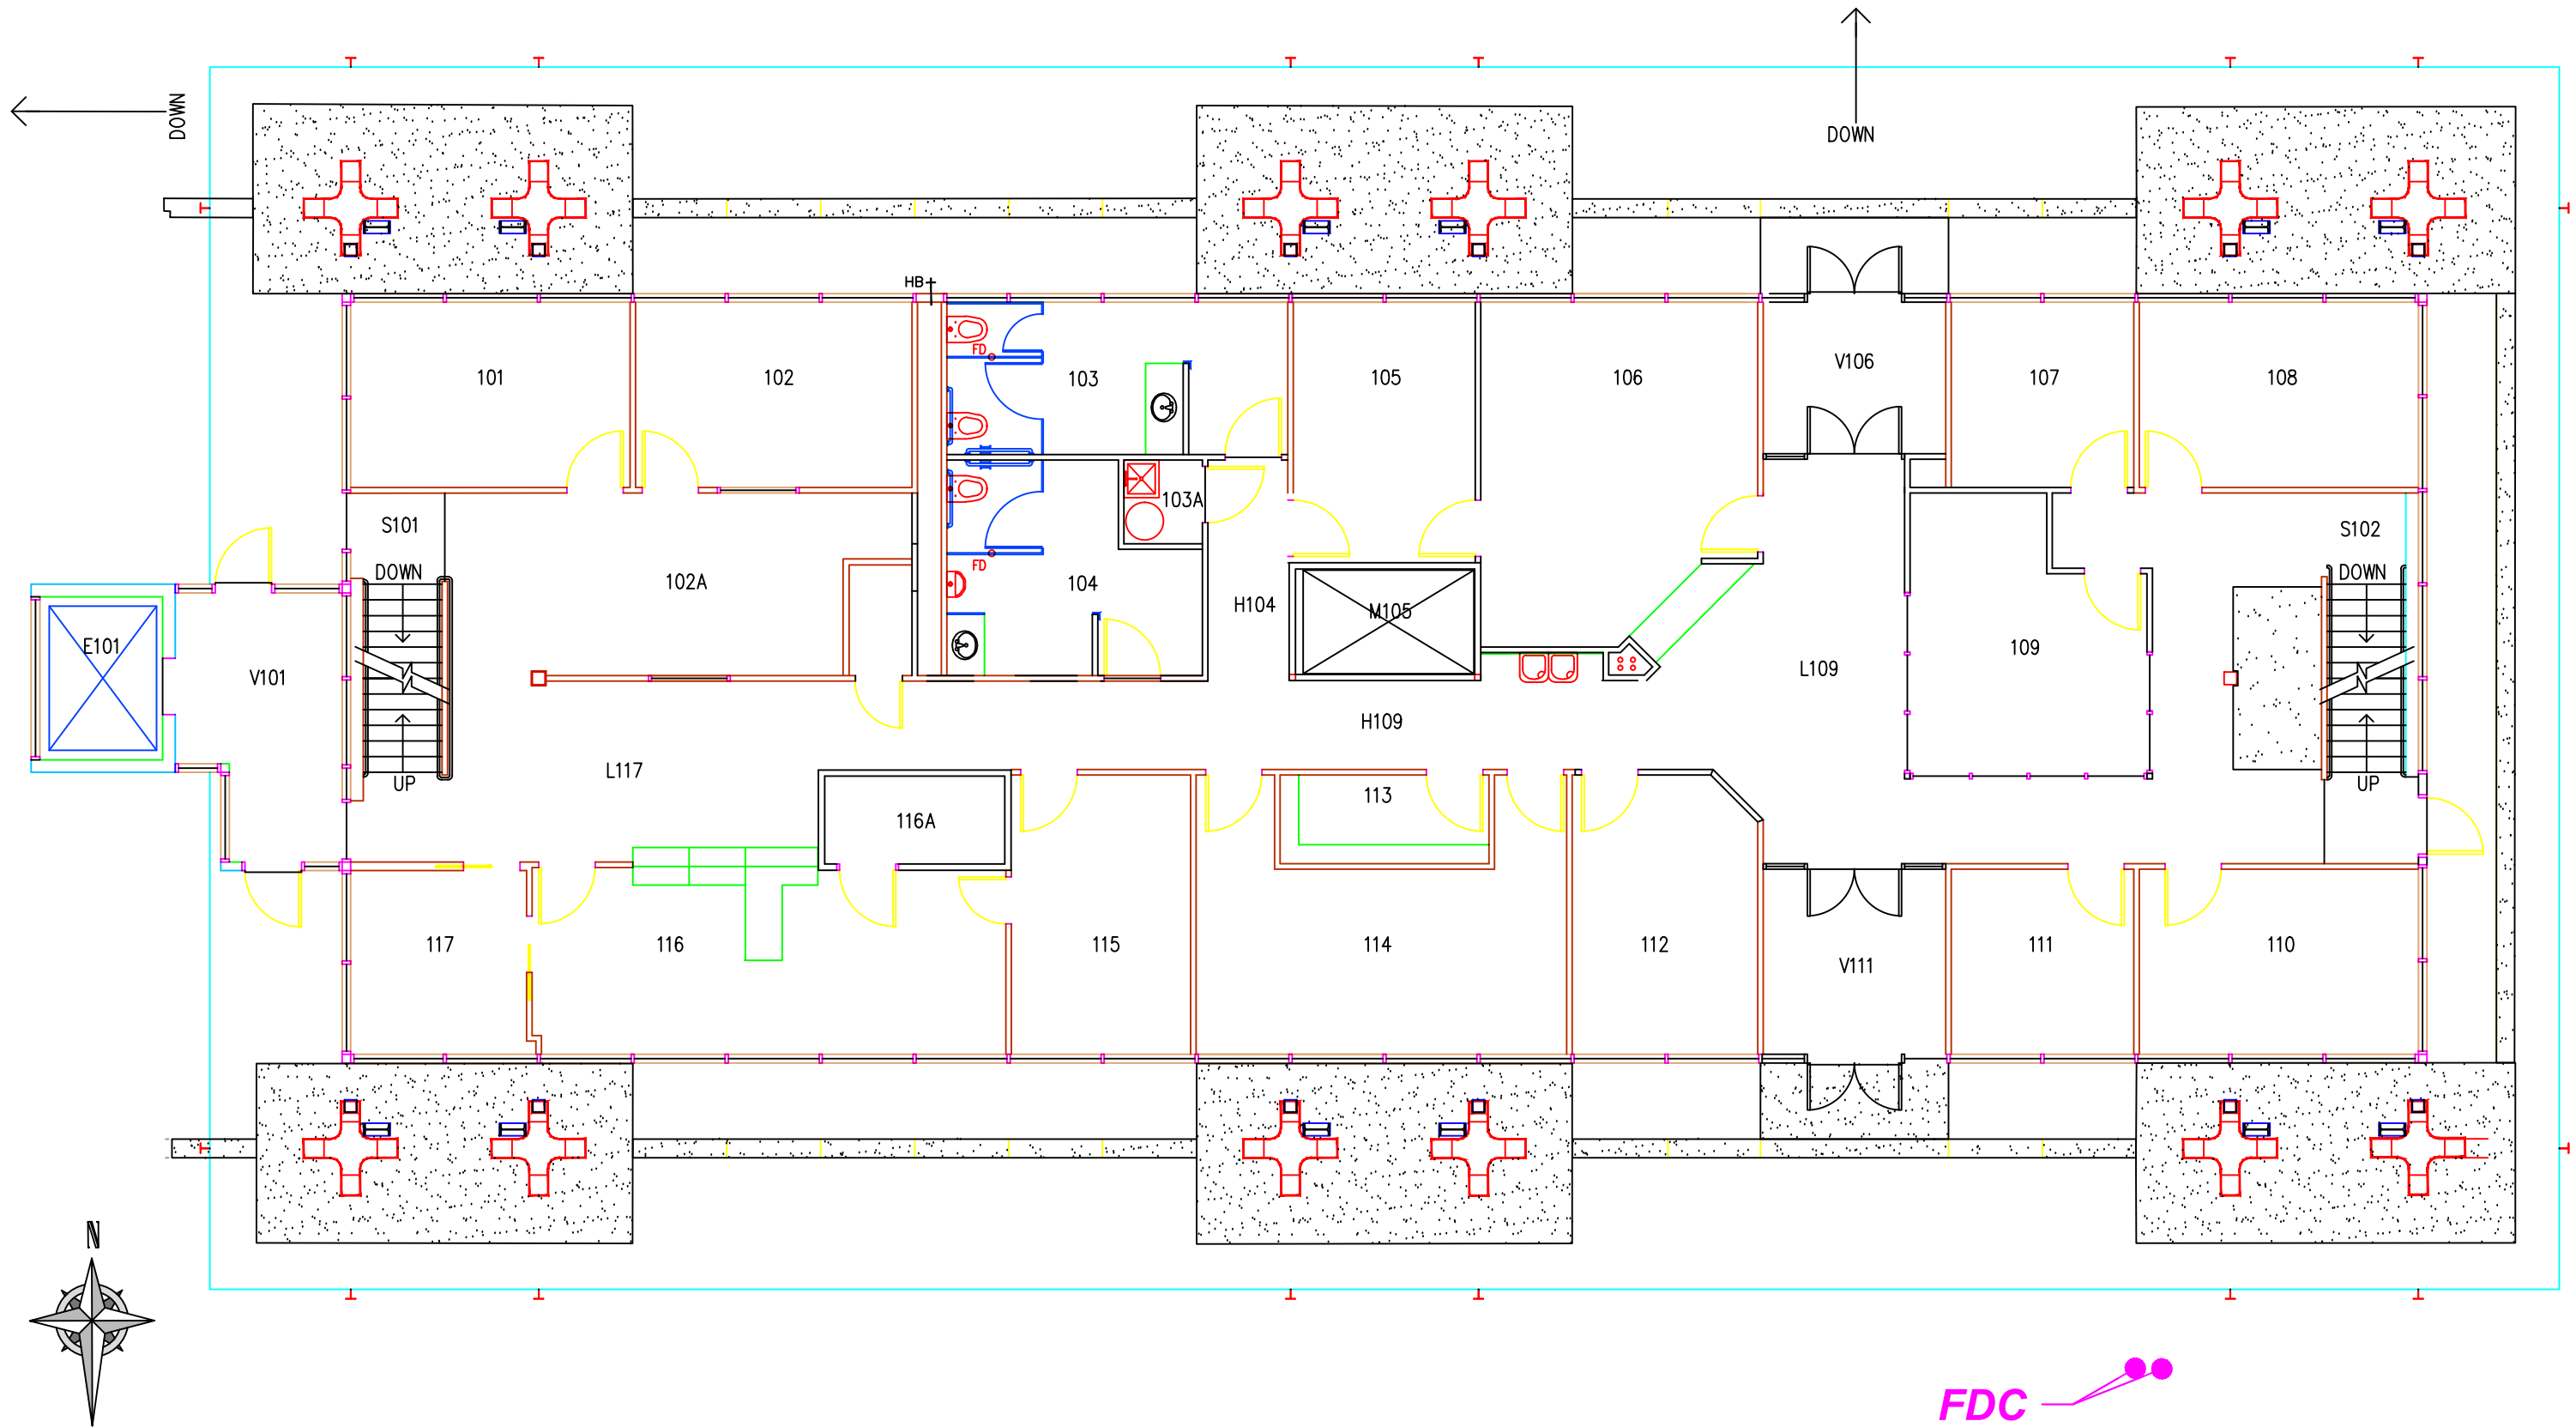

OREGON INSTITUTE OF TECHNOLOGY
Snell 1st Floor

Path: (T:)_Facilities_Campus... Floor...
 Prepared by: Dustin Huddleston

Scale: NTS
 Date: 11/1/2013



FDC

Riser & Inspector Test

2 DCV Backflow


OREGON INSTITUTE OF TECHNOLOGY
Village A (Yellow) - Level 1

Path: (T:)_Facilities_Campus...Floor...

Prepared by: Dustin Huddleston

Scale: 1/16" = 1'-0"

Date: 11/4/2013

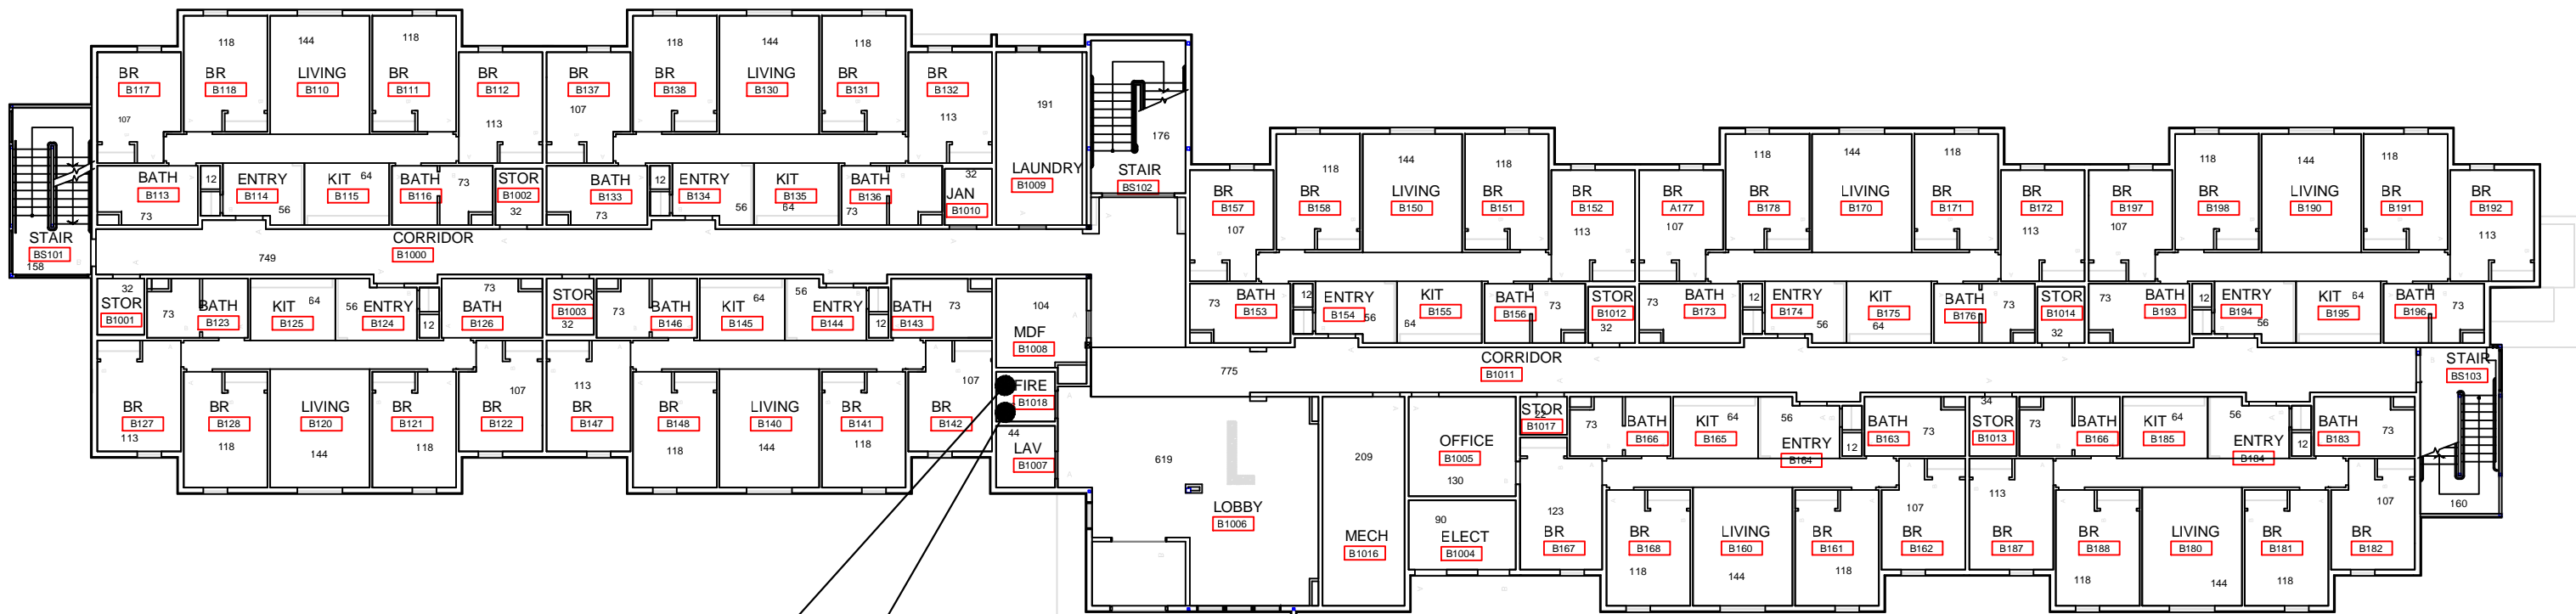

2 DCV Backflow

Riser & Inspector Test

FDC


OREGON INSTITUTE OF TECHNOLOGY
Village B (Blue) - Level 1

Path: (T:)_Facilities_Campus...Floor...

Prepared by: Dustin Huddleston

Scale: NTS

Date: 11/4/2013

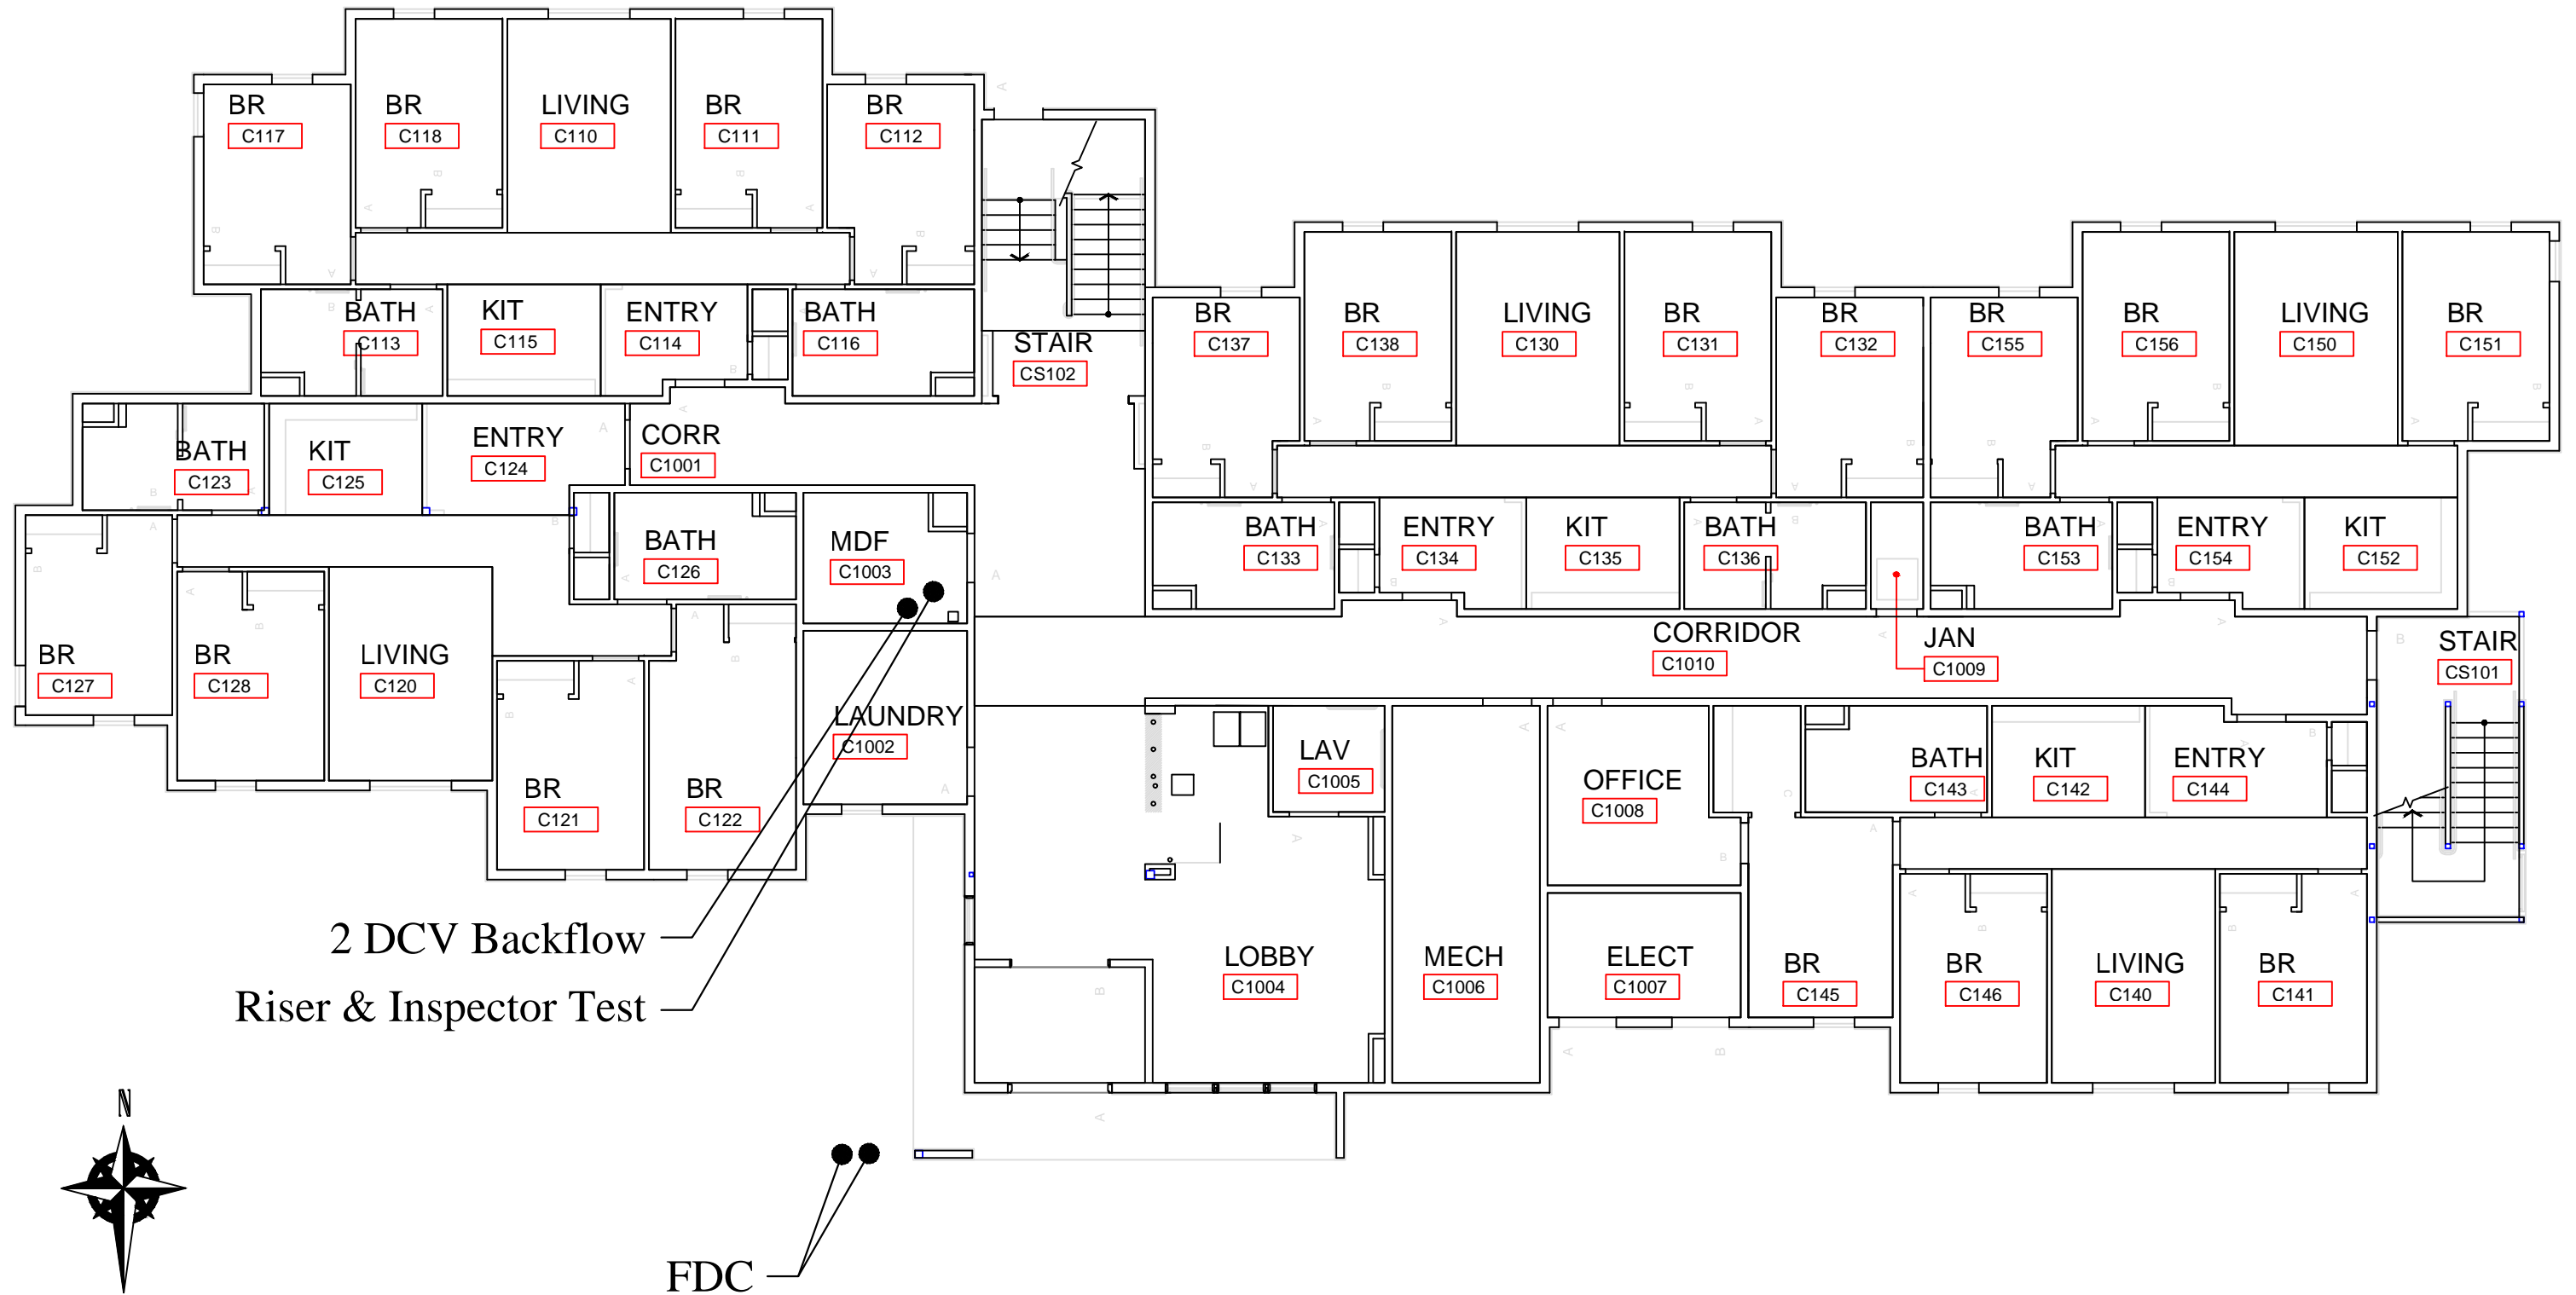

OREGON INSTITUTE OF TECHNOLOGY
Village C (Red) - Level 1

Path: (T:)_Facilities_Campus...Floor...

Prepared by: Dustin Huddleston

Scale: NTS

Date: 11/4/2013