



**SYSTEMS WEST  
ENGINEERS**

725 A Street  
Springfield, OR 97477  
541.342.7210  
systemswestengineers.com

Preliminary  
Not for  
Construction



**OSU BURT HALL 3  
HVAC UPGRADE  
DESIGN**

**MECHANICAL EARLY  
PROCUREMENT**

**LOCATION:**  
2651 NW Orchard Ave,  
Corvallis, OR 97330

**OWNER:**  
Oregon State University

**One Line DIAGRAM  
- 4 CRAC UNITS**

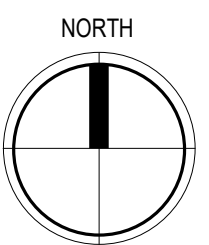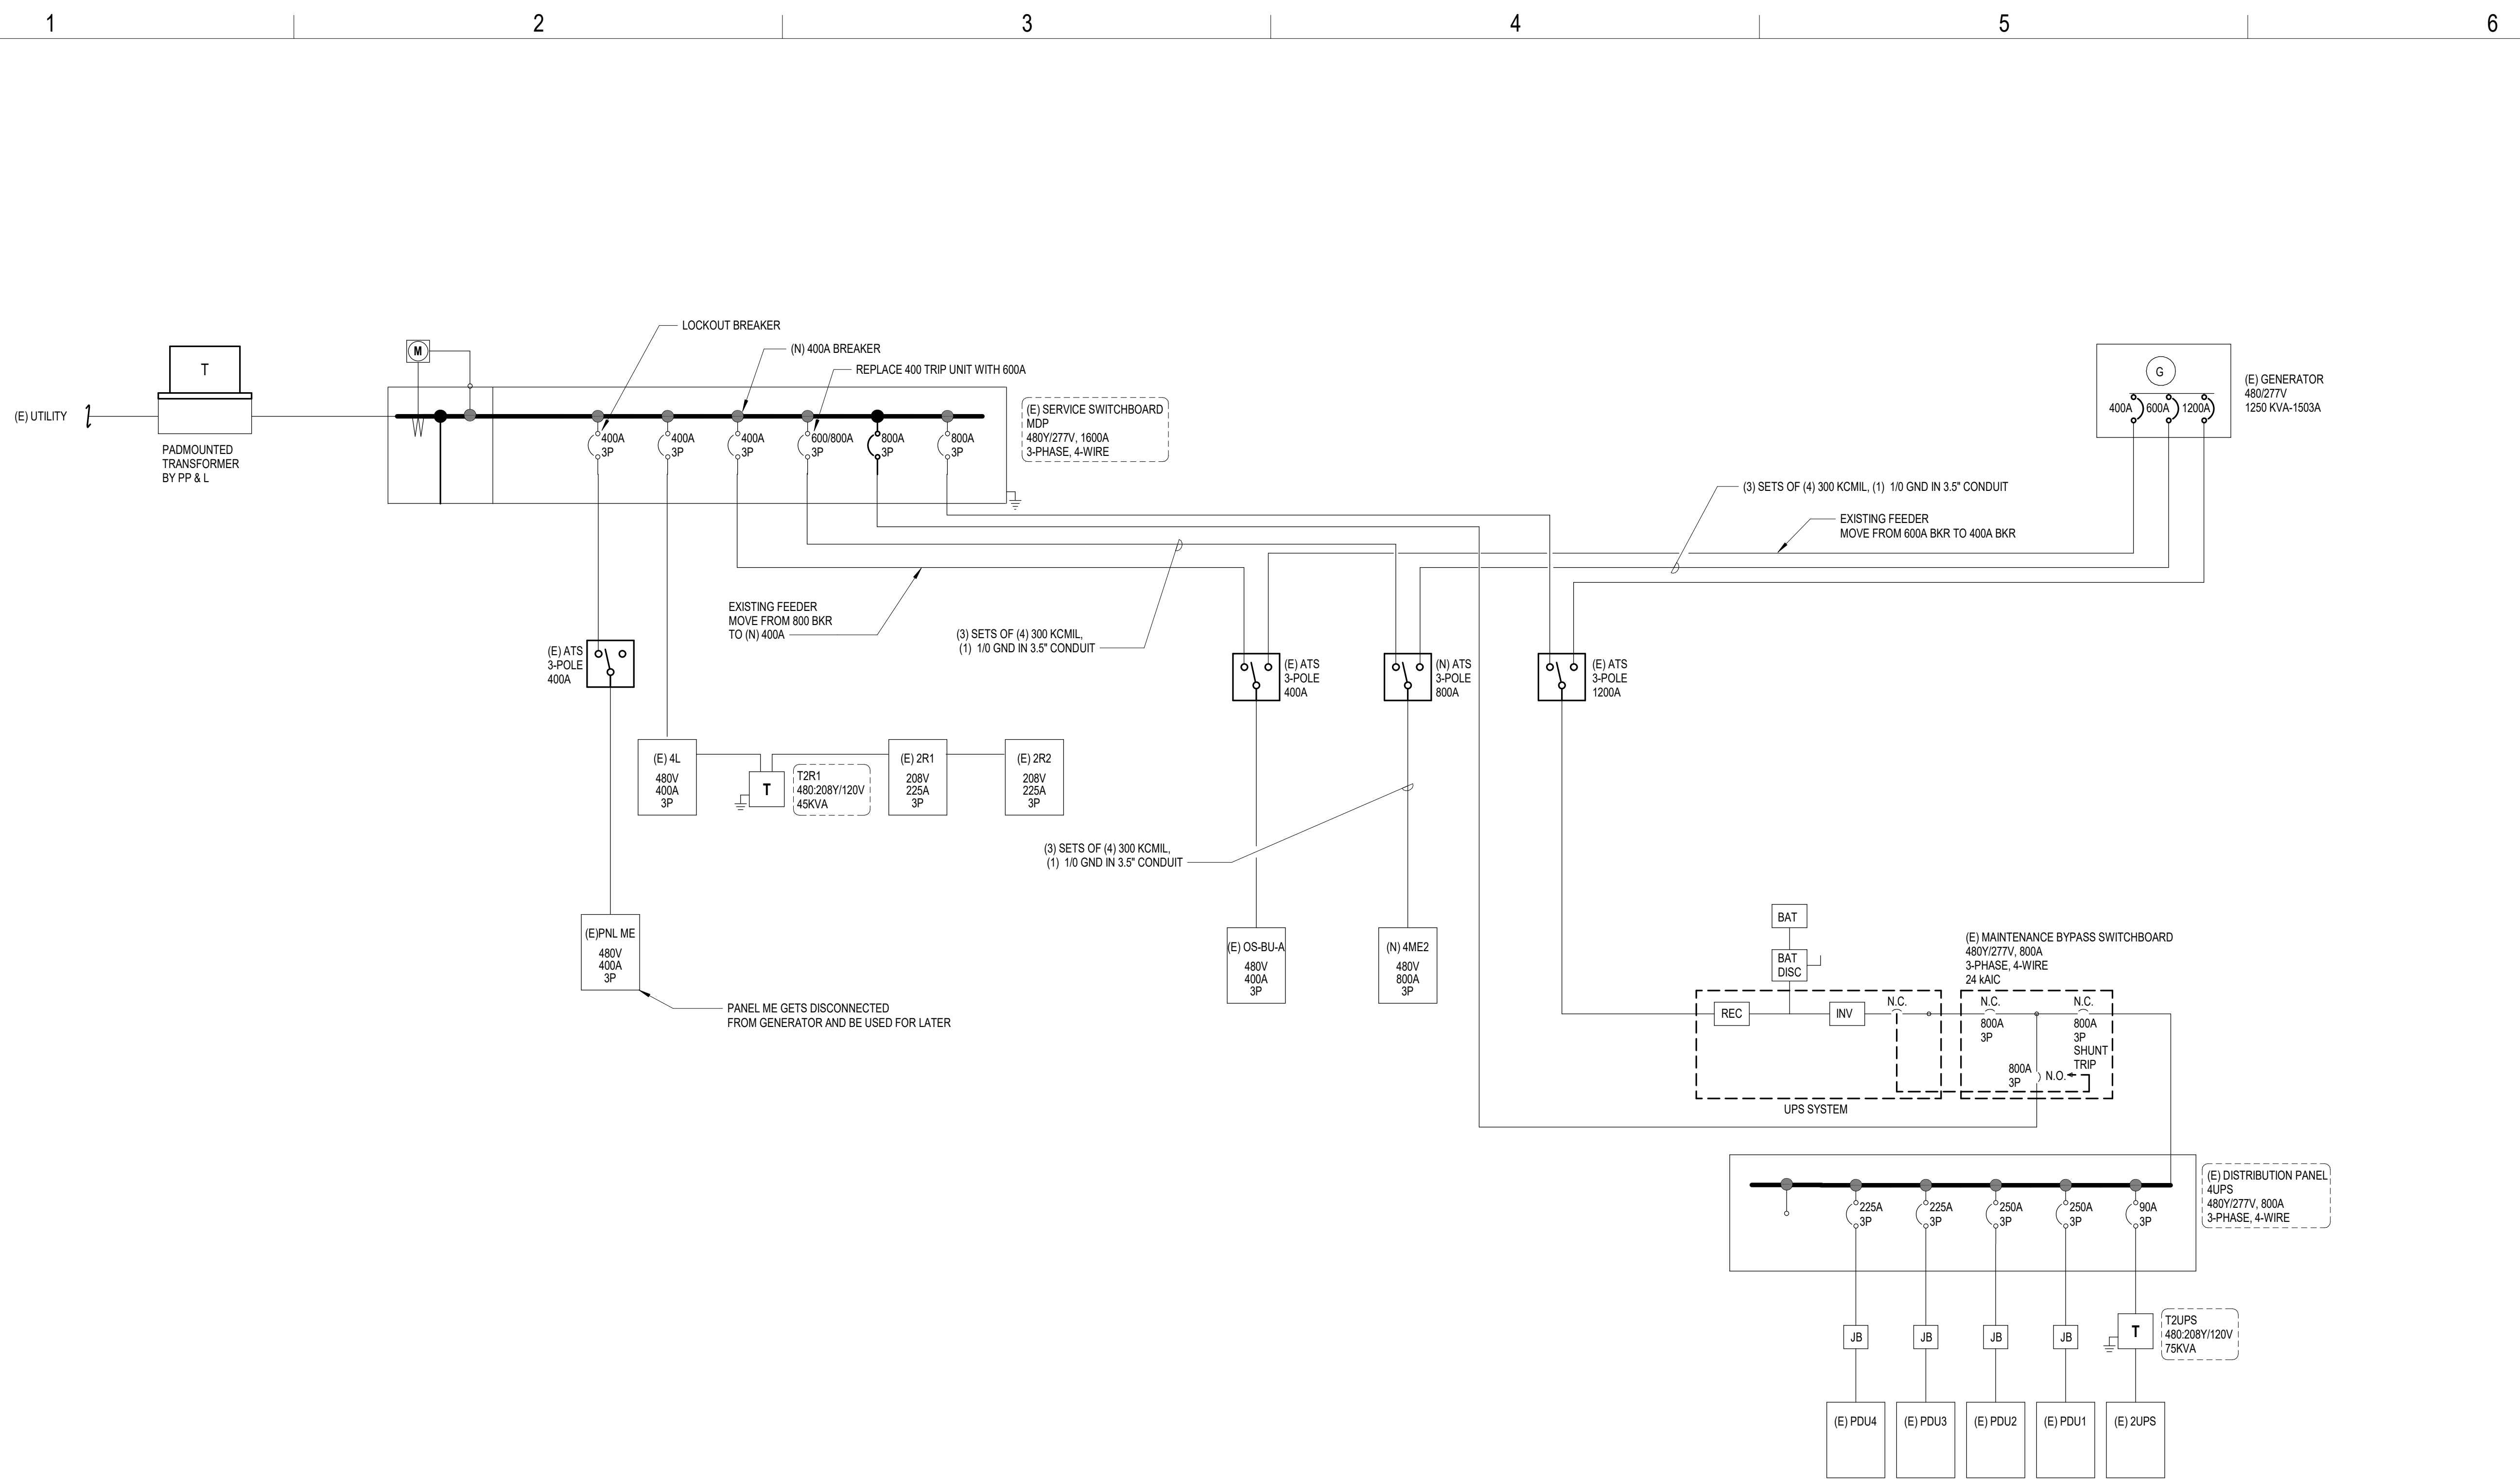

**1 ONE LINE DIAGRAM - 4 CRAC UNITS**  
1/8" = 1'-0"

PLOTTED BY Author ON 4/24/2024 2:46:24 PM

MARK	DATE	DESCRIPTION

DESIGNED: Designer  
 DRAWN: Author  
 CHECKED: Checker

DATE: 02.16.2024  
 PROJECT: V015.22

**E614**