

REFERENCE ONLY UNLESS STAMP IS PLACED
(PLACE STAMP HERE)

© MACKENZIE 2024. ALL RIGHTS RESERVED. THESE DRAWINGS ARE THE PROPERTY OF MACKENZIE AND ARE NOT TO BE USED OR REPRODUCED IN ANY MANNER, WITHOUT PRIOR WRITTEN PERMISSION.

REVISION SCHEDULE		
Delta	Issued As	Issue Date


SHEET TITLE:
ELECTRICAL SITE DEMOLITION PLAN

SHEET

E0.01

JOB NO. **2220396.01**

SITE PLAN SHOWN FOR REFERENCE. SEE ENLARGE PLAN 2/E0.01 FOR DEMO SCOPE.


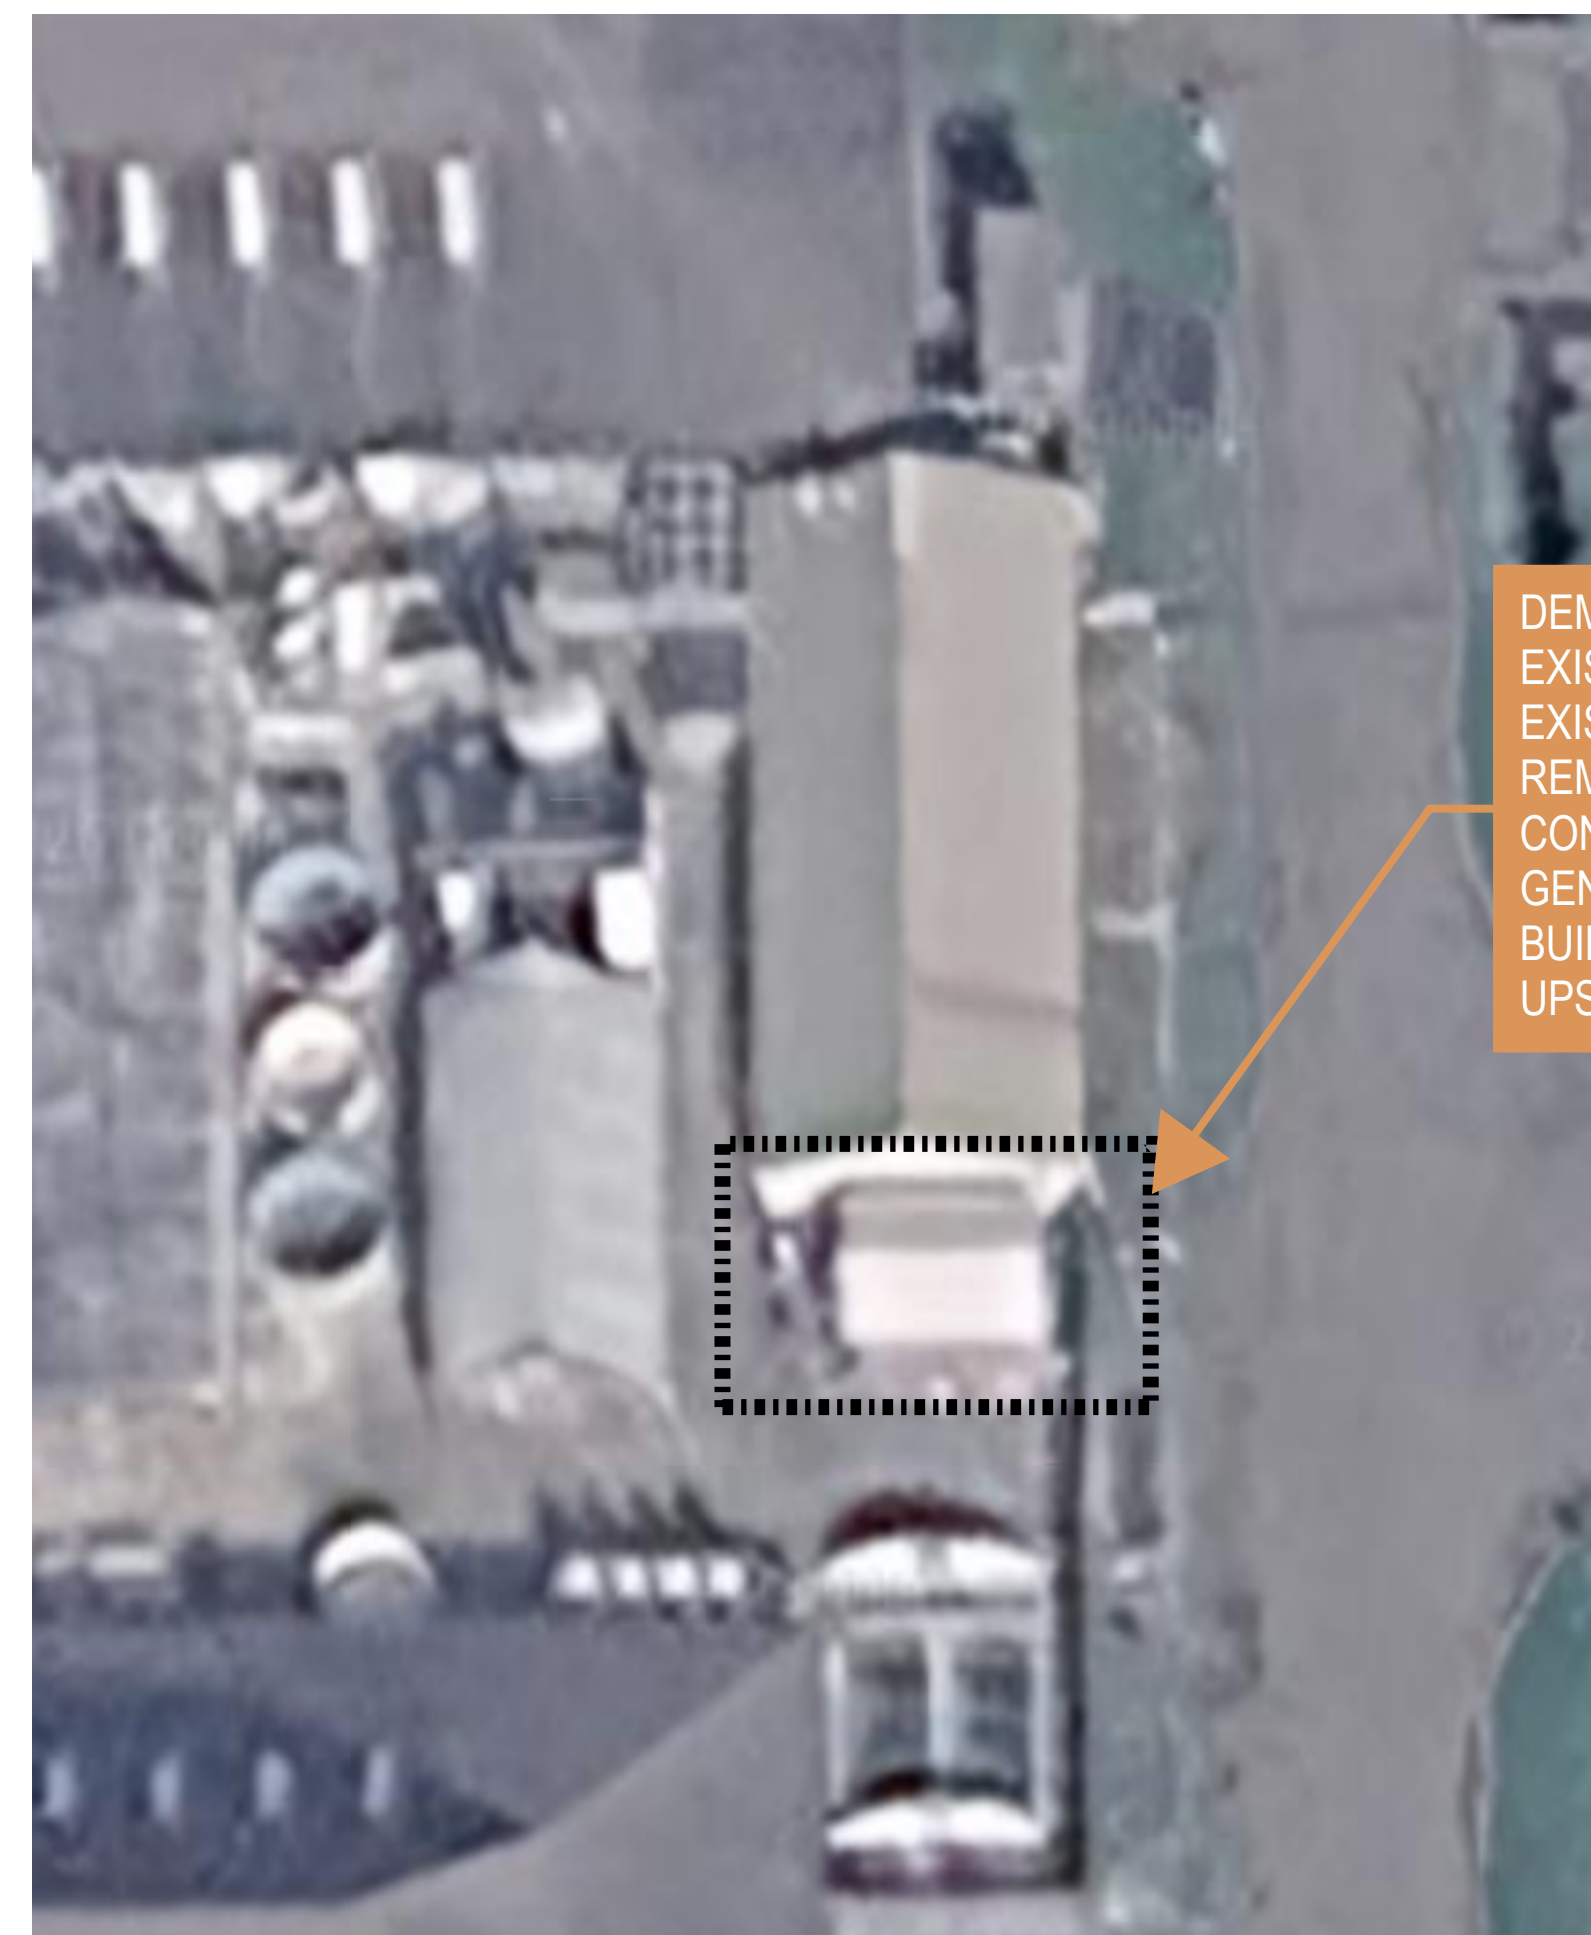


DEMOLITION SCOPE:
EXISTING BUILDING THAT HOUSES EXISTING GENERATOR TO BE REMOVED BY OTHERS. ELECTRICAL CONTRACTOR TO DEMOLISH EXISTING GENERATOR AND DIESEL TANK WITHIN BUILDING. EXISTING CONDUIT STUB UPS AND CONDUCTORS TO REMAIN.

2 ENLARGED SITE PLAN
E0.01 NTS

1 SITE PLAN
E0.01 1" = 100'-0"


* THESE ITEMS TO BE FURNISHED BY CONTRACTOR. BUILDING TO BE SUPPLIED PRE-WIRED.

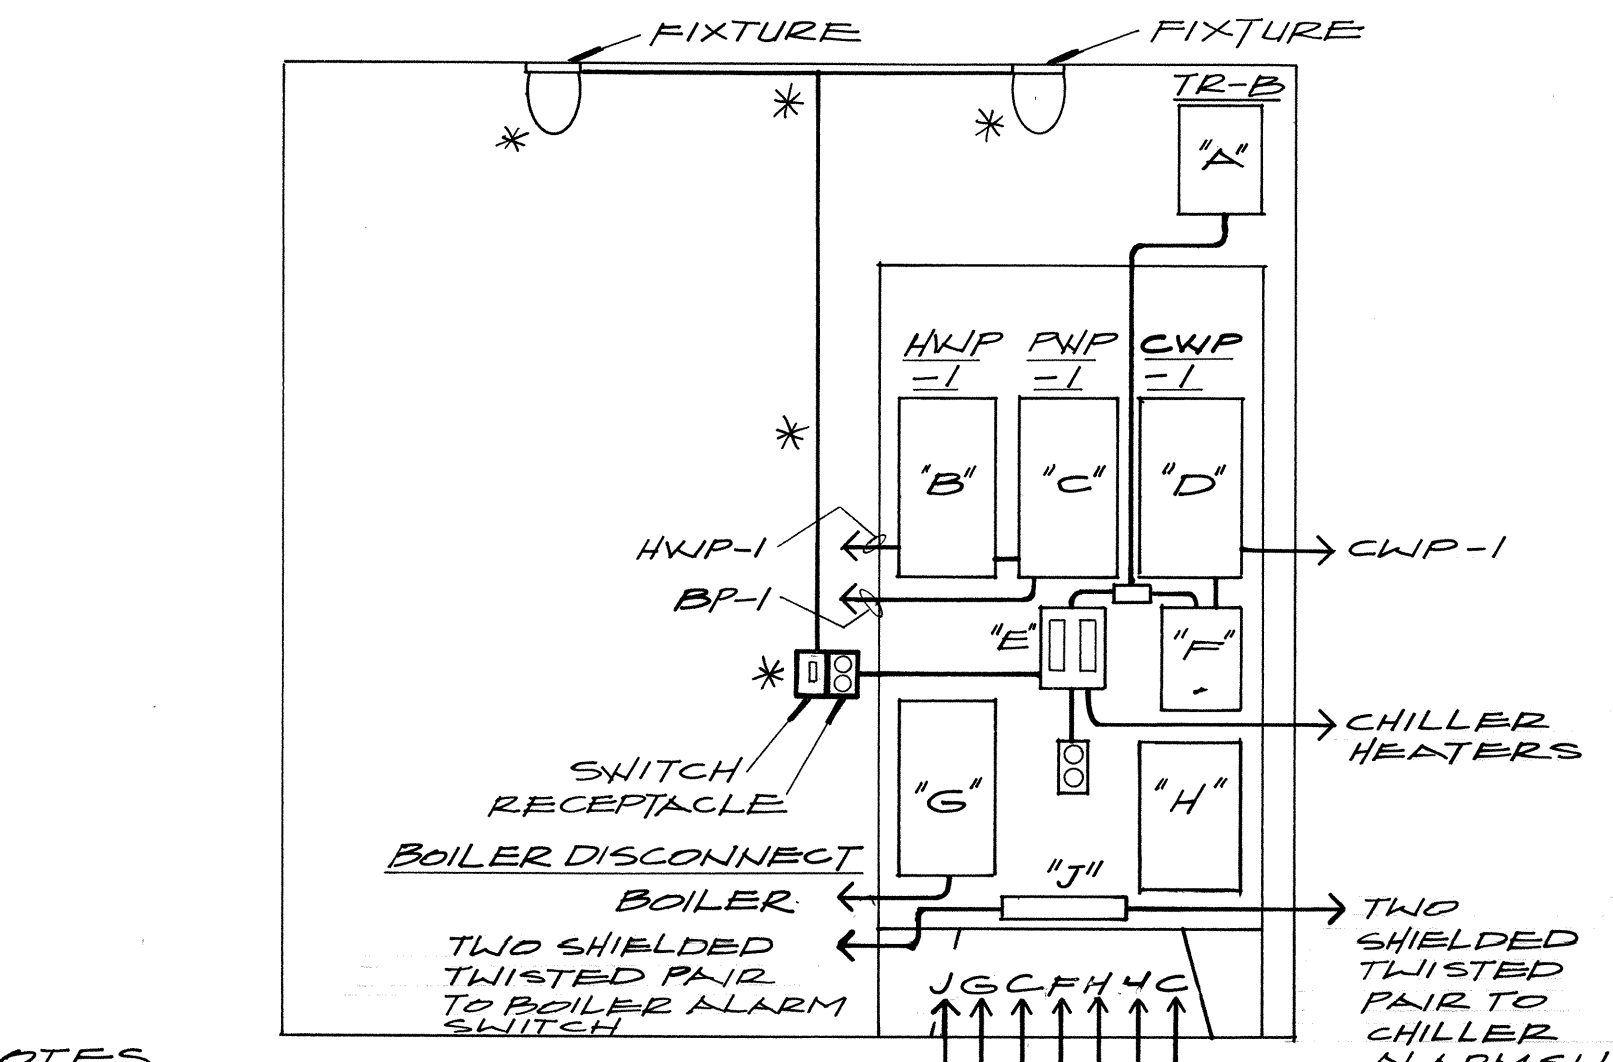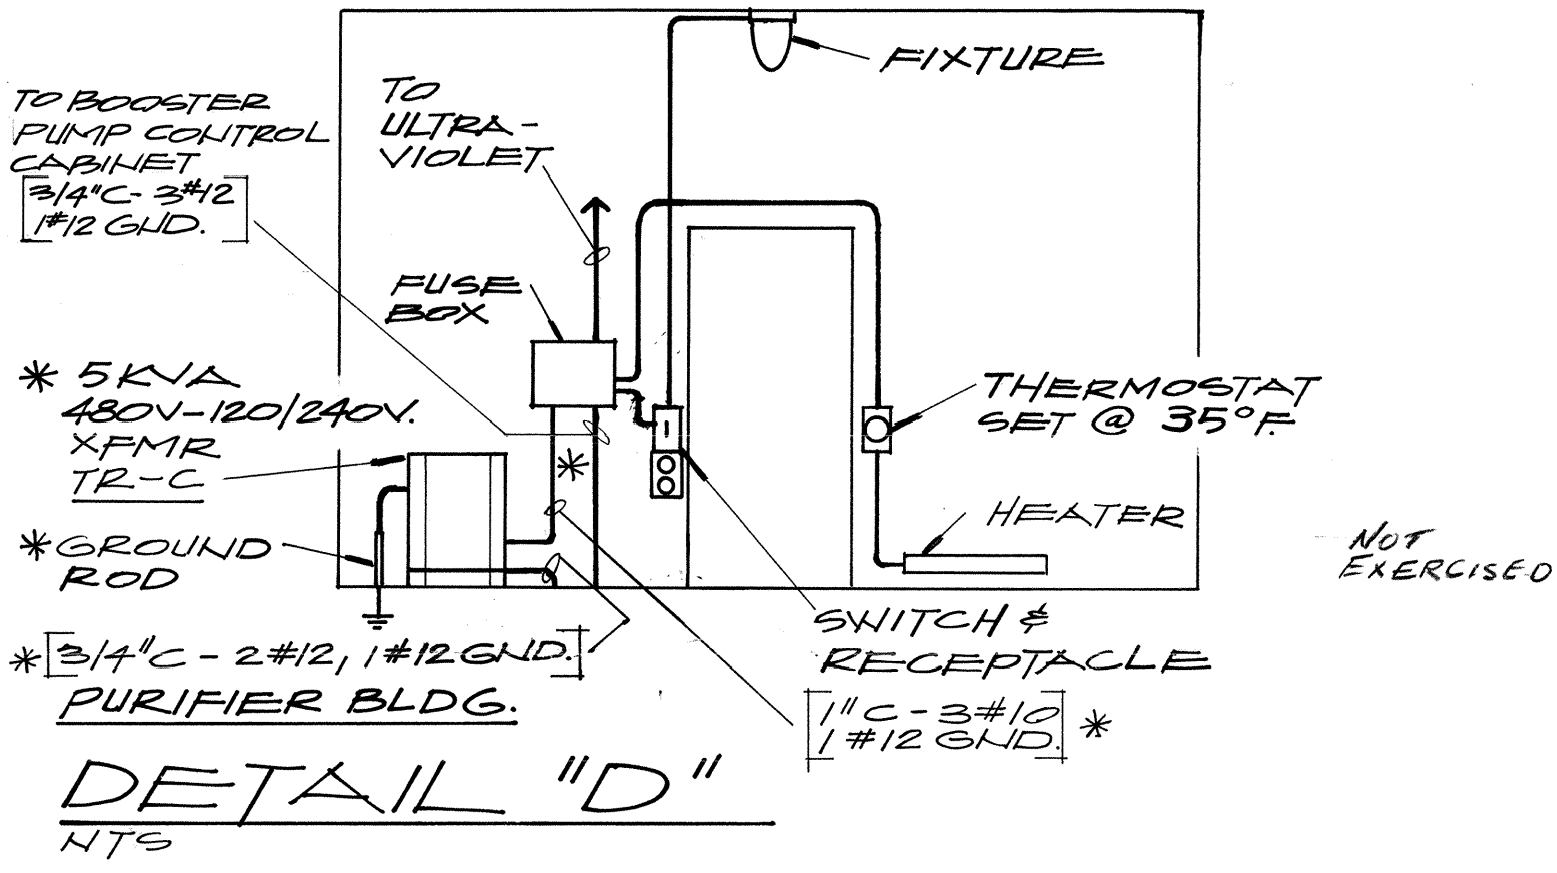


NOTES

- "A" 5KVA DRY TYPE TRANSFORMER
- "B" NON-FUSED COMBINATION STARTER
- "C" 50" D CLASS 8533 TYPE SG-II COMPLETE W/STOP-START RB'S
- "E" BREAKER PANEL, 50" D 400P WITH GROUND BAR & 2-20A. CIRC. BRKR.
- "F" FUSIBLE DISCONNECT 50" D H261 WITH 10A. FUSE.
- "G" NON-FUSIBLE DISCONNECT 50" D H363
- "H" NON-FUSIBLE DISCONNECT 50" D H362
- "J" TERMINAL BLOCK FOR 9TW.PR.


DETAIL "E"
NTS
* SUPPLIED WITH BUILDING

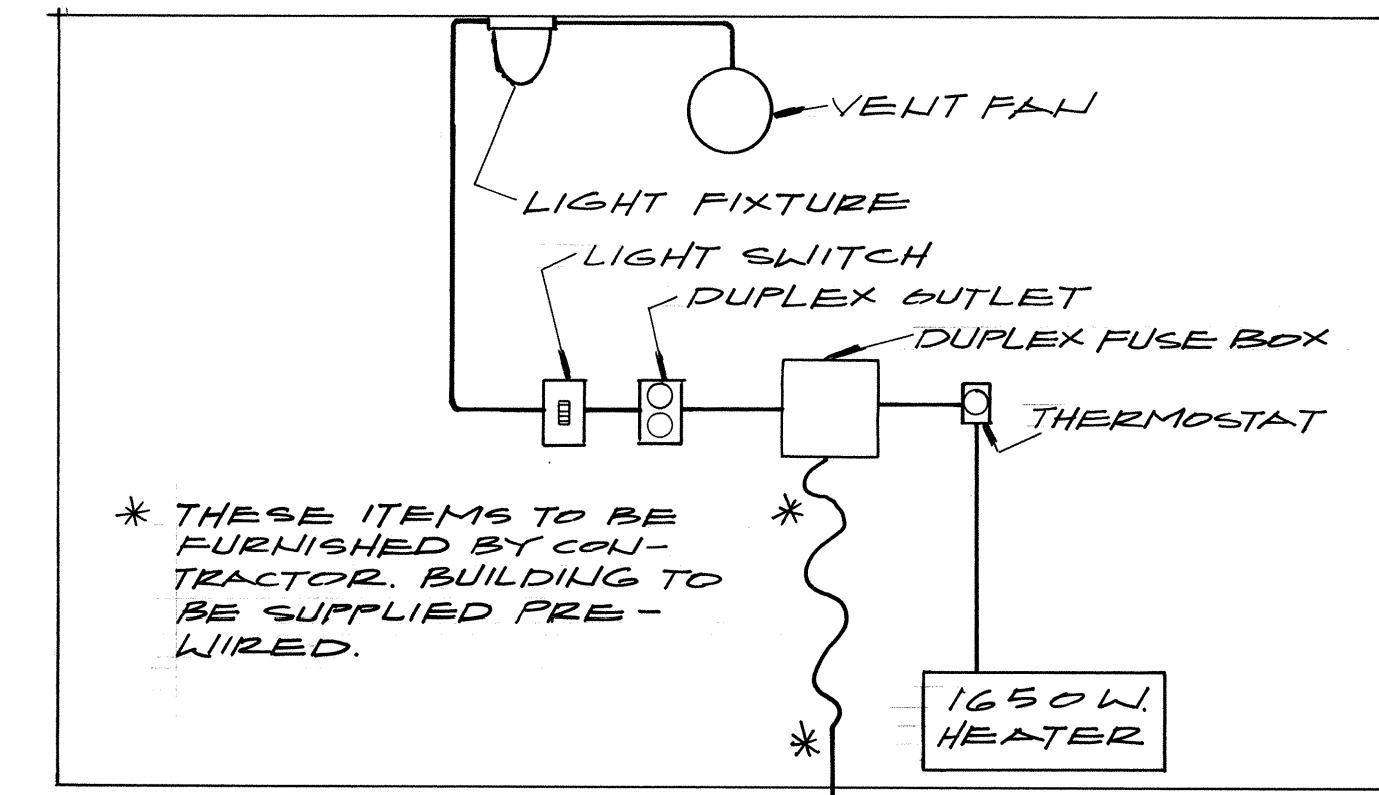






CHLORINATOR BLDG.
DETAIL "F"
NTS

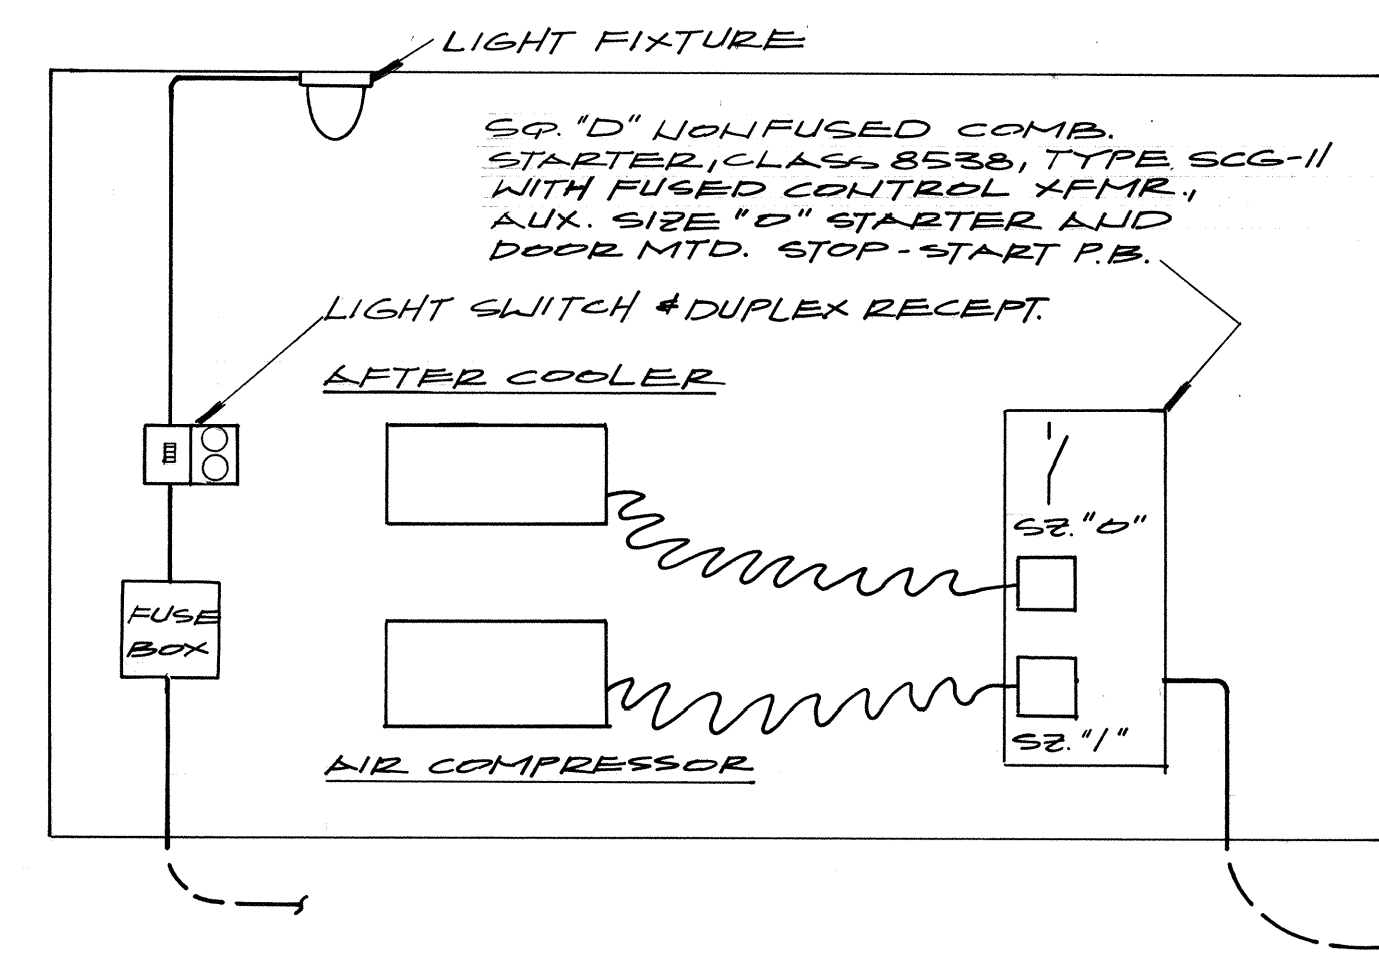

AIR COMPRESSOR BLDG.
DETAIL "G"
NTS


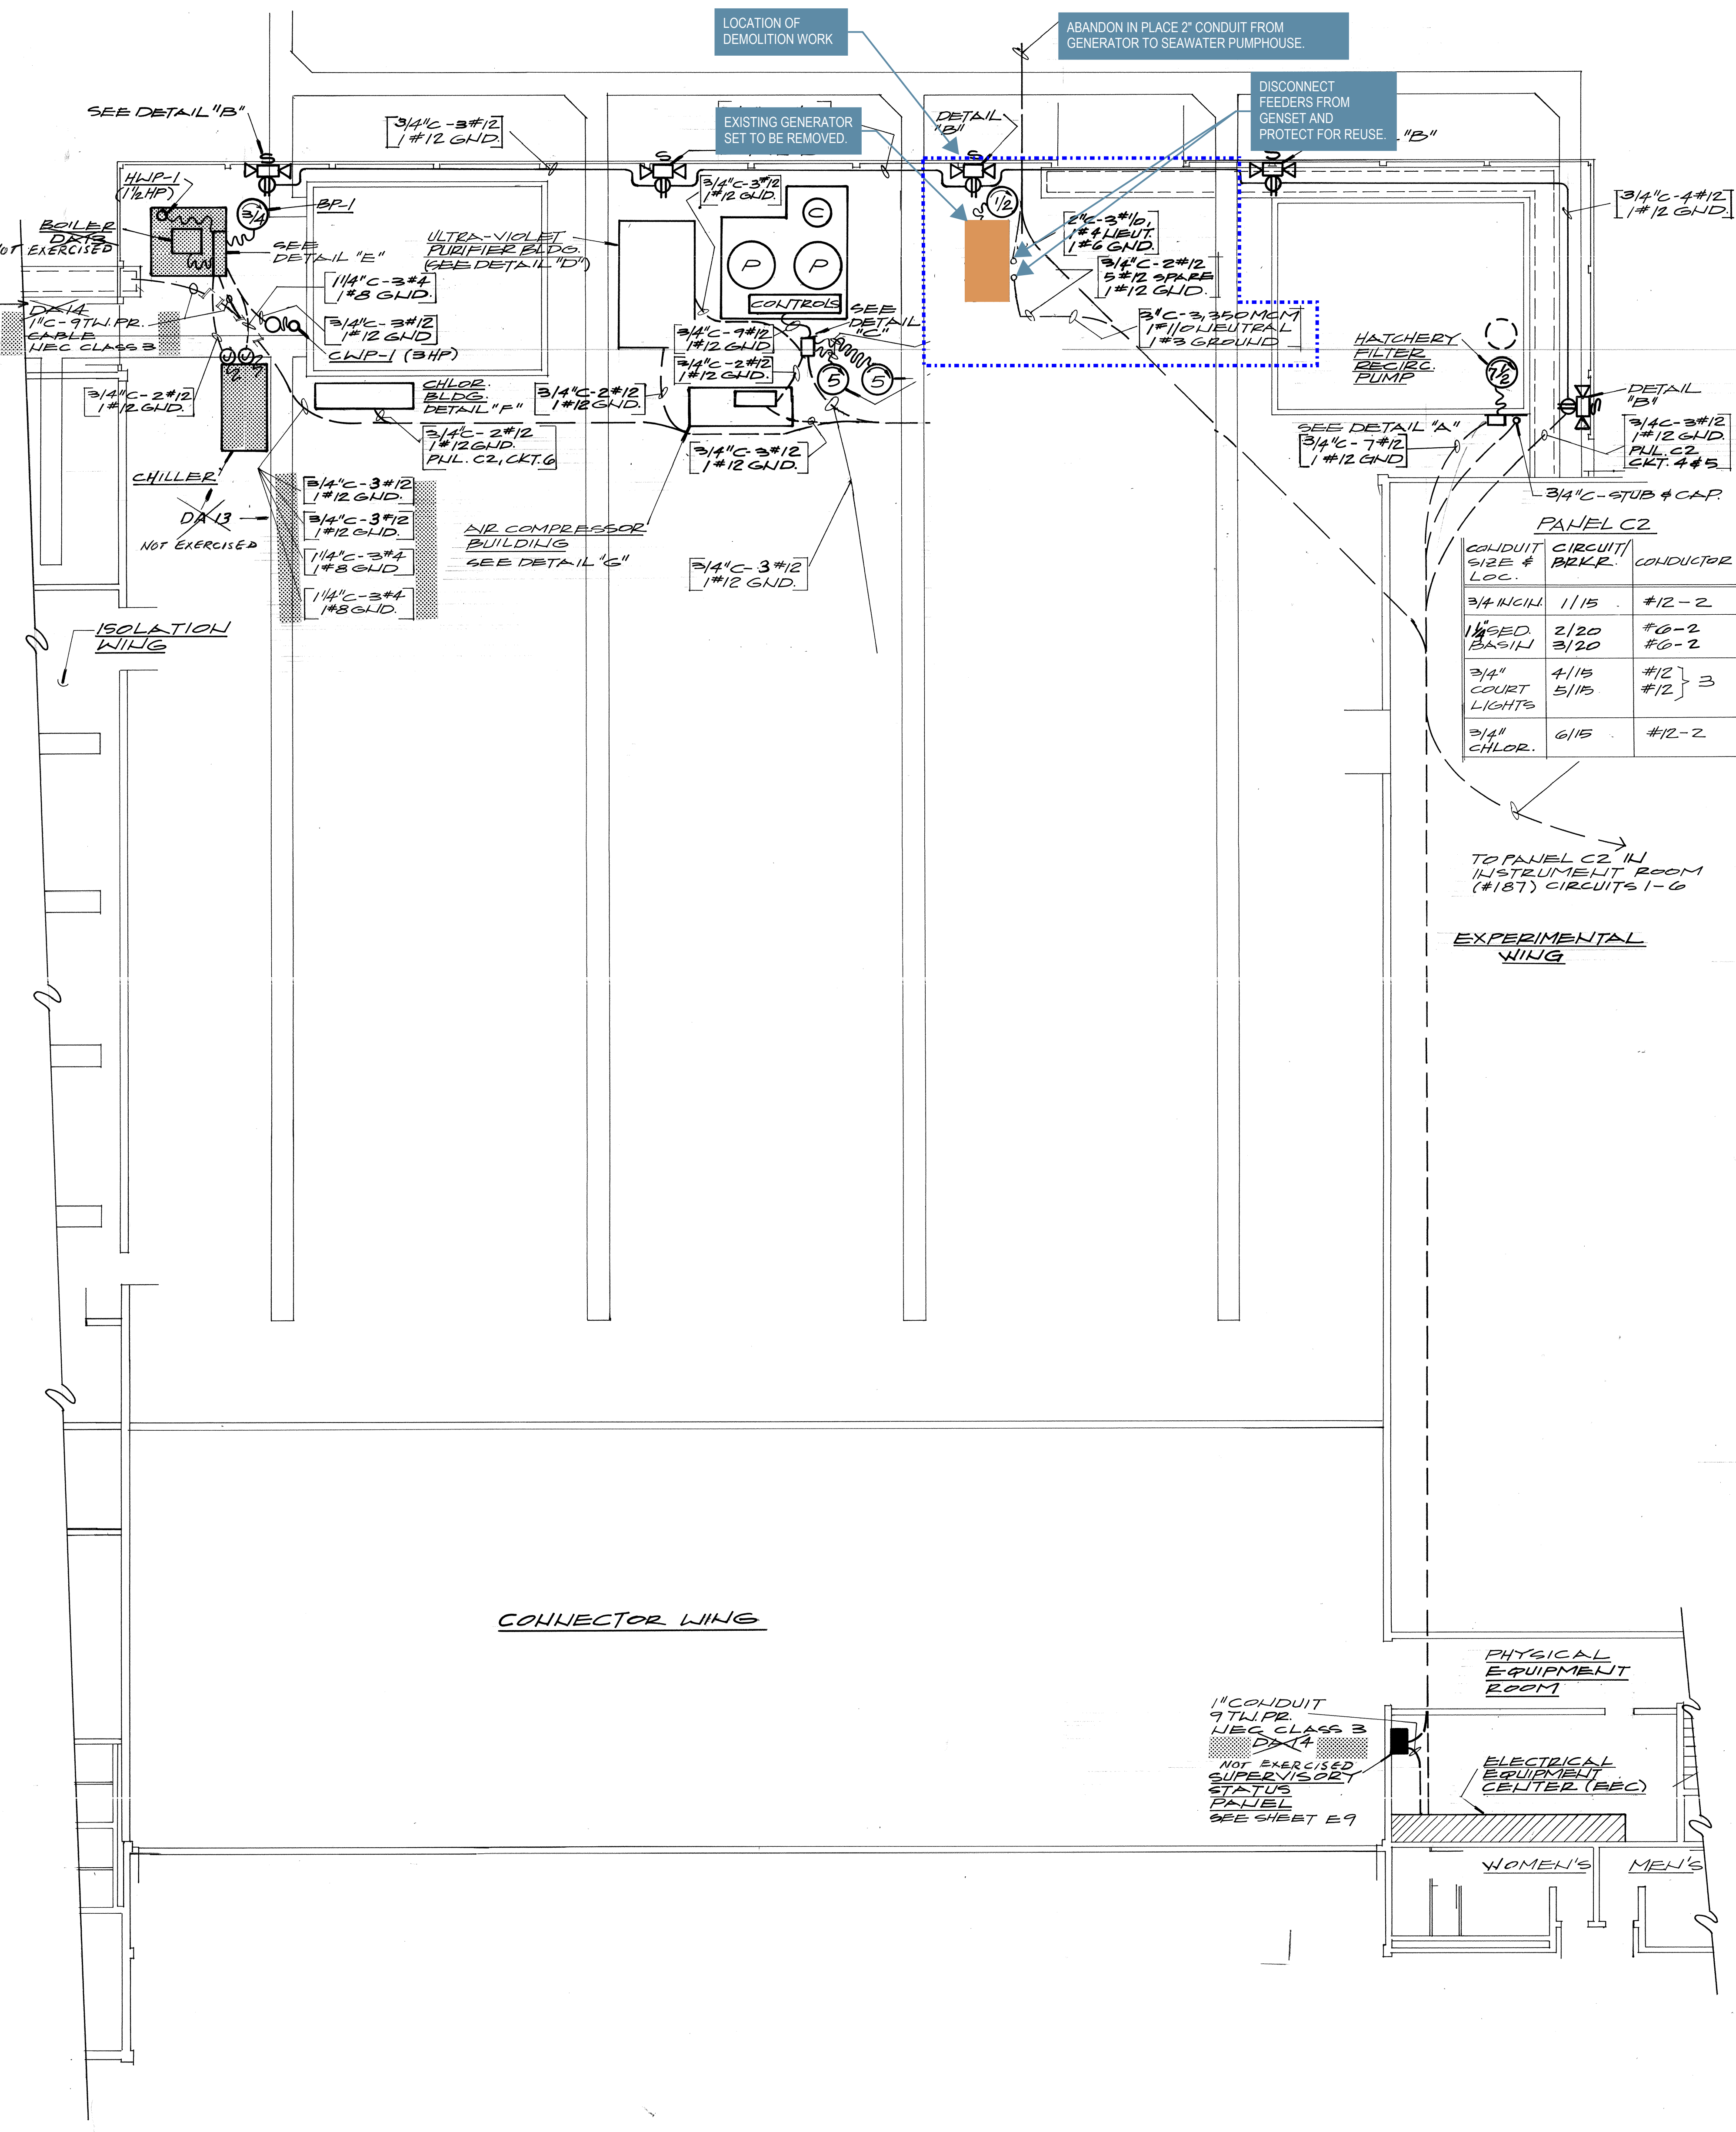


DEMOLITION FLOOR PLAN

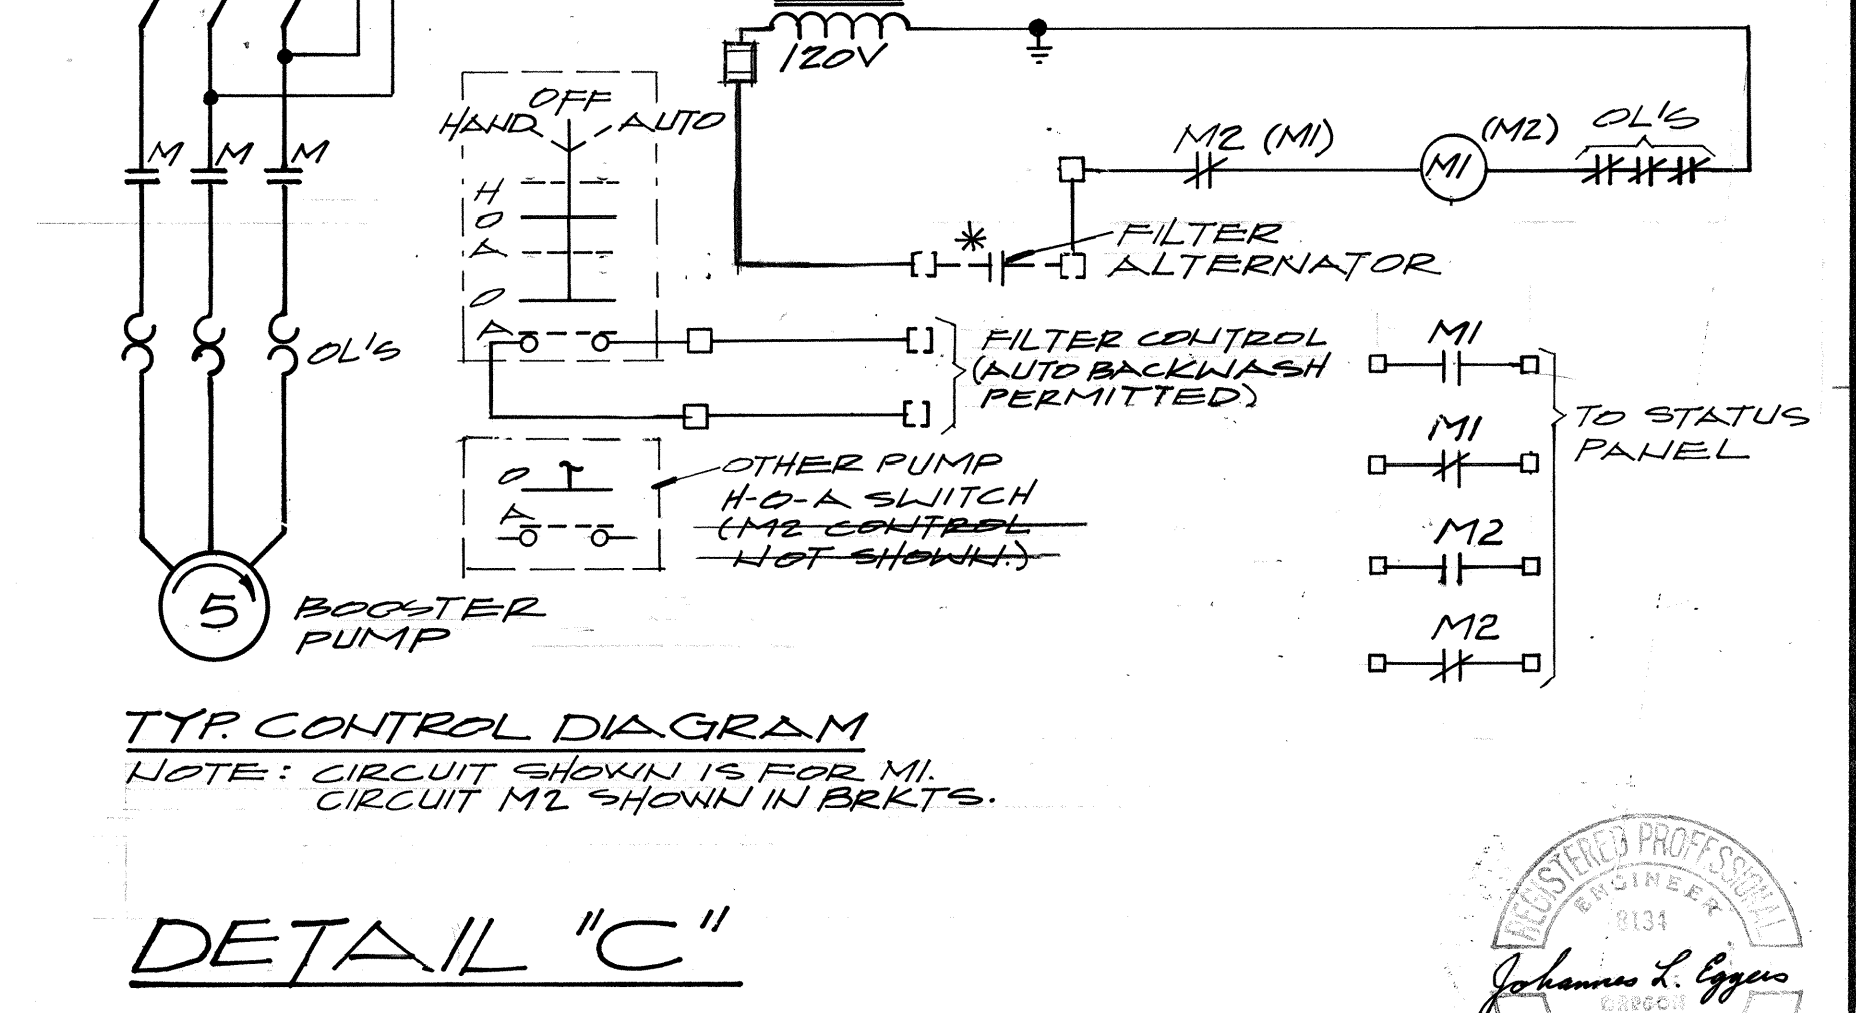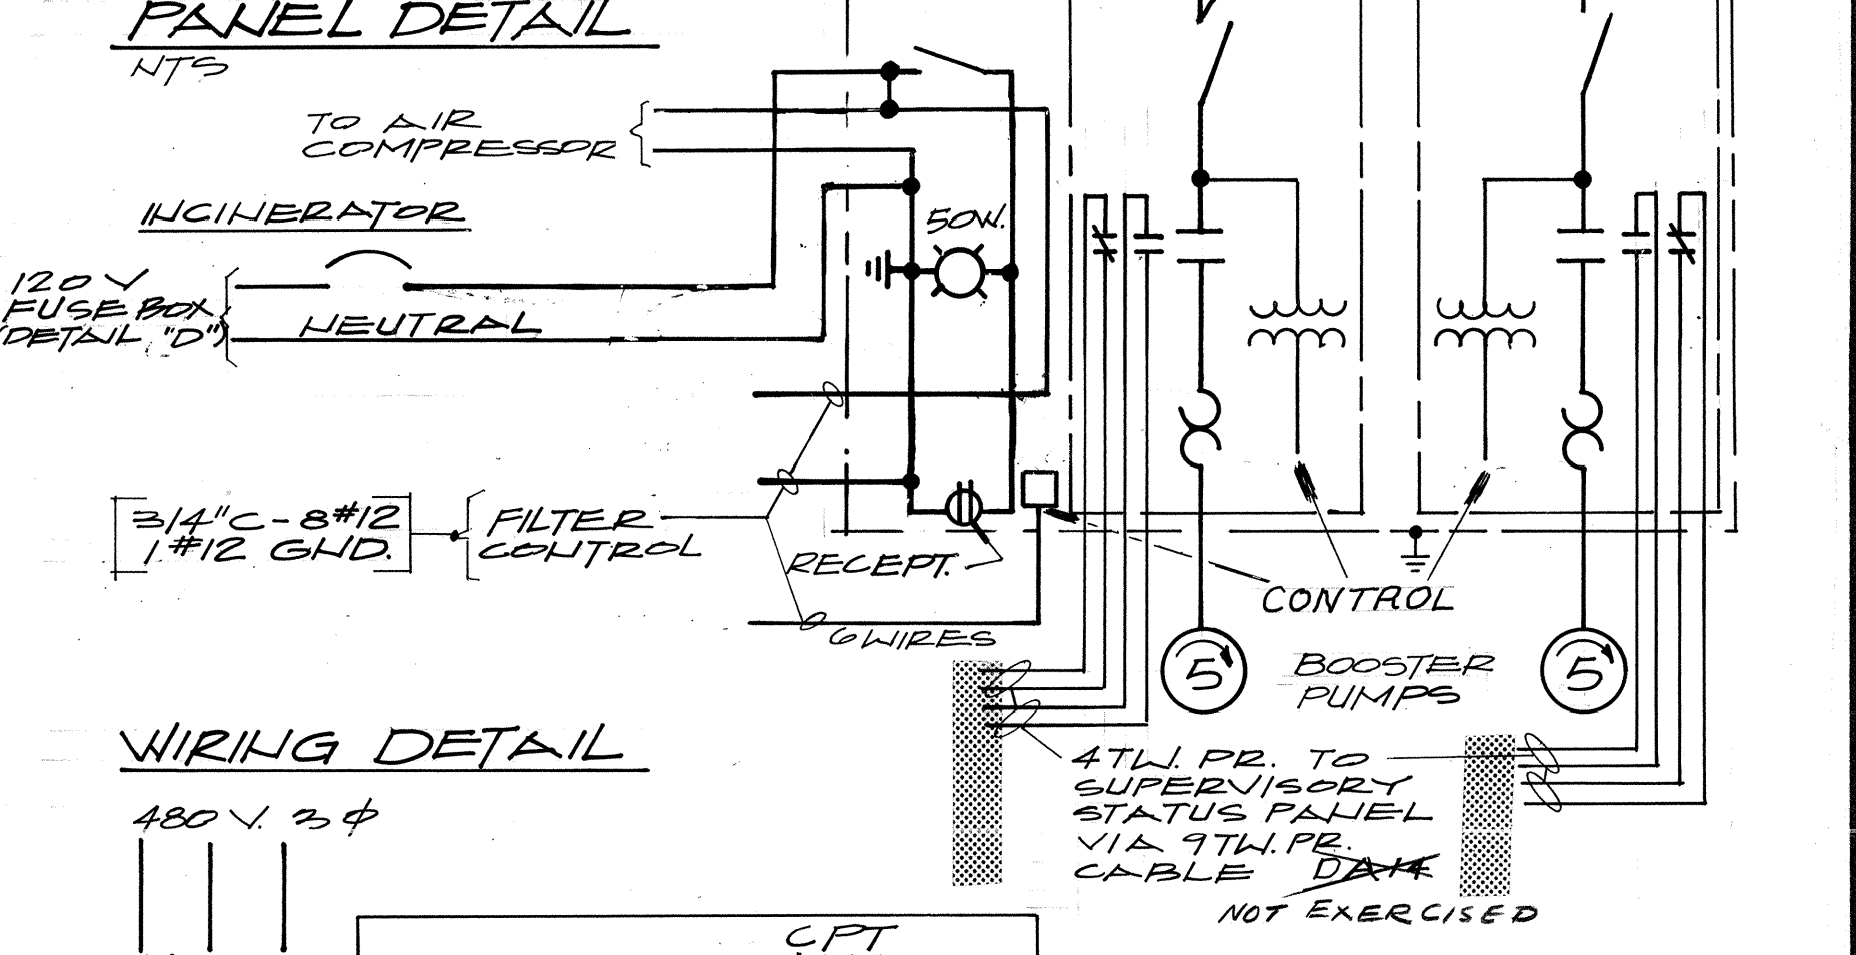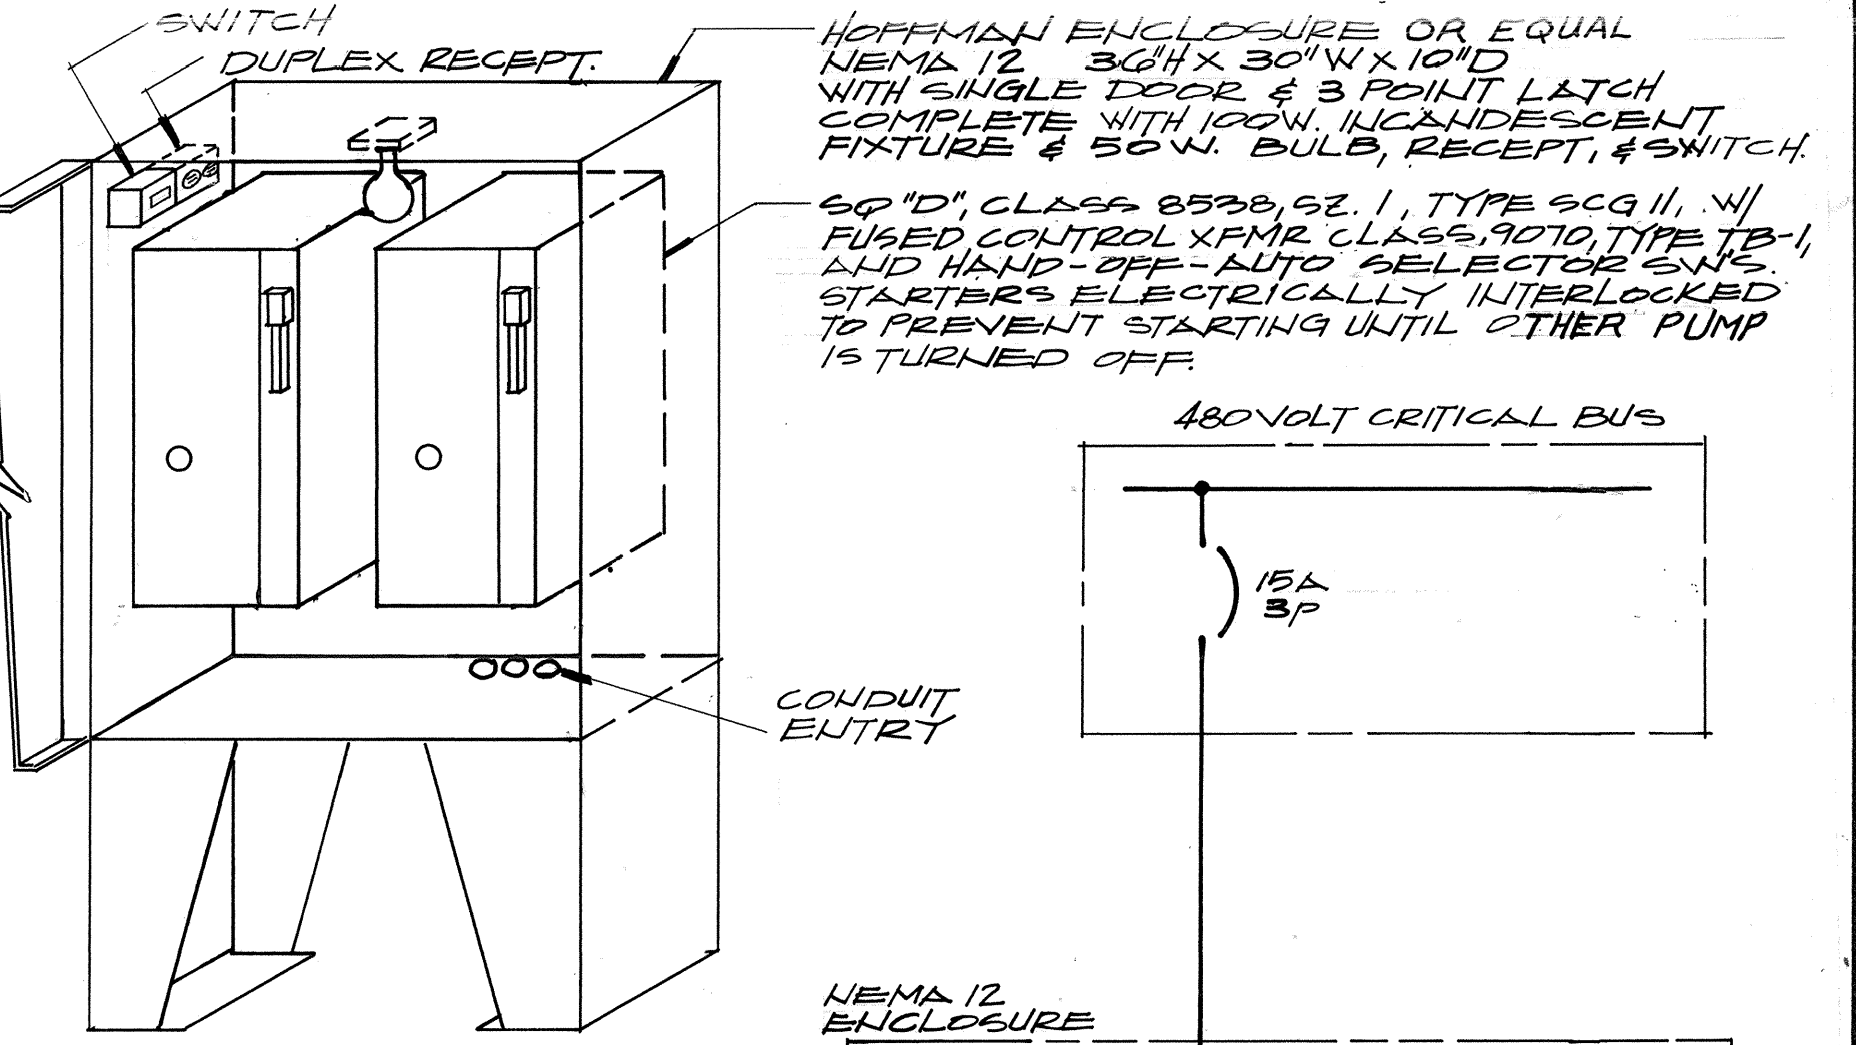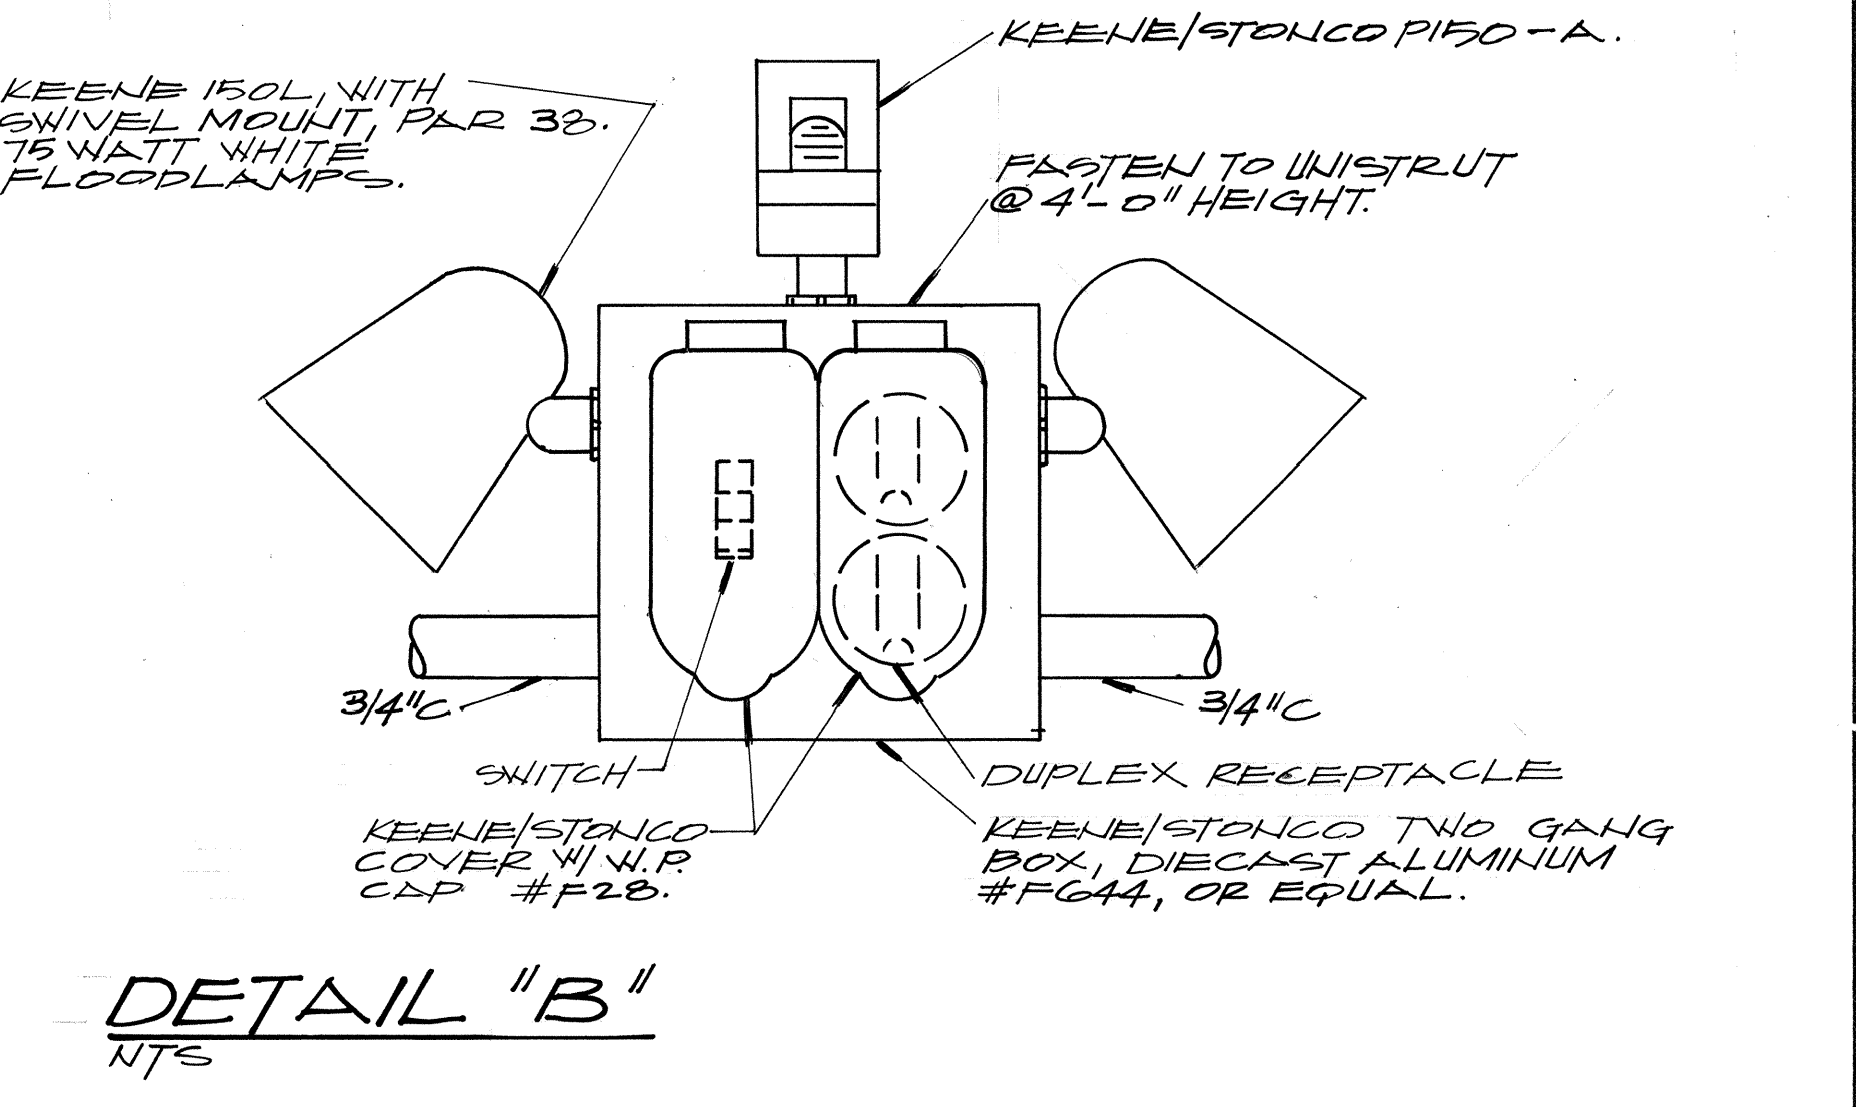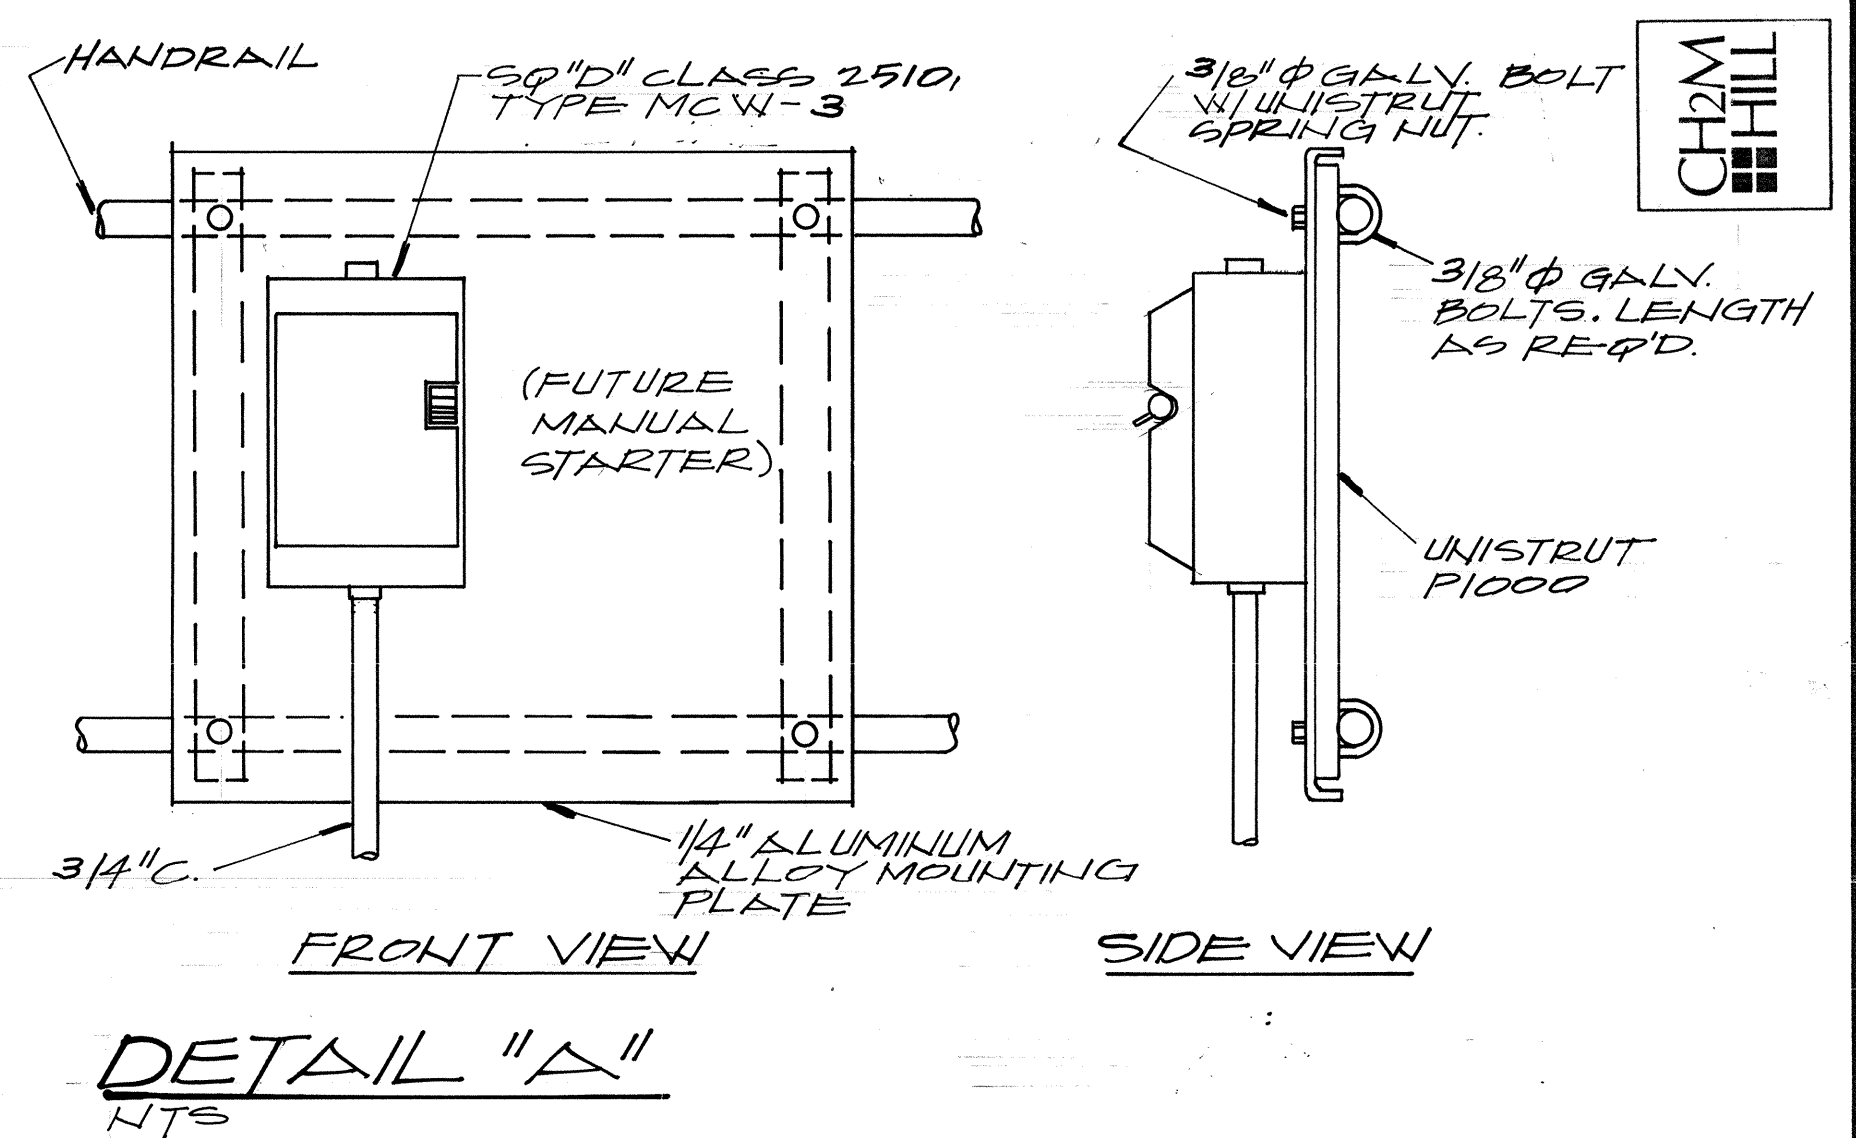

DETAIL "C"
NTS


* THESE ITEMS TO BE FURNISHED BY CONTRACTOR. BUILDING TO BE SUPPLIED PRE-WIRED.

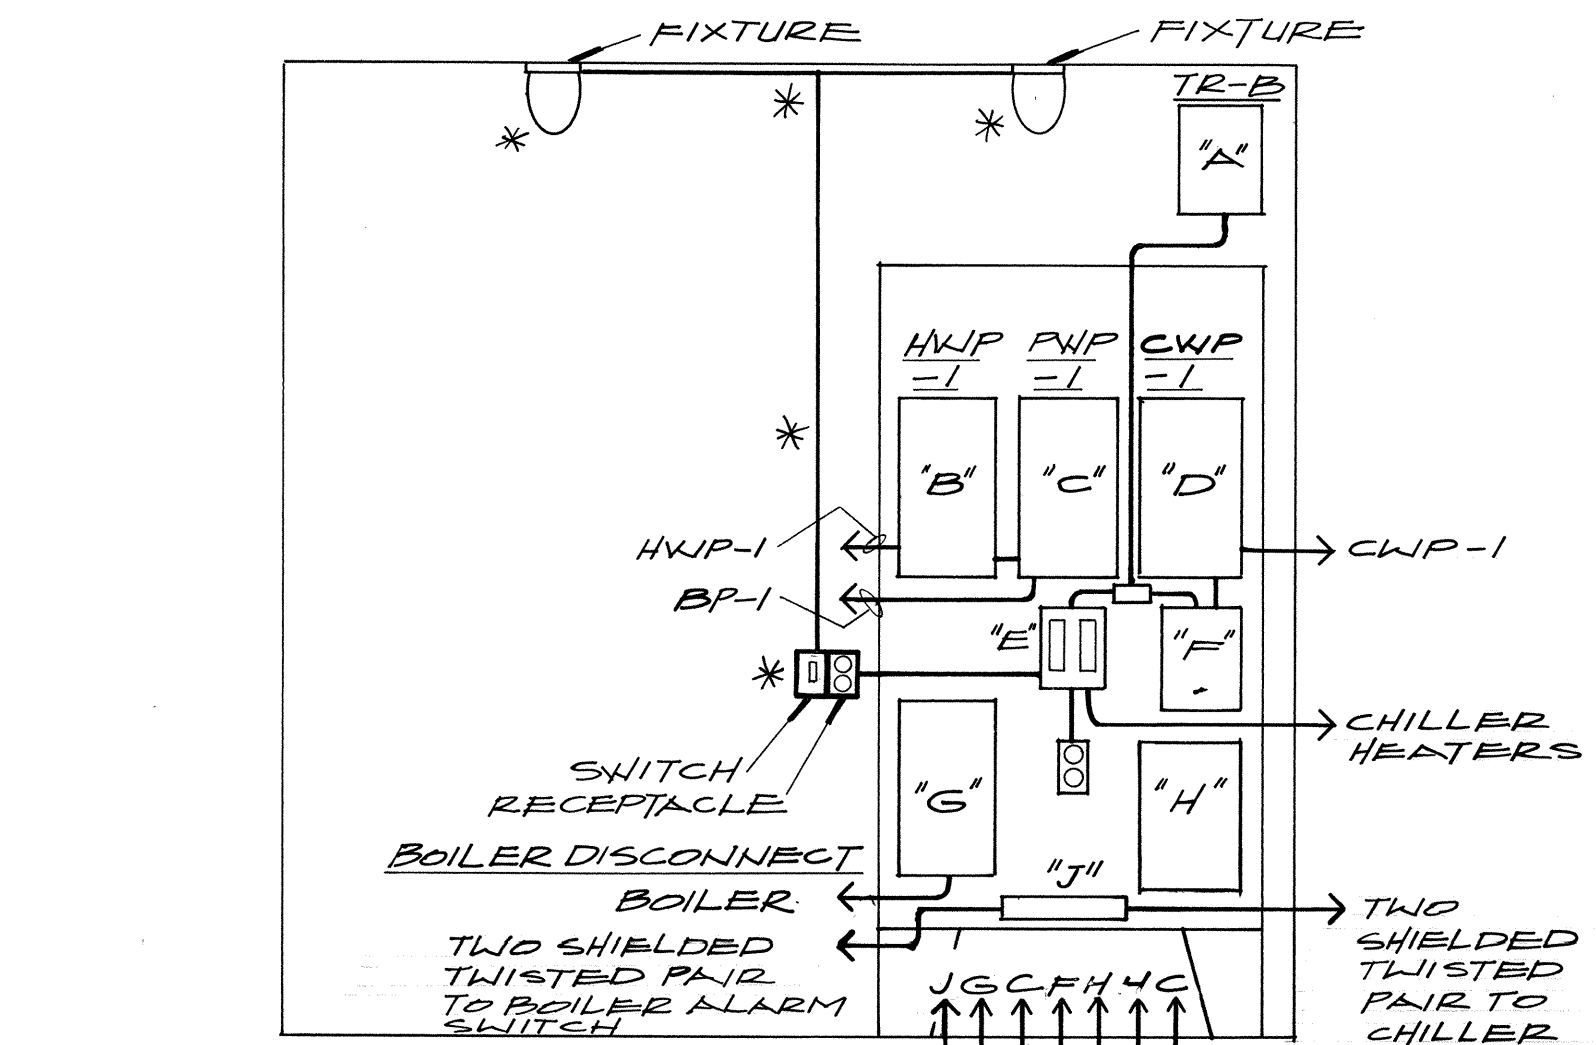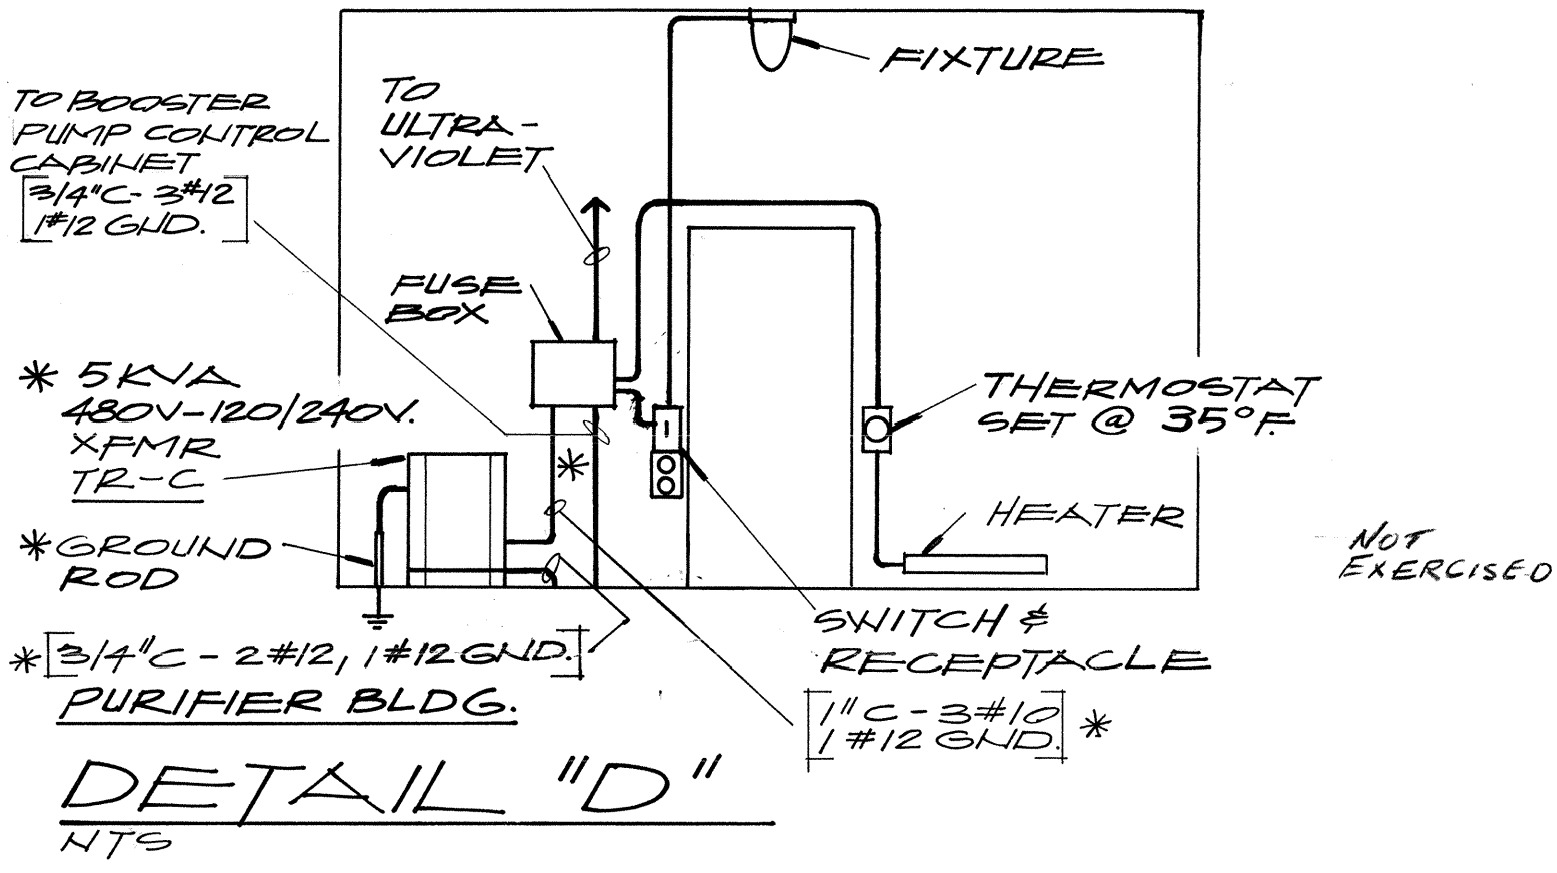


NOTES

- "A" 5KVA DRY TYPE TRANSFORMER
- "B" NON-FUSED COMBINATION STARTER
- "C" 50" D CLASS 8533 TYPE SG-II COMPLETE STOP-START RB'S
- "E" BREAKER PANEL, 50" D 400P WITH GROUND BAR & 2-20A. CIRC. BRKR.
- "F" FUSIBLE DISCONNECT 50" D H261 WITH 10A. FUSE.
- "G" NON-FUSIBLE DISCONNECT 50" D HU363
- "H" NON-FUSIBLE DISCONNECT 50" D HU362
- "J" TERMINAL BLOCK FOR 9TW.PR.


DETAIL "E"
NTS
* SUPPLIED WITH BUILDING

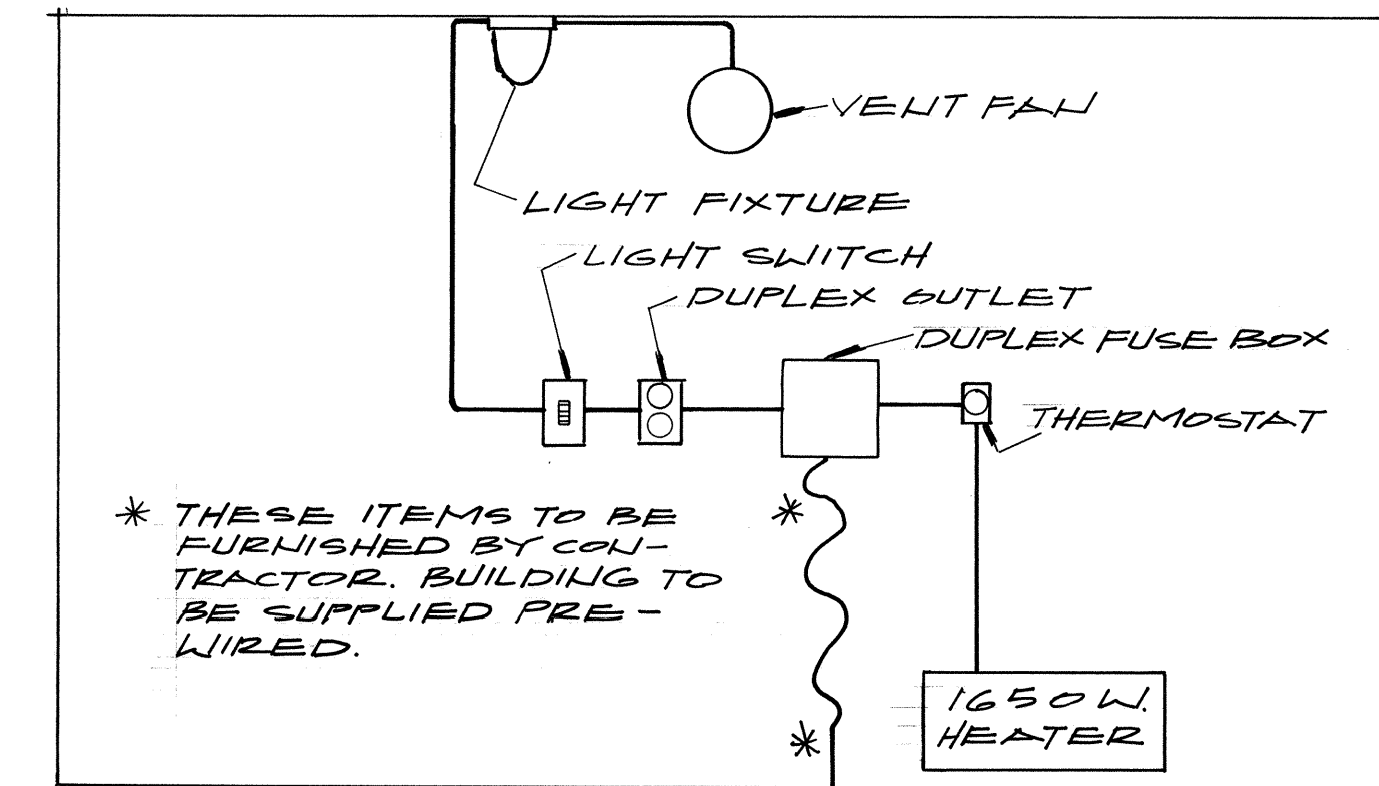






CHLORINATOR BLDG.
DETAIL "F"
NTS

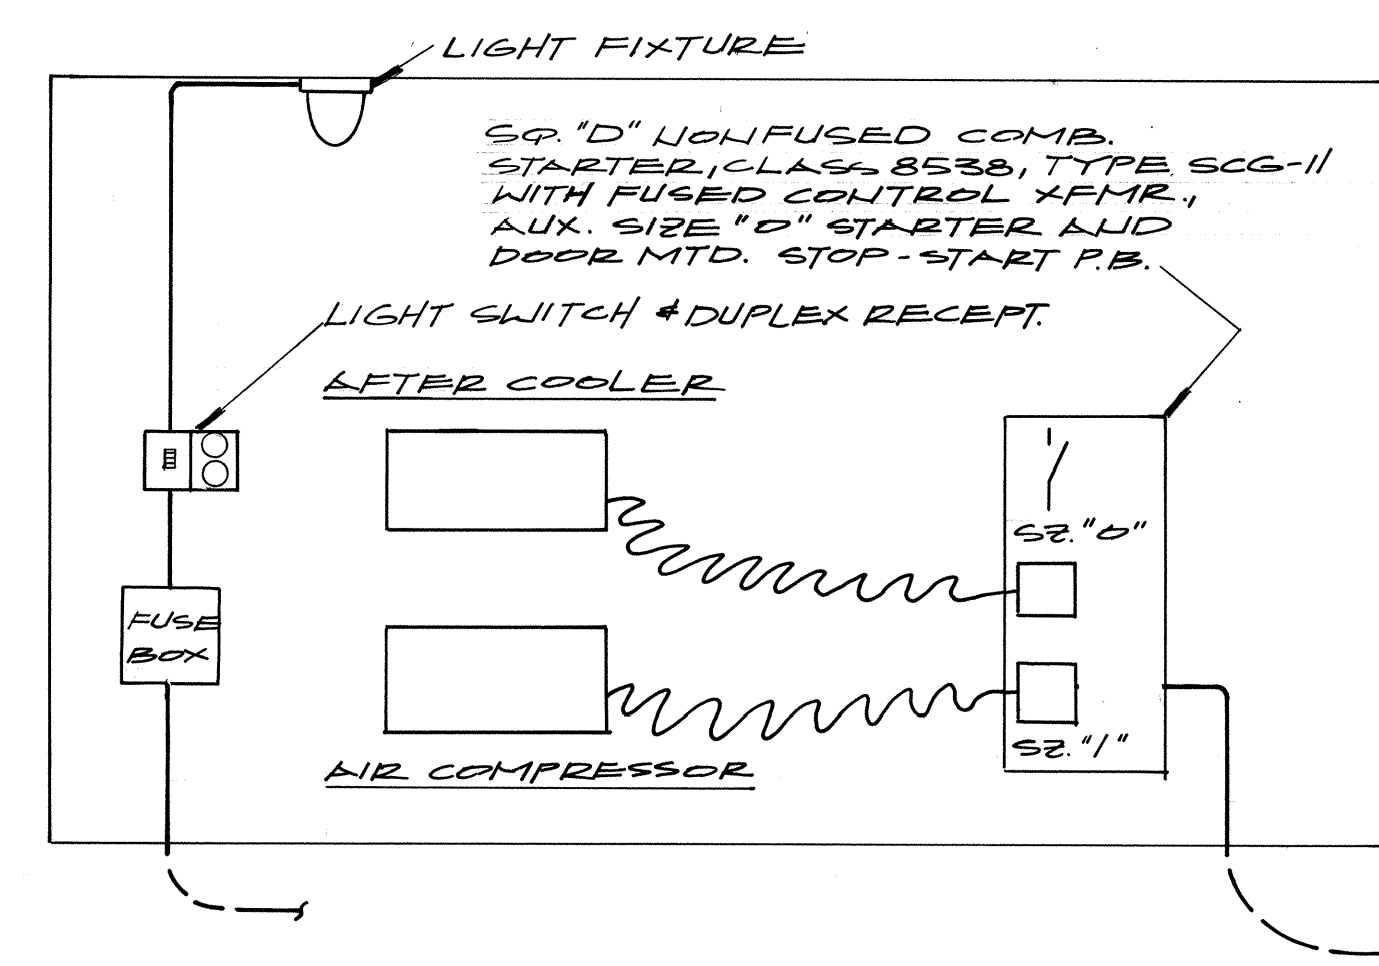


AIR COMPRESSOR BLDG.
DETAIL "G"
NTS

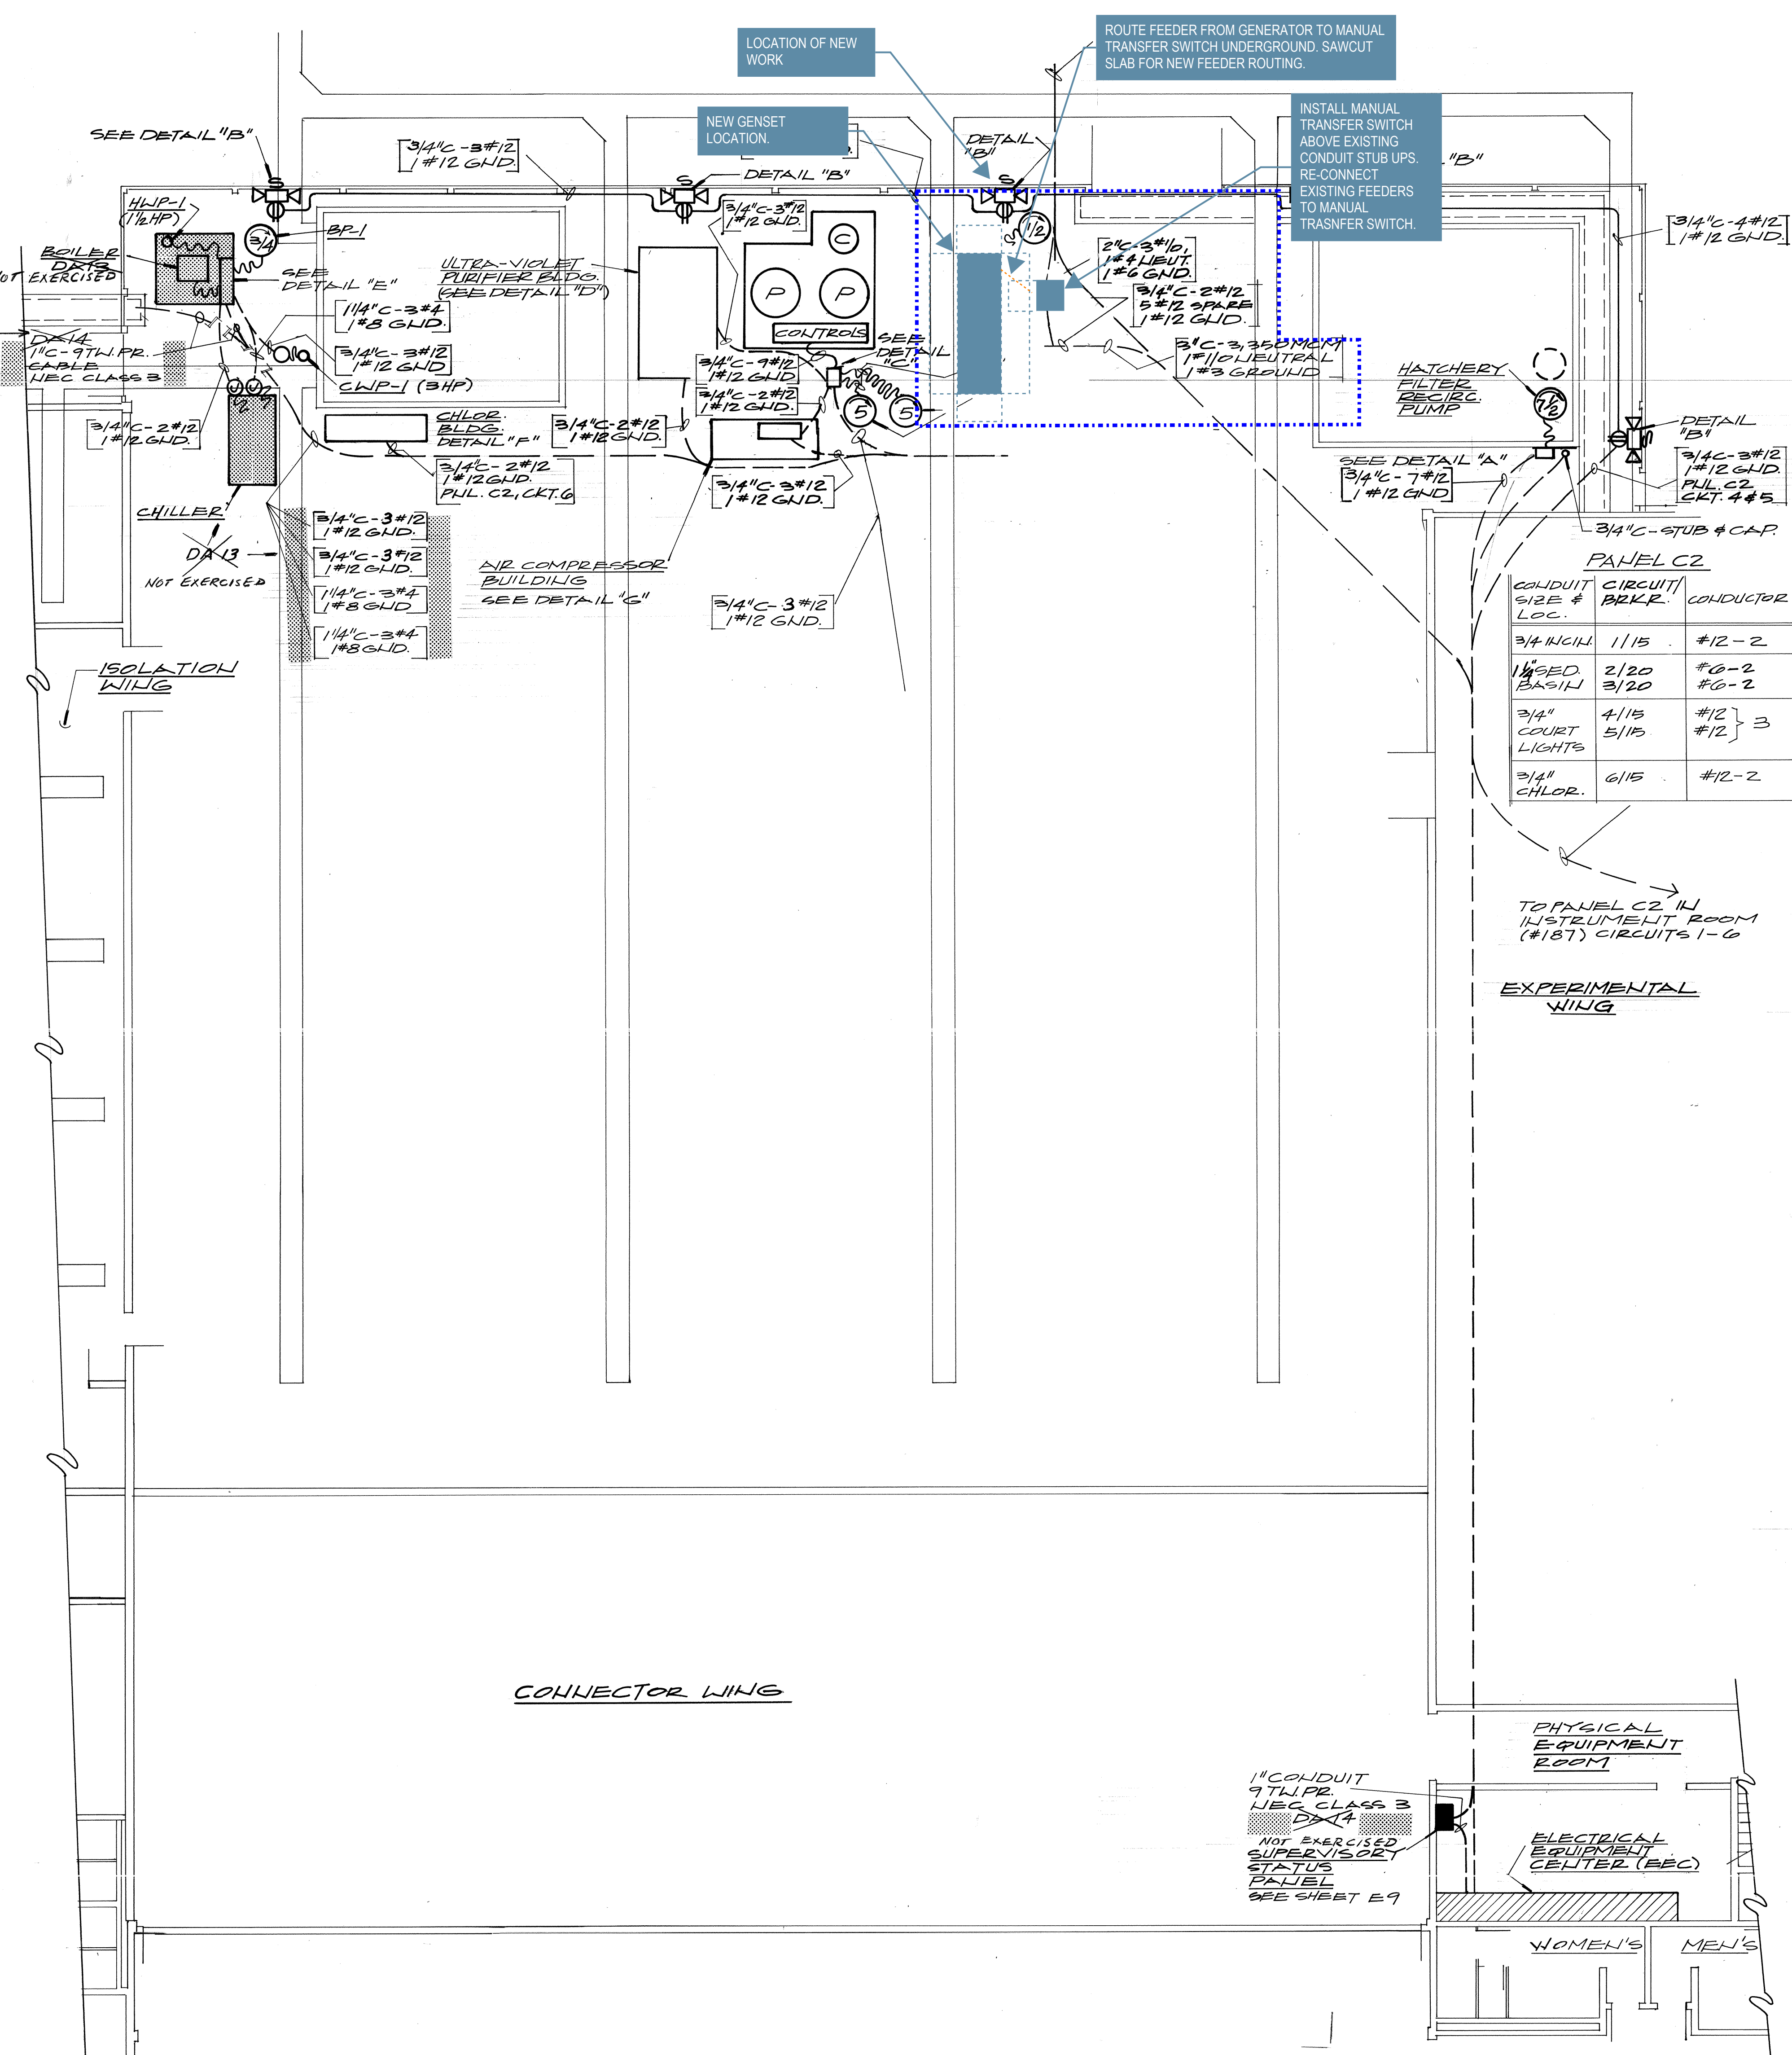


NEW WORK FLOOR PLAN

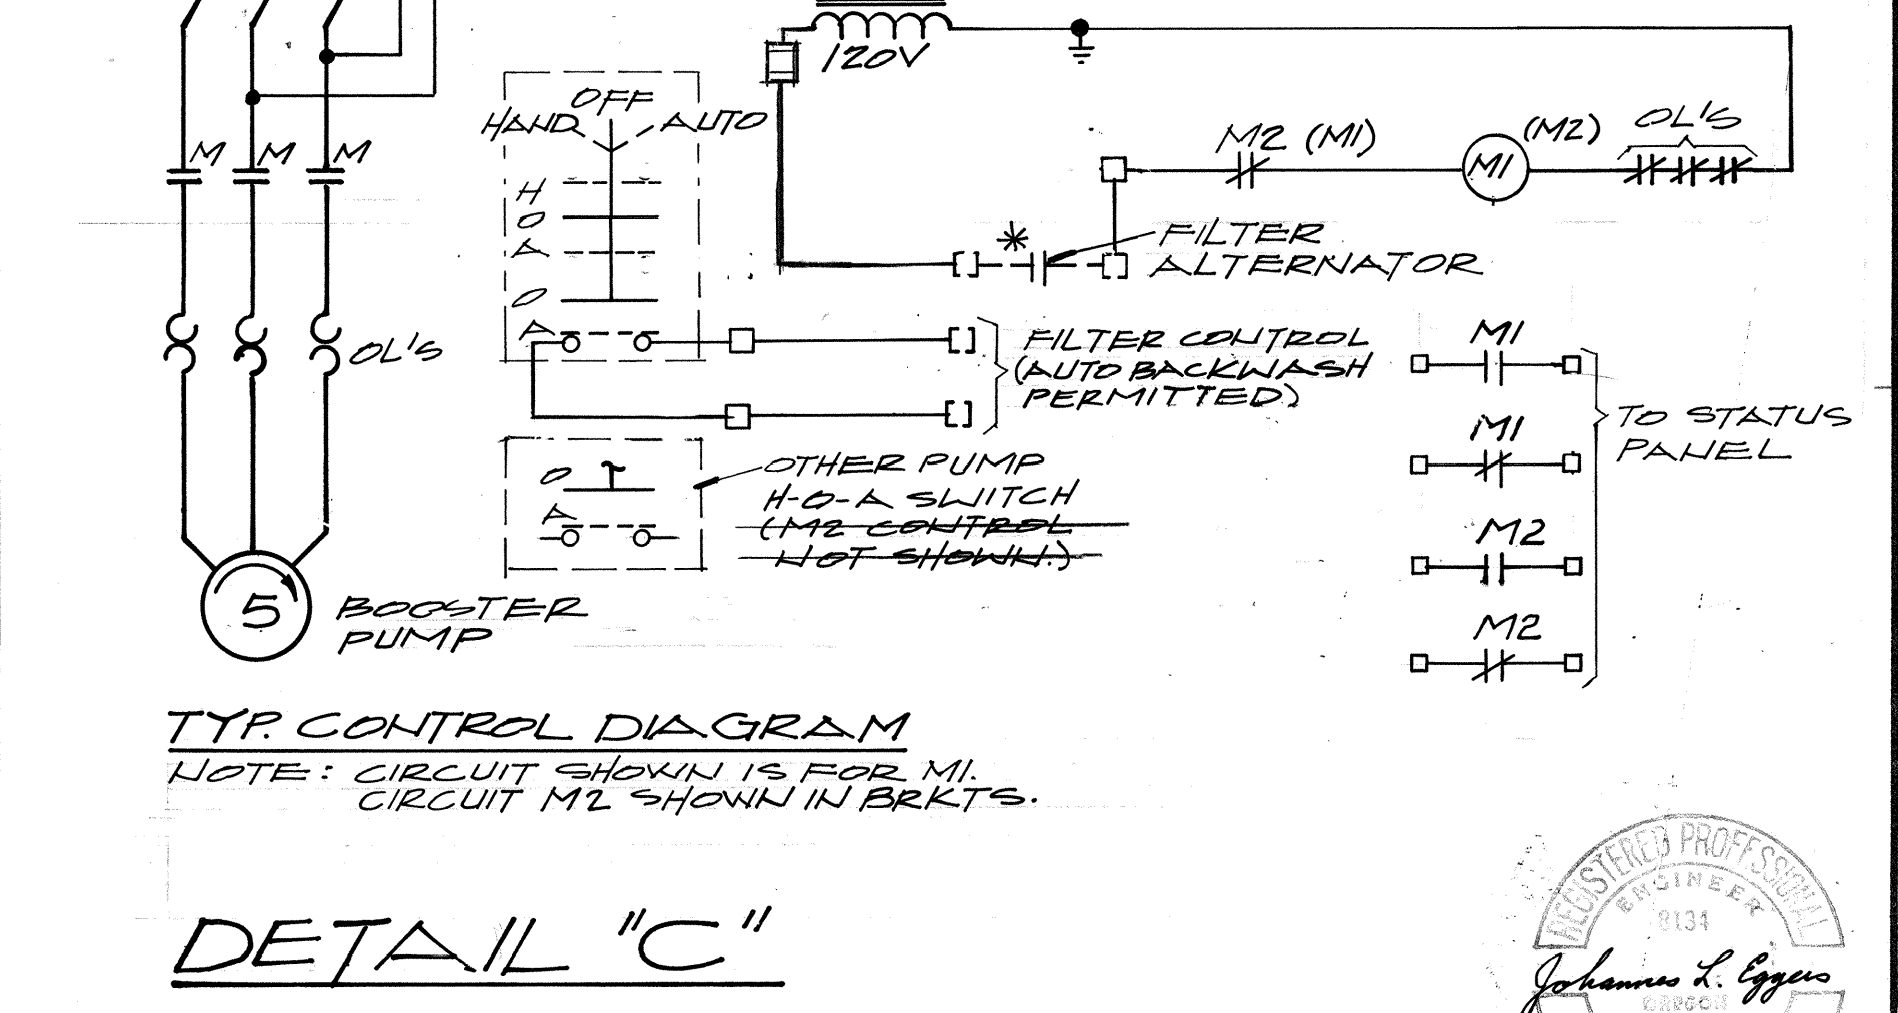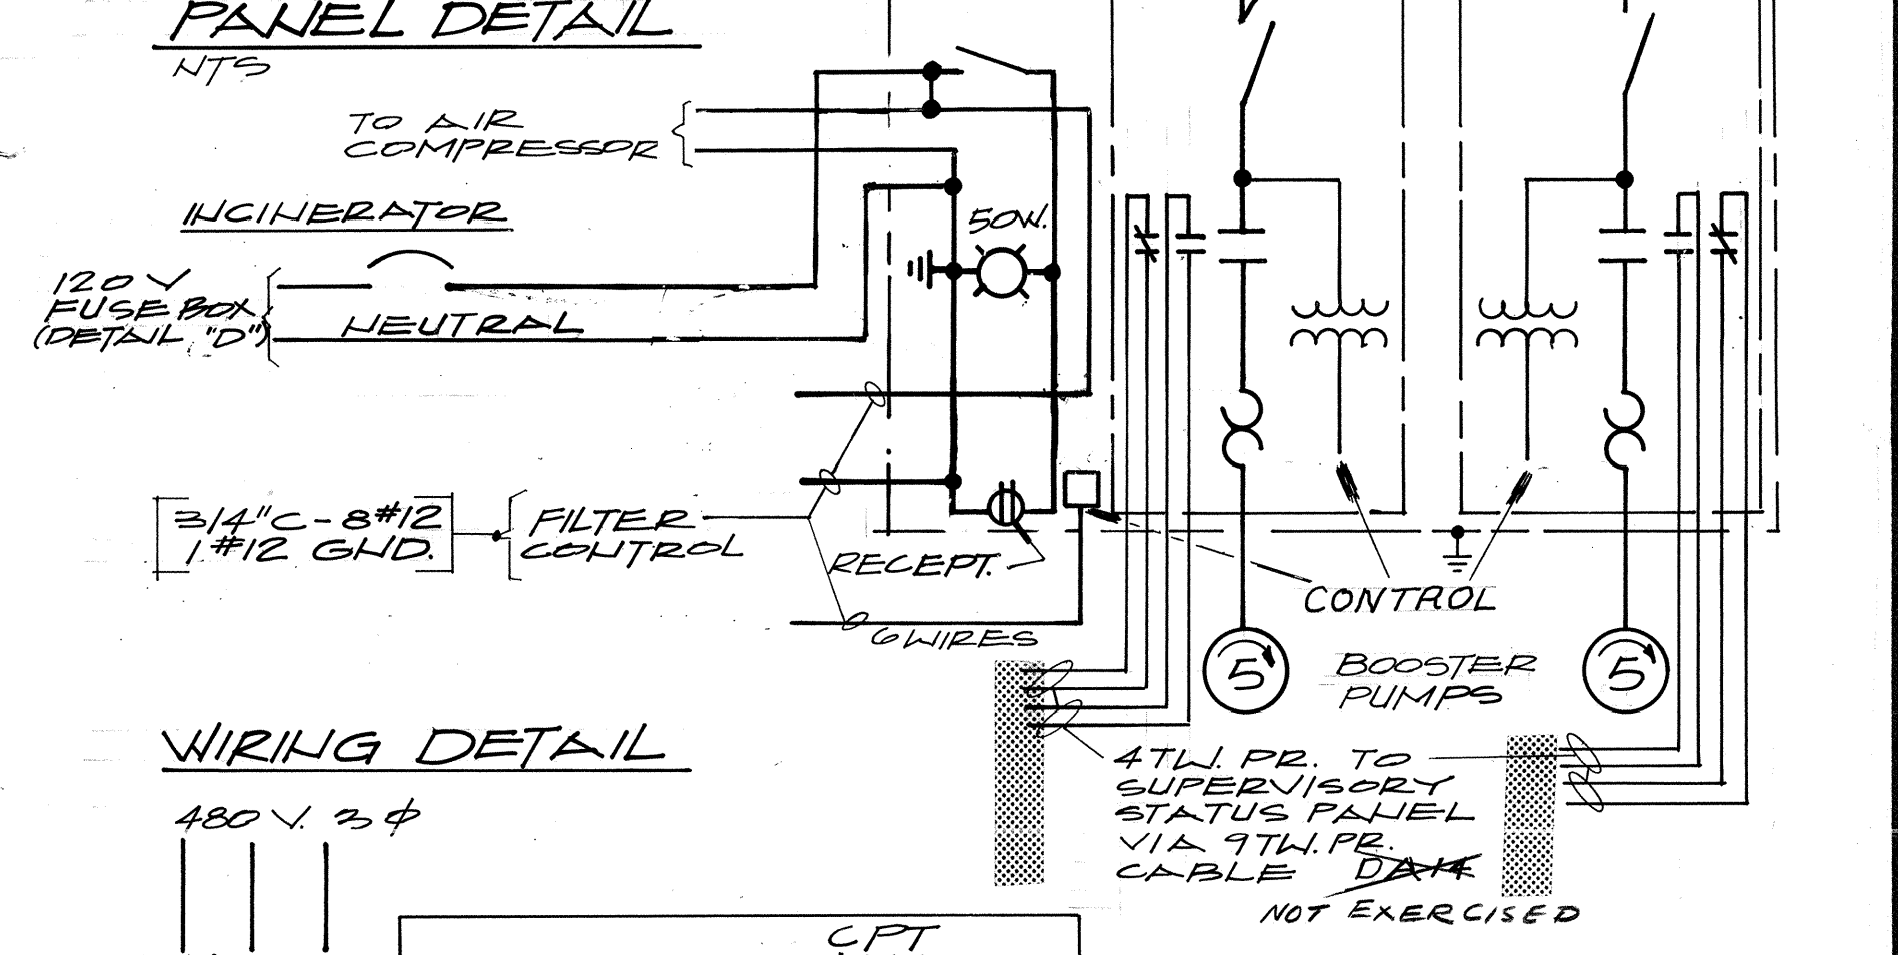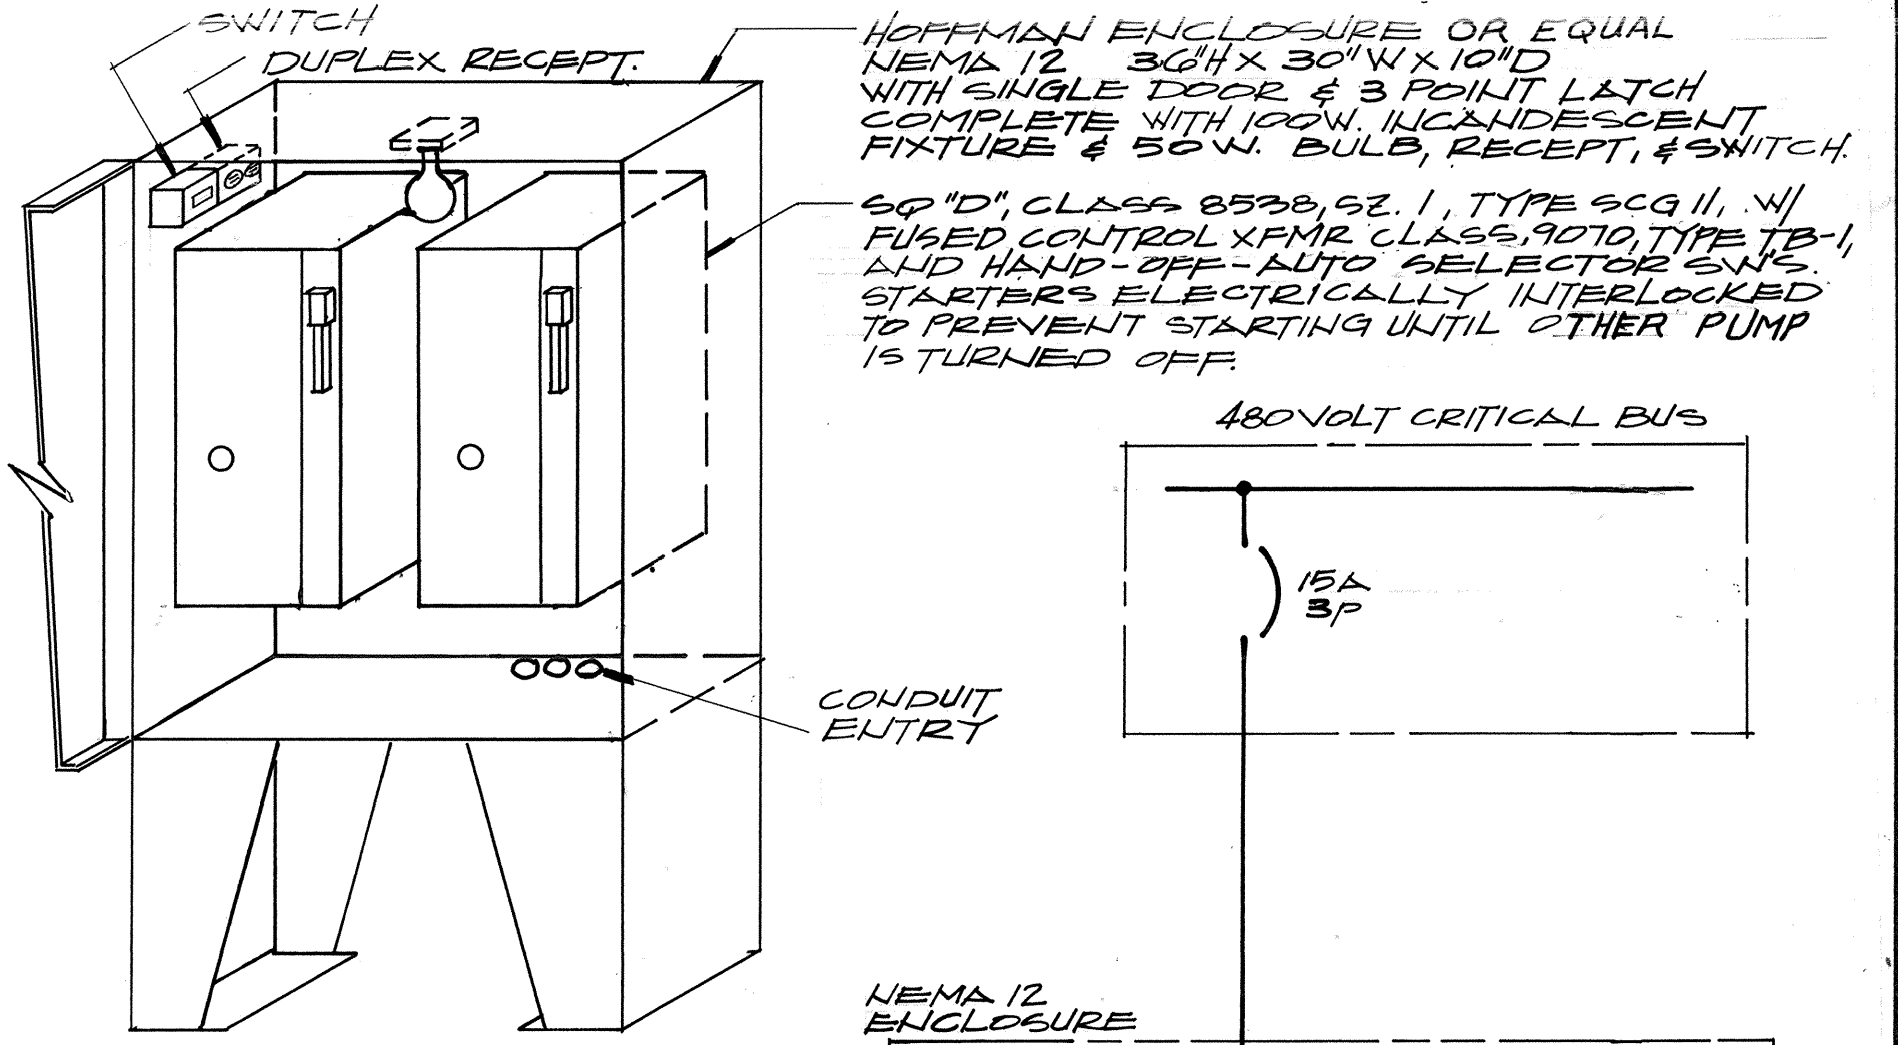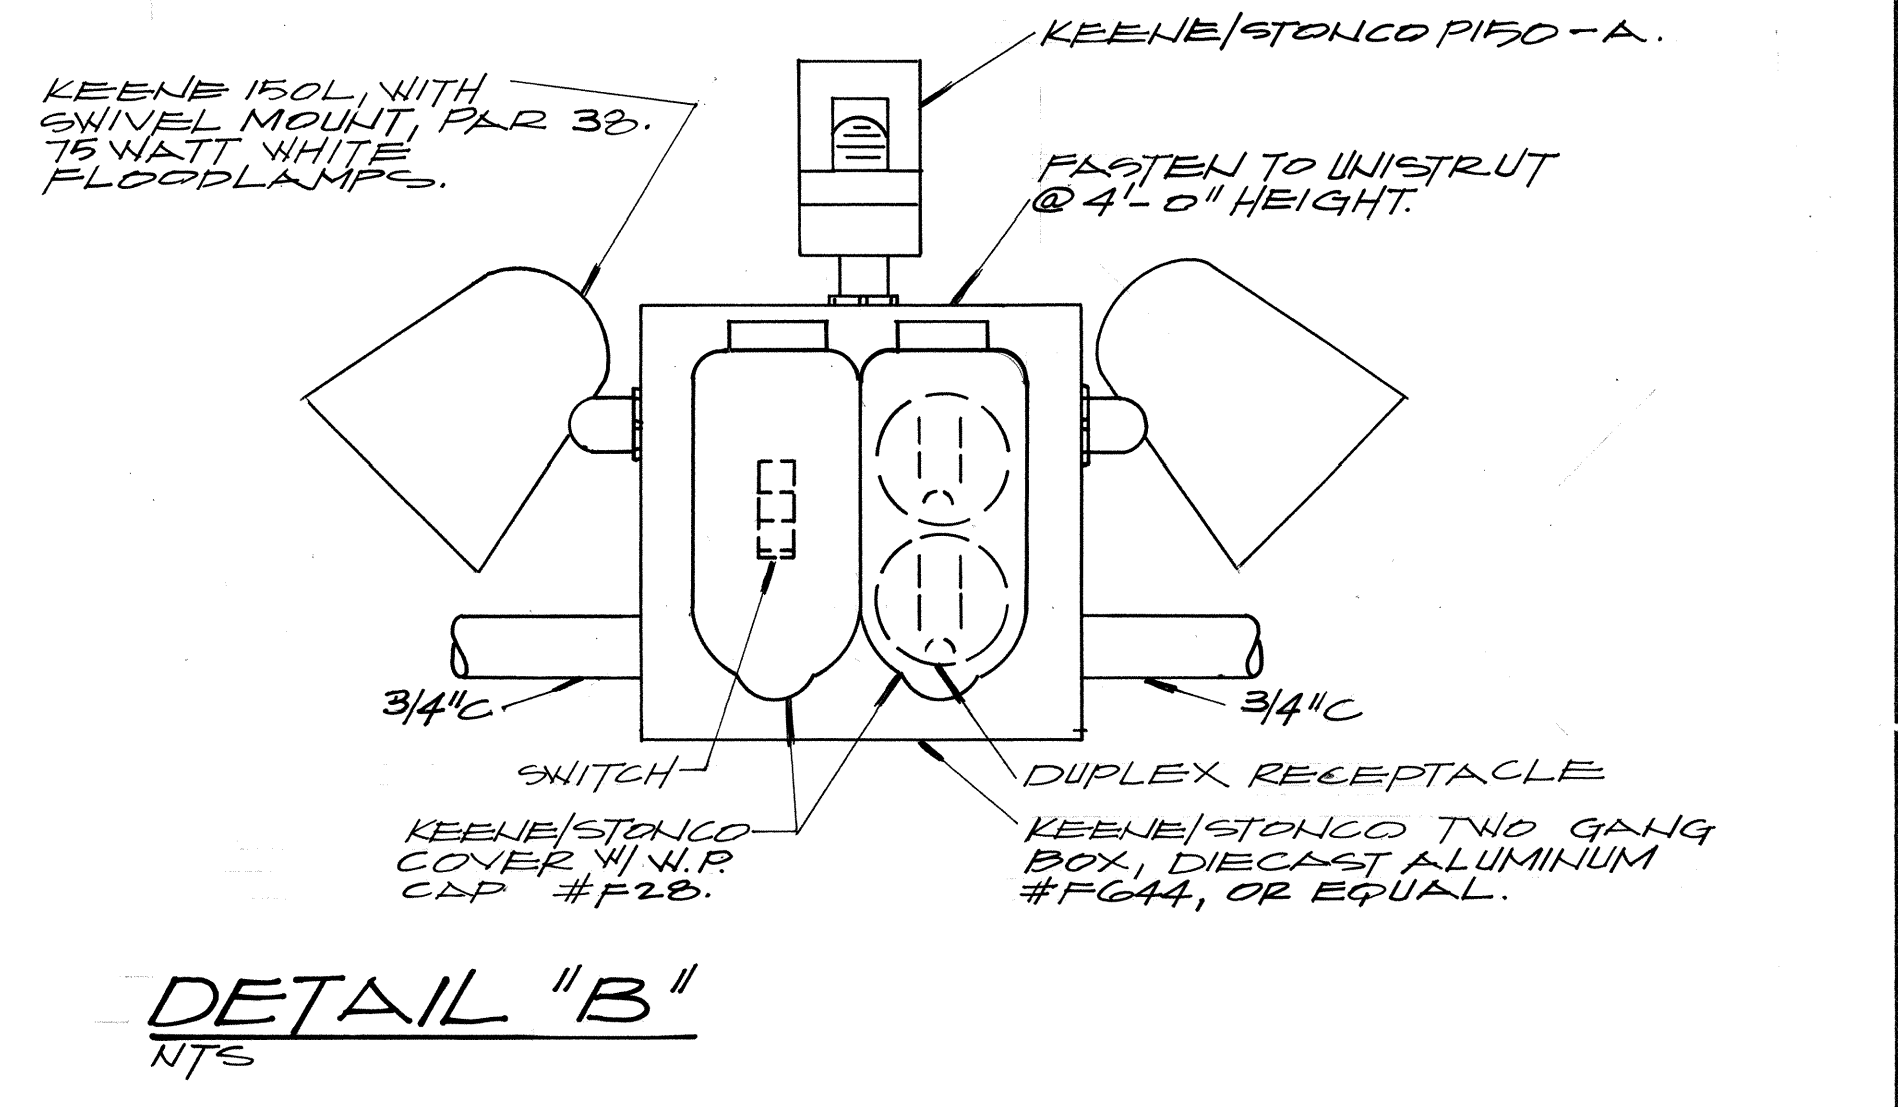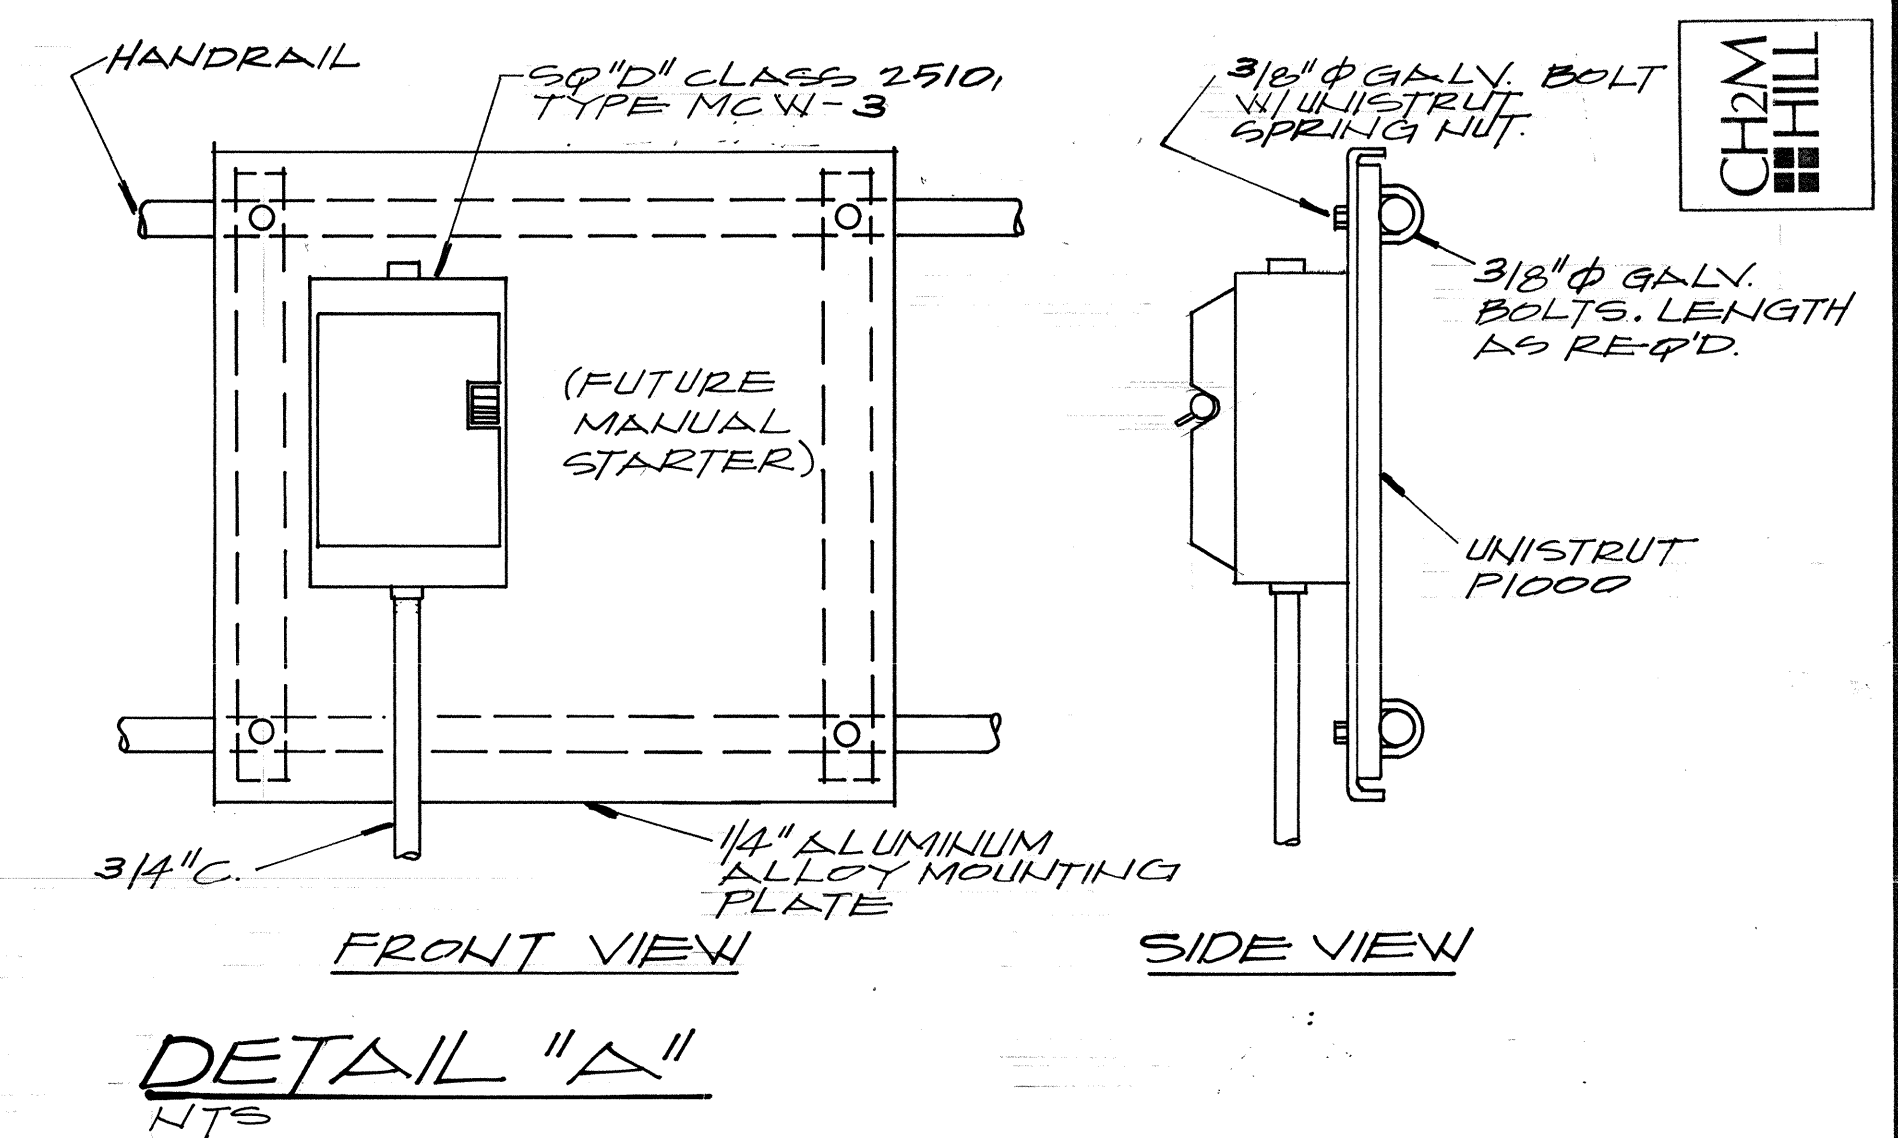

DETAIL "C"
NTS

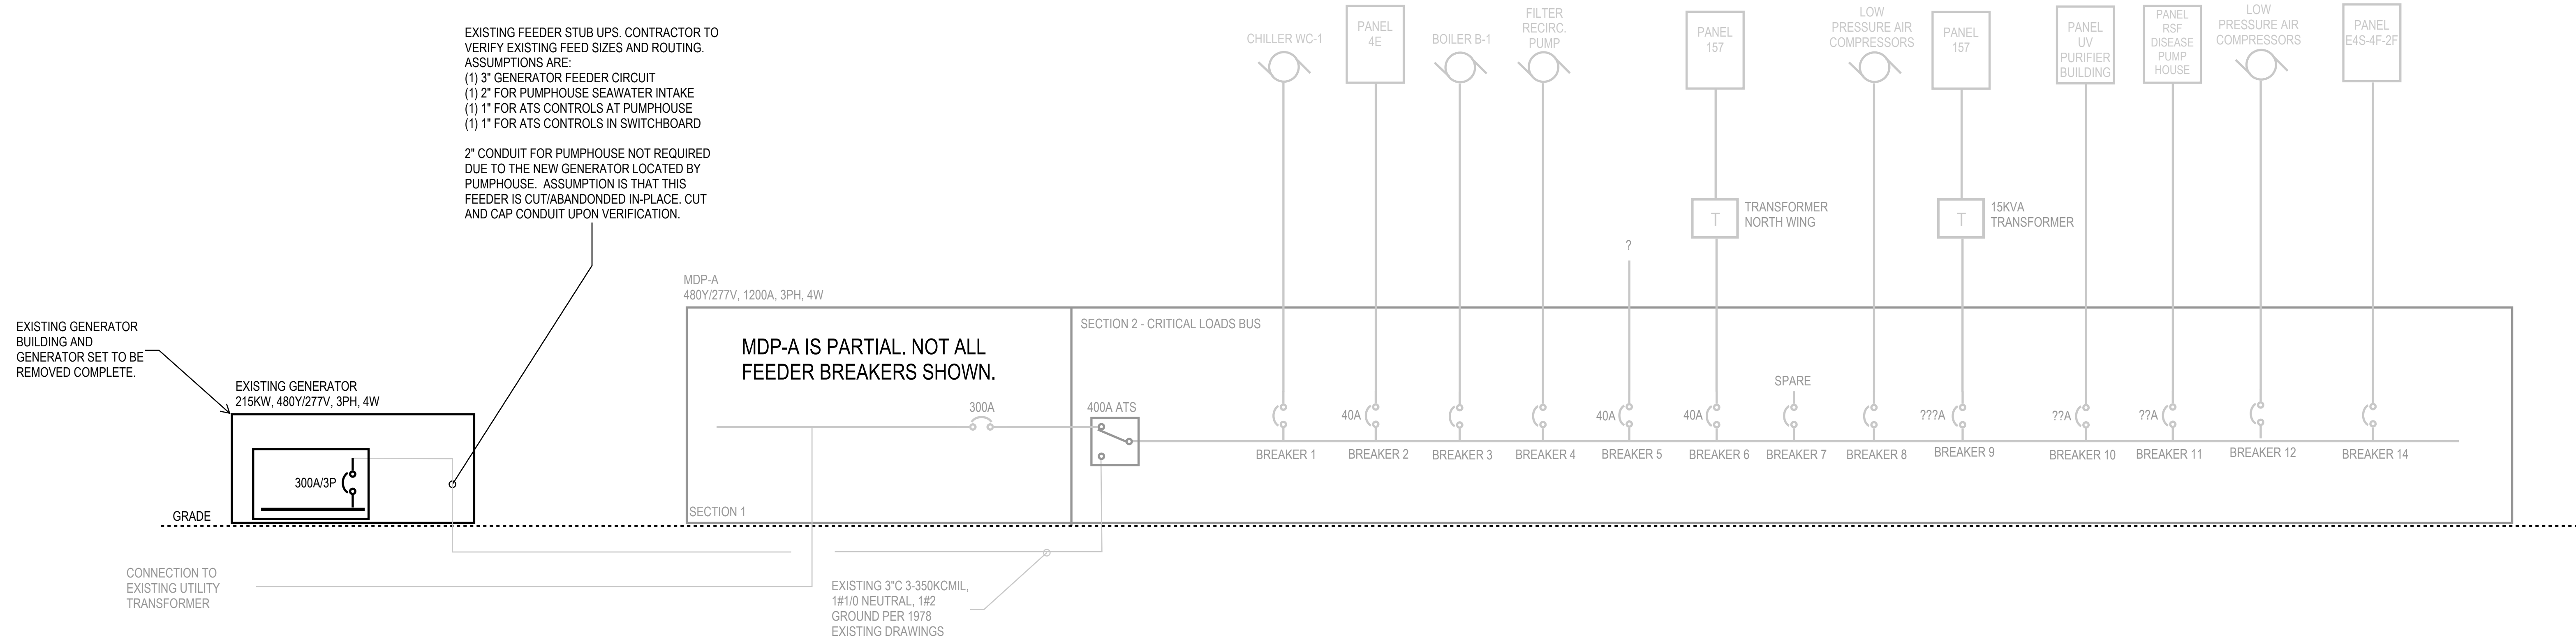

1 ELECTRICAL DEMOLITION ONE-LINE DIAGRAM
E0.03/ NTS

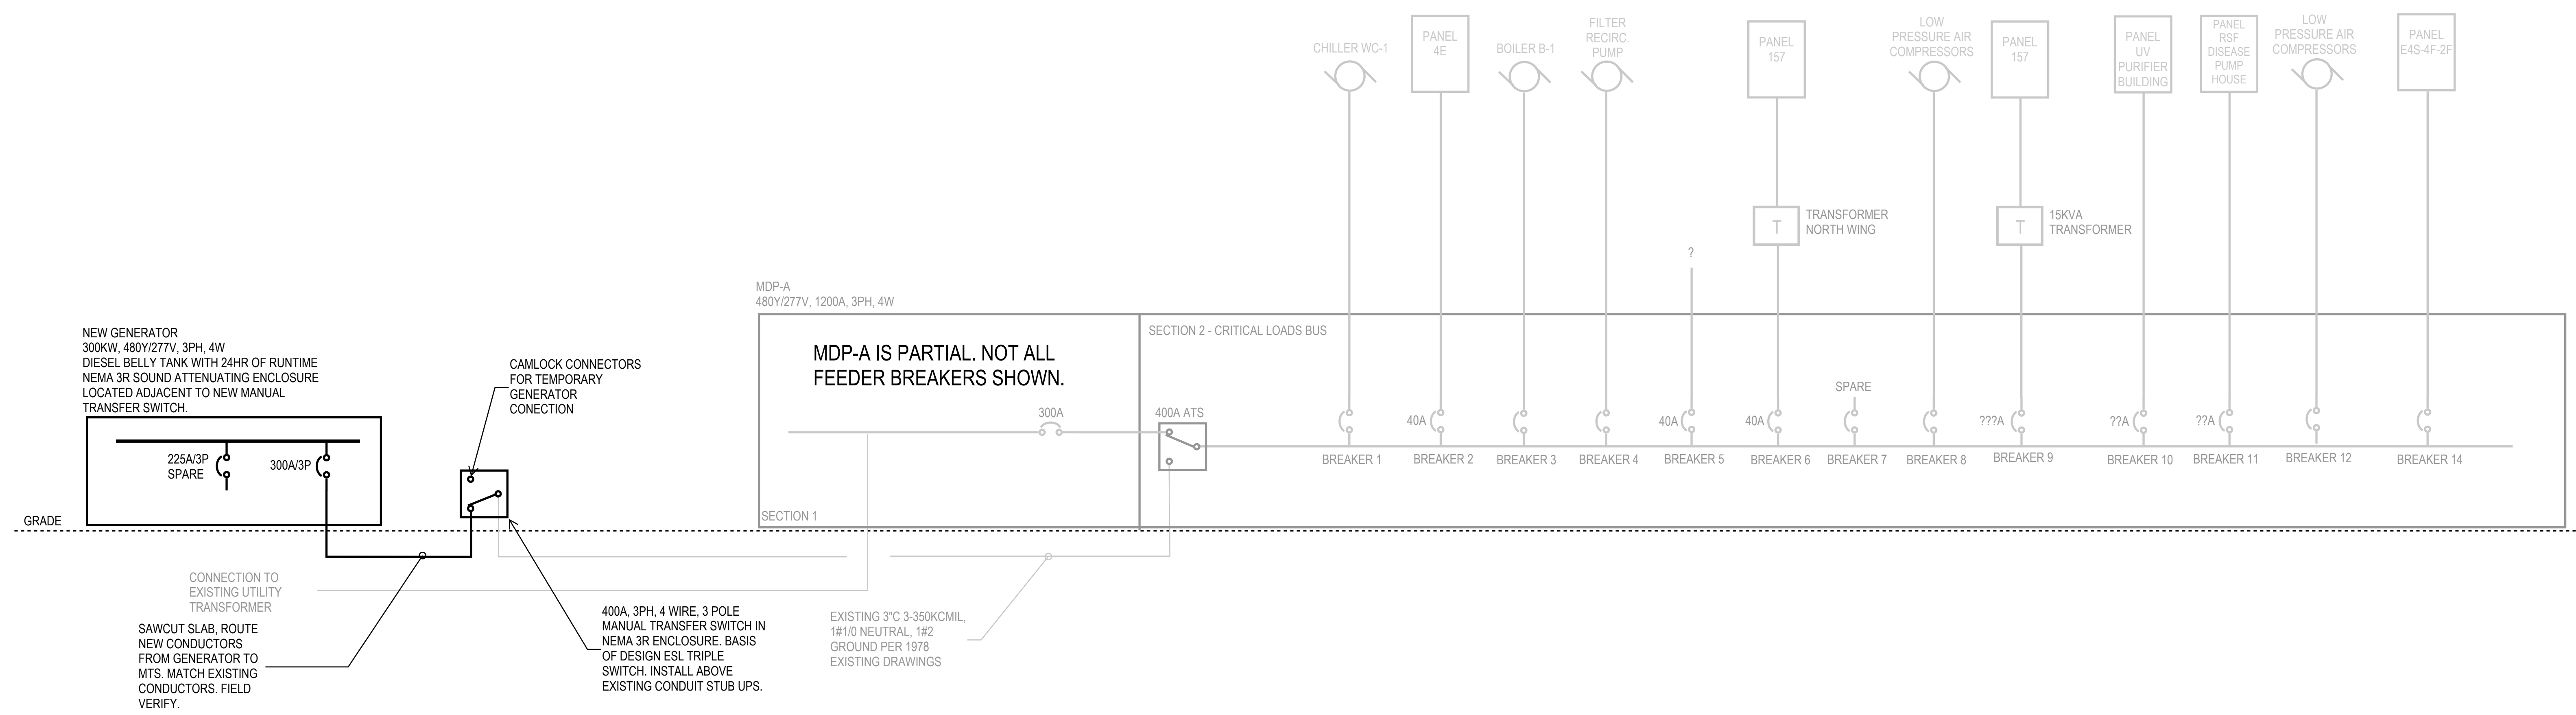

2 ELECTRICAL ONE-LINE DIAGRAM
E0.03/ NTS

REFERENCE ONLY UNLESS STAMP IS PLACED
(PLACE STAMP HERE)

© MACKENZIE 2024. ALL RIGHTS RESERVED. THESE DRAWINGS ARE THE PROPERTY OF MACKENZIE AND ARE NOT TO BE USED OR REPRODUCED IN ANY MANNER, WITHOUT PRIOR WRITTEN PERMISSION.

REVISION SCHEDULE		
Delta	Issued As	Issue Date

SHEET TITLE:
ELECTRICAL SITE DEMOLITION PLAN